



F.A.I. RTE.	SECTION	COUNTY	TOTAL SHEETS	SHEET NO.
90/94	2004-073RS	COOK	74	35
STA. 188+00		TO STA. 193+00		
FED. ROAD DIST. NO. 1 ILLINOIS FED. AID PROJECT				

62812

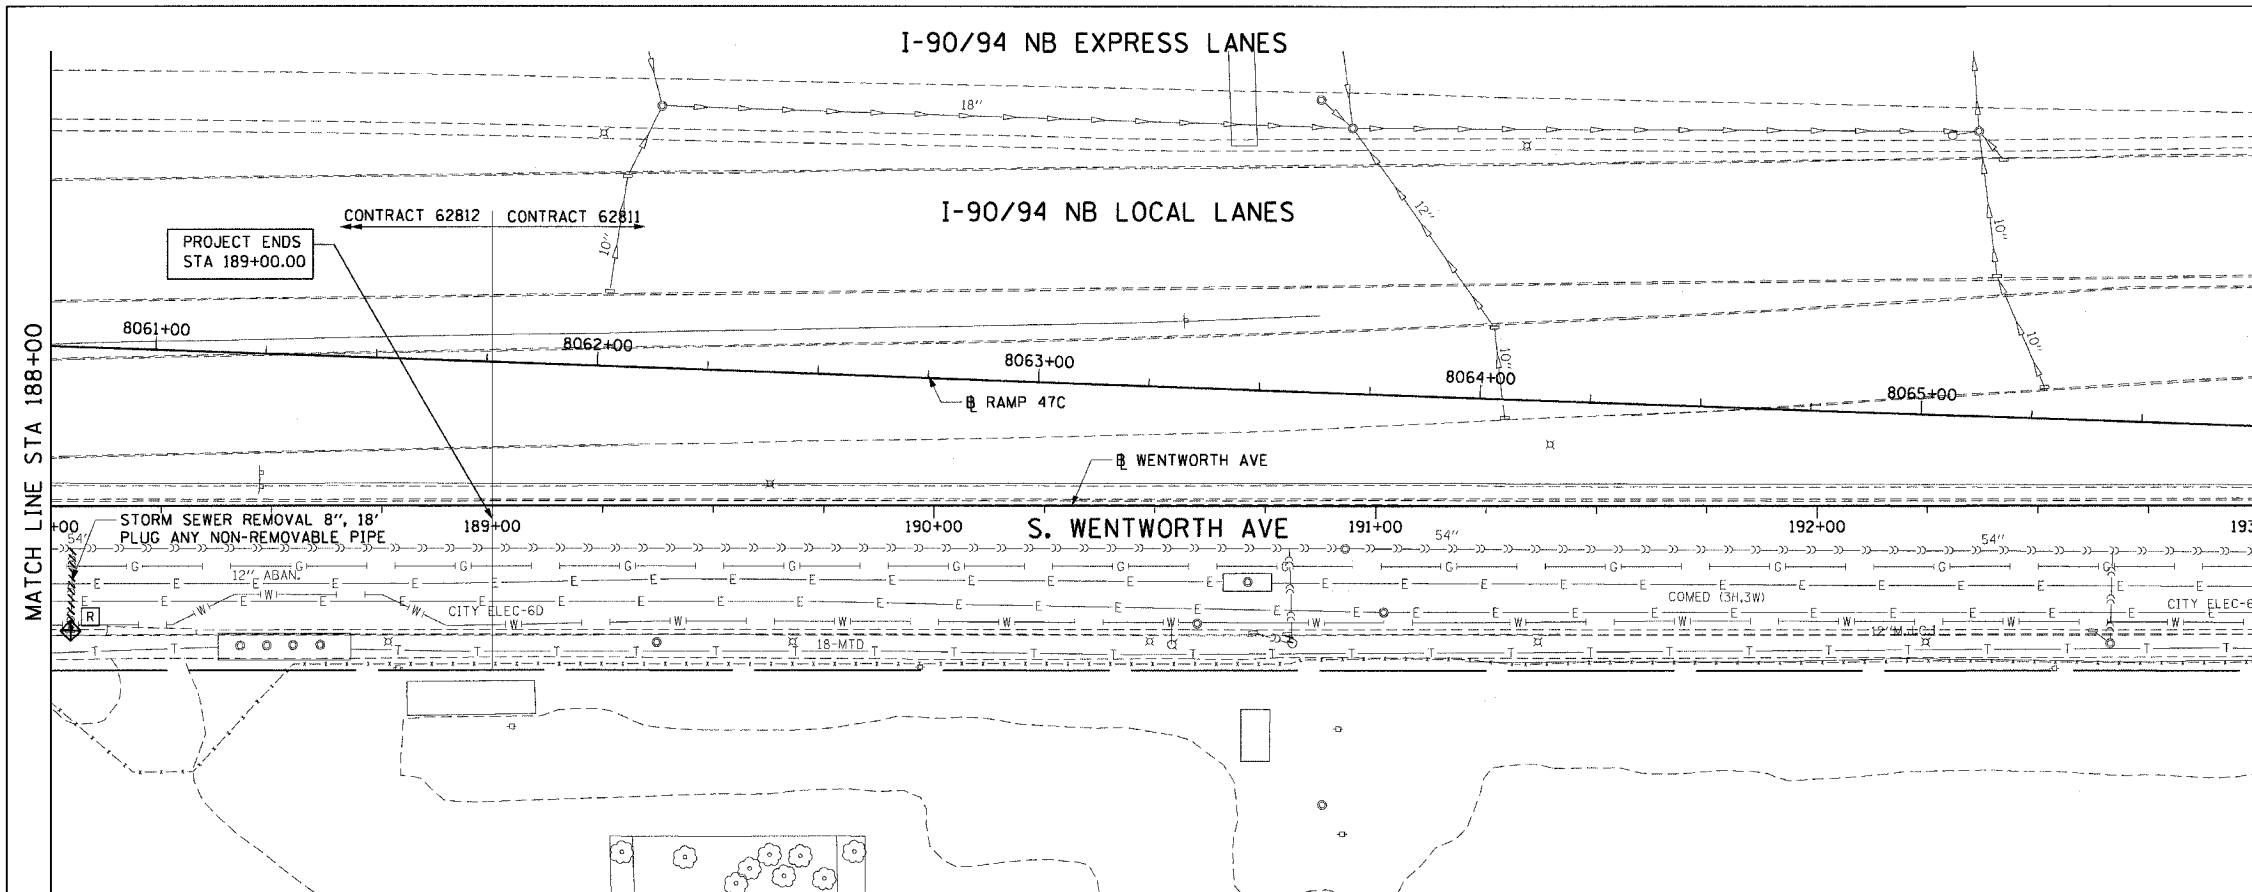

- LEGEND: EXISTING**
- INLET
 - CATCH BASIN
 - MANHOLE
 - STORM SEWER
 - COMBINED SEWER
 - PIPE UNDERDRAIN
 - [R] STRUCTURE TO BE REMOVED
 - [ADJ] STRUCTURE TO BE ADJUSTED
 - //// STORM SEWER REMOVAL
 - //// ABANDON STORM SEWER

NOTE:
ALL EXISTING OPEN LID DRAINAGE STRUCTURES TO REMAIN THRU STAGE 2 OF CONTRACT 62586 SHALL HAVE INLET FILTERS INSTALLED.

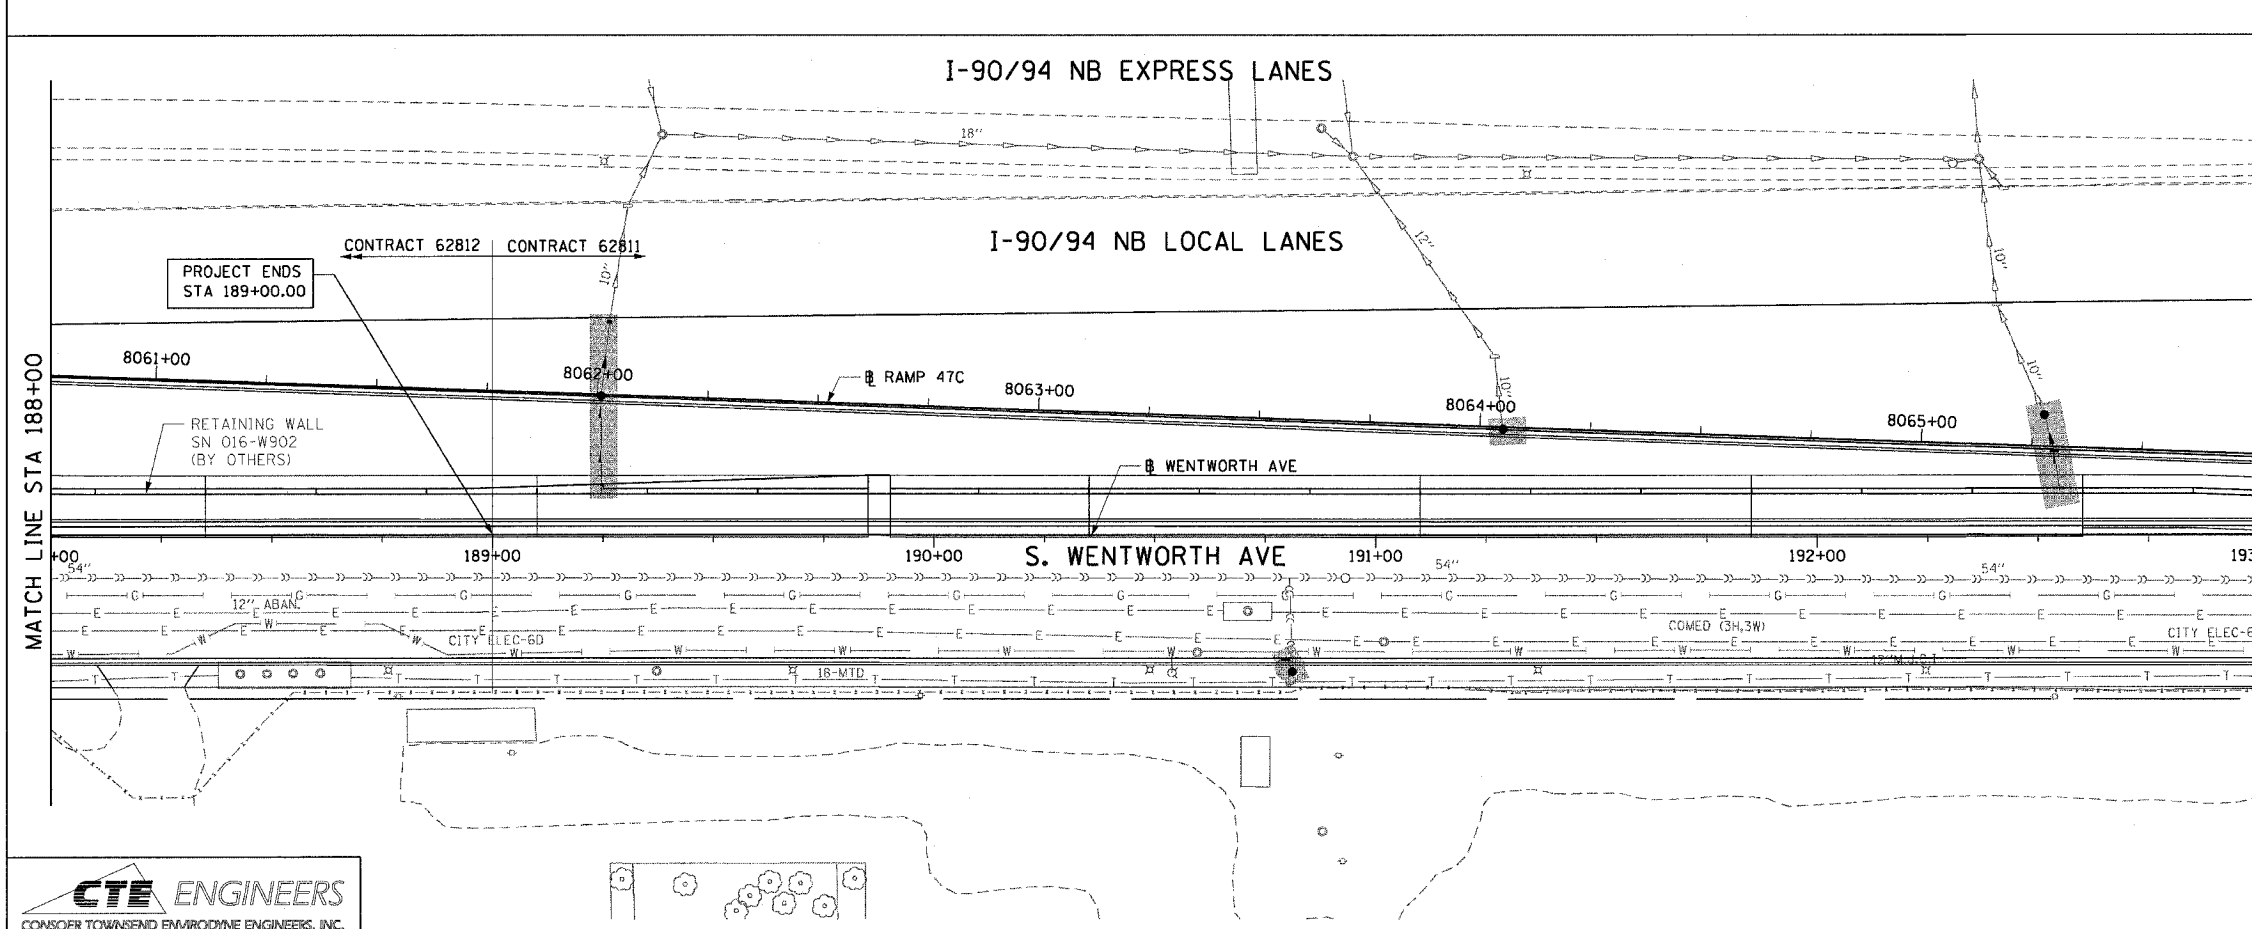

- EXISTING CONDITIONS AND REMOVAL**
- PROPOSED IMPROVEMENTS**
- LEGEND: PROPOSED**
- INLET
 - CATCH BASIN
 - MANHOLE
 - STORM SEWER
 - COMBINED SEWER
 - PIPE UNDERDRAIN
 - PROPOSED SWALE
 - EA 01 PROPOSED STORM SEWER PIPE
 - EA 01 PROPOSED STRUCTURE
 - WORK TO BE DONE BY OTHERS
 - ◊ INLET FILTERS
 - HANDHOLE

- NOTES:**
- SEE DRAINAGE SCHEDULES FOR ADDITIONAL STRUCTURE AND PIPE INFORMATION.
 - INLET FILTERS TO BE INSTALLED ON ALL PROPOSED DRAINAGE STRUCTURES.

CTE ENGINEERS
CONSOER TOWNSEND ENVIRONMENTAL ENGINEERS, INC.
303 EAST WACKER DRIVE, SUITE 600
CHICAGO, ILLINOIS 60601-5222, PHONE: (312) 938-0300

REVISIONS	
NAME	DATE

ILLINOIS DEPARTMENT OF TRANSPORTATION
F.A.I. 90/94 (DAN RYAN EXPRESSWAY)
51st ST (WENTWORTH AVE AND WELLS ST)

**DRAINAGE AND UTILITY PLANS
WENTWORTH AVENUE**

SCALE: 1"=20'
DATE: December 23, 2004
DRAWN BY: LC
CHECKED BY: JAL

12/21/2004 3:06:00 PM