


F.A.I. RTE.	SECTION	COUNTY	TOTAL SHEETS	SHEET NO.
90/94	2004-073RS	COOK	74	37
STA. 591+25		TO STA. 596+25		
FED. ROAD DIST. NO. 1 ILLINOIS FED. AID PROJECT				

62812

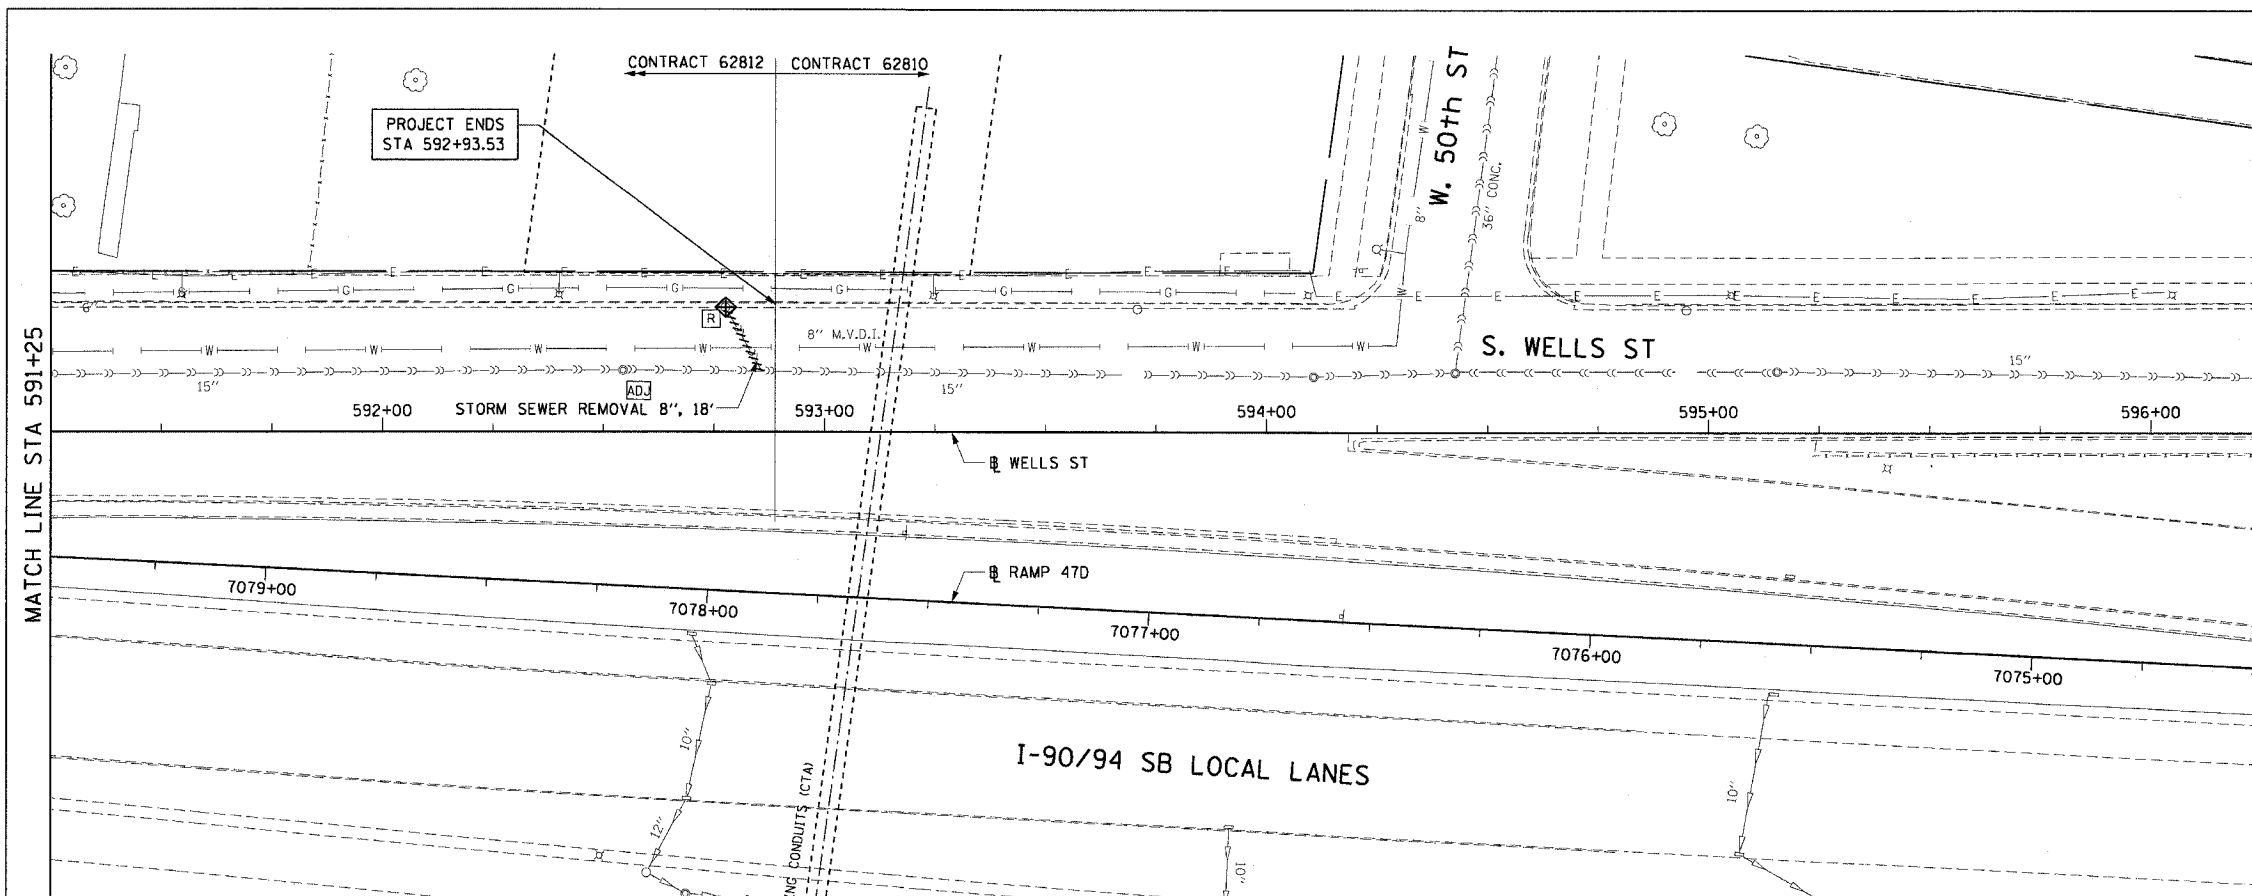

**LEGEND: EXISTING**

- INLET
- CATCH BASIN
- MANHOLE
- STORM SEWER
- COMBINED SEWER
- PIPE UNDERDRAIN
- [R] STRUCTURE TO BE REMOVED
- [AD] STRUCTURE TO BE ADJUSTED
- //// STORM SEWER REMOVAL
- //// COMBINED SEWER REMOVAL

NOTE:  
ALL EXISTING OPEN LID DRAINAGE STRUCTURES TO REMAIN THRU STAGE 2 OF CONTRACT 62586 SHALL HAVE INLET FILTERS INSTALLED.


**EXISTING CONDITIONS AND REMOVAL PROPOSED IMPROVEMENTS**

**LEGEND: PROPOSED**

- INLET
- CATCH BASIN
- MANHOLE
- STORM SEWER
- COMBINED SEWER
- PIPE UNDERDRAIN
- PROPOSED SWALE
- ⊕ INLET FILTERS
- HANDHOLE
- ⊙ PROPOSED STORM SEWER PIPE
- △ PROPOSED STRUCTURE
- WORK TO BE DONE BY OTHERS

**NOTES:**

1. SEE DRAINAGE SCHEDULES FOR ADDITIONAL STRUCTURE AND PIPE INFORMATION.
2. INLET FILTERS TO BE INSTALLED ON ALL PROPOSED DRAINAGE STRUCTURES

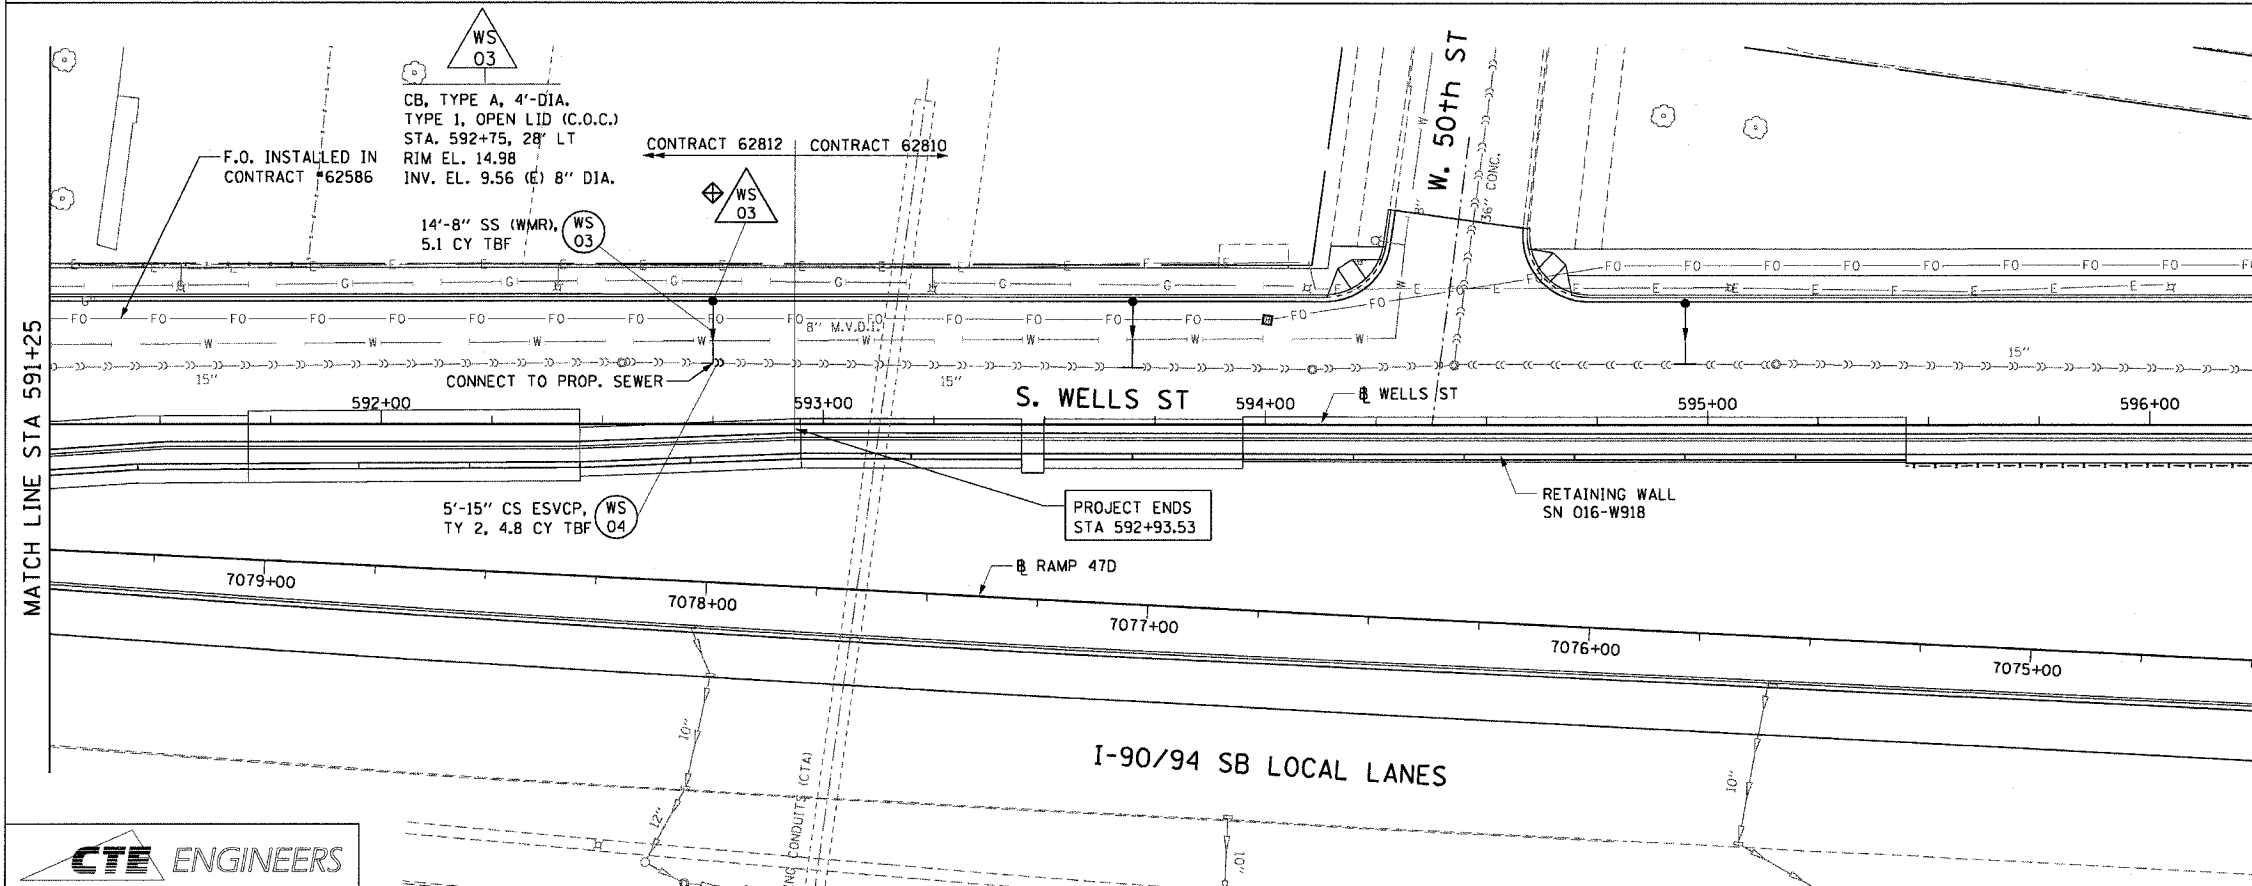

REVISIONS	
NAME	DATE

ILLINOIS DEPARTMENT OF TRANSPORTATION  
F.A.I. 90/94 (DAN RYAN EXPRESSWAY)  
51st ST (WENTWORTH AVE AND WELLS ST)  
**DRAINAGE AND UTILITY PLANS  
WELLS STREET**

SCALE: 1"=20'  
DATE: December 23, 2004  
DRAWN BY: LC  
CHECKED BY: JAL

**CTE ENGINEERS**  
CONSOER TOWNSEND ENVIRODYNE ENGINEERS, INC.  
303 EAST WACKER DRIVE, SUITE 600  
CHICAGO, ILLINOIS 60601-5202, PHONE: (312) 938-0300

12/23/2004 3:16:23 PM