 


F.A.I. RTE.	SECTION	COUNTY	TOTAL SHEETS	SHEET NO.
90/94	2004-074RS	COOK	63	31
STA. 531+75		TO STA. 536+75		
FED. ROAD DIST. NO. 1		ILLINOIS FED. AID PROJECT		


62813



LEGEND: EXISTING

- INLET
- CATCH BASIN
- MANHOLE
- STORM SEWER
- COMBINED SEWER
- PIPE UNDERDRAIN
- [R] STRUCTURE TO BE REMOVED
- [AD] STRUCTURE TO BE ADJUSTED
- //// STORM SEWER REMOVAL
- //// COMBINED SEWER REMOVAL

NOTE:
ALL EXISTING OPEN LID DRAINAGE STRUCTURES TO REMAIN THRU STAGE 2 OF CONTRACT 62586 SHALL HAVE INLET FILTERS INSTALLED.

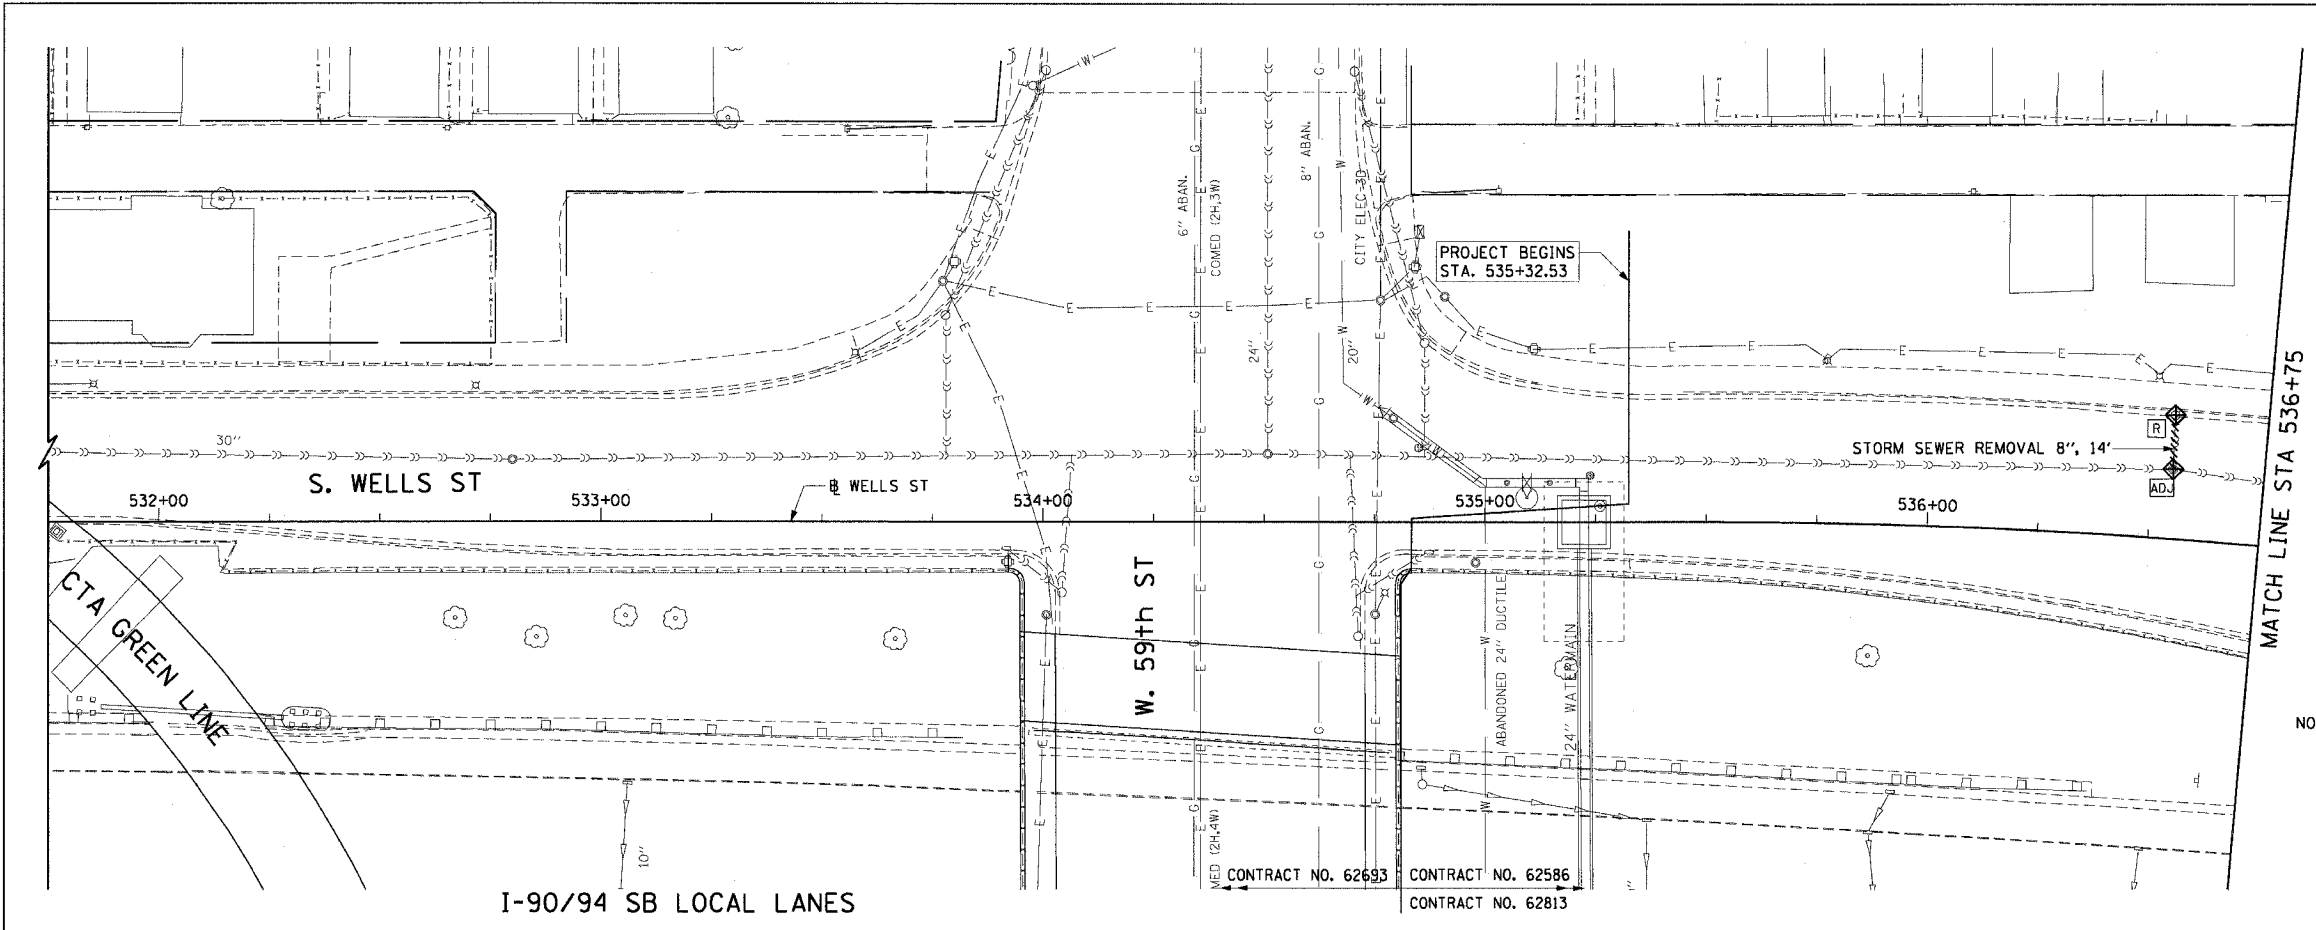


EXISTING CONDITIONS AND REMOVAL

PROPOSED IMPROVEMENTS

LEGEND: PROPOSED

- INLET
- CATCH BASIN
- MANHOLE
- STORM SEWER
- COMBINED SEWER
- PIPE UNDERDRAIN
- PROPOSED SWALE
- ⊕ INLET FILTER
- ⊙ (EA 01) PROPOSED STORM SEWER PIPE
- ⊙ (EA 01) PROPOSED STRUCTURE
- WORK TO BE DONE BY OTHERS

- NOTES:
- SEE DRAINAGE SCHEDULES FOR STRUCTURE AND PIPE INFORMATION.
 - INLET FILTERS TO BE INSTALLED ON ALL PROP. DRAINAGE STR.

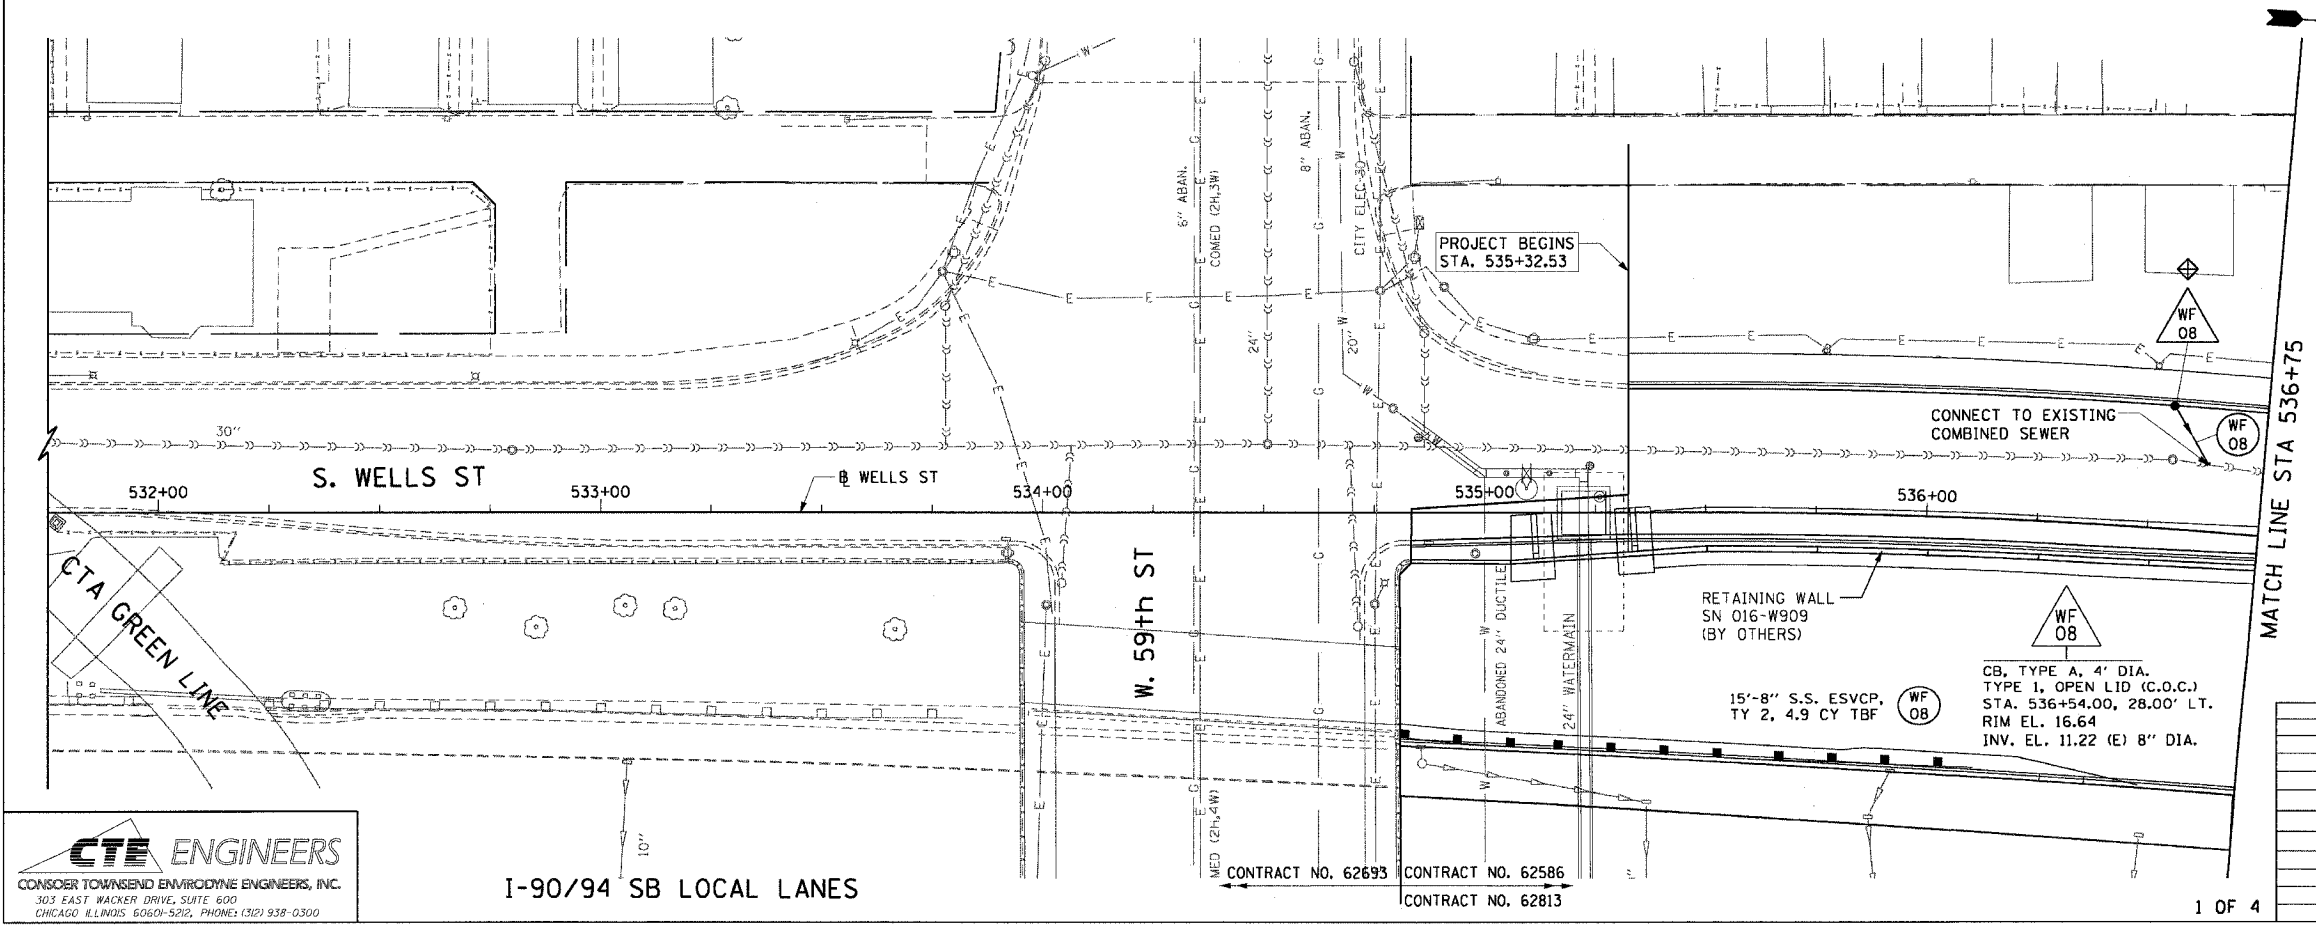

REVISIONS	
NAME	DATE

ILLINOIS DEPARTMENT OF TRANSPORTATION
F.A.I. 90/94 (DAN RYAN EXPRESSWAY)
59th ST TO 57th ST (WELLS STREET)

**DRAINAGE AND UTILITY PLANS
WELLS STREET**

SCALE: 1"=20'
DATE: December 17, 2004

DRAWN BY: PHP
CHECKED BY: JB

CTE ENGINEERS
CONSIDER TOWNSEND ENVIRONMENTAL ENGINEERS, INC.
303 EAST WACKER DRIVE, SUITE 600
CHICAGO, ILLINOIS 60601-5212, PHONE: (312) 938-0300

I-90/94 SB LOCAL LANES

CONTRACT NO. 62693 CONTRACT NO. 62586
CONTRACT NO. 62813

12/14/2004 4:57:41 PM