


F.A.I. RTE.	SECTION	COUNTY	TOTAL SHEETS	SHEET NO.
90/94	2004-074RS	COOK	63	33
STA. 541+50		TO STA. 546+00		
FED. ROAD DIST. NO. 1 ILLINOIS FED. AID PROJECT				

62813

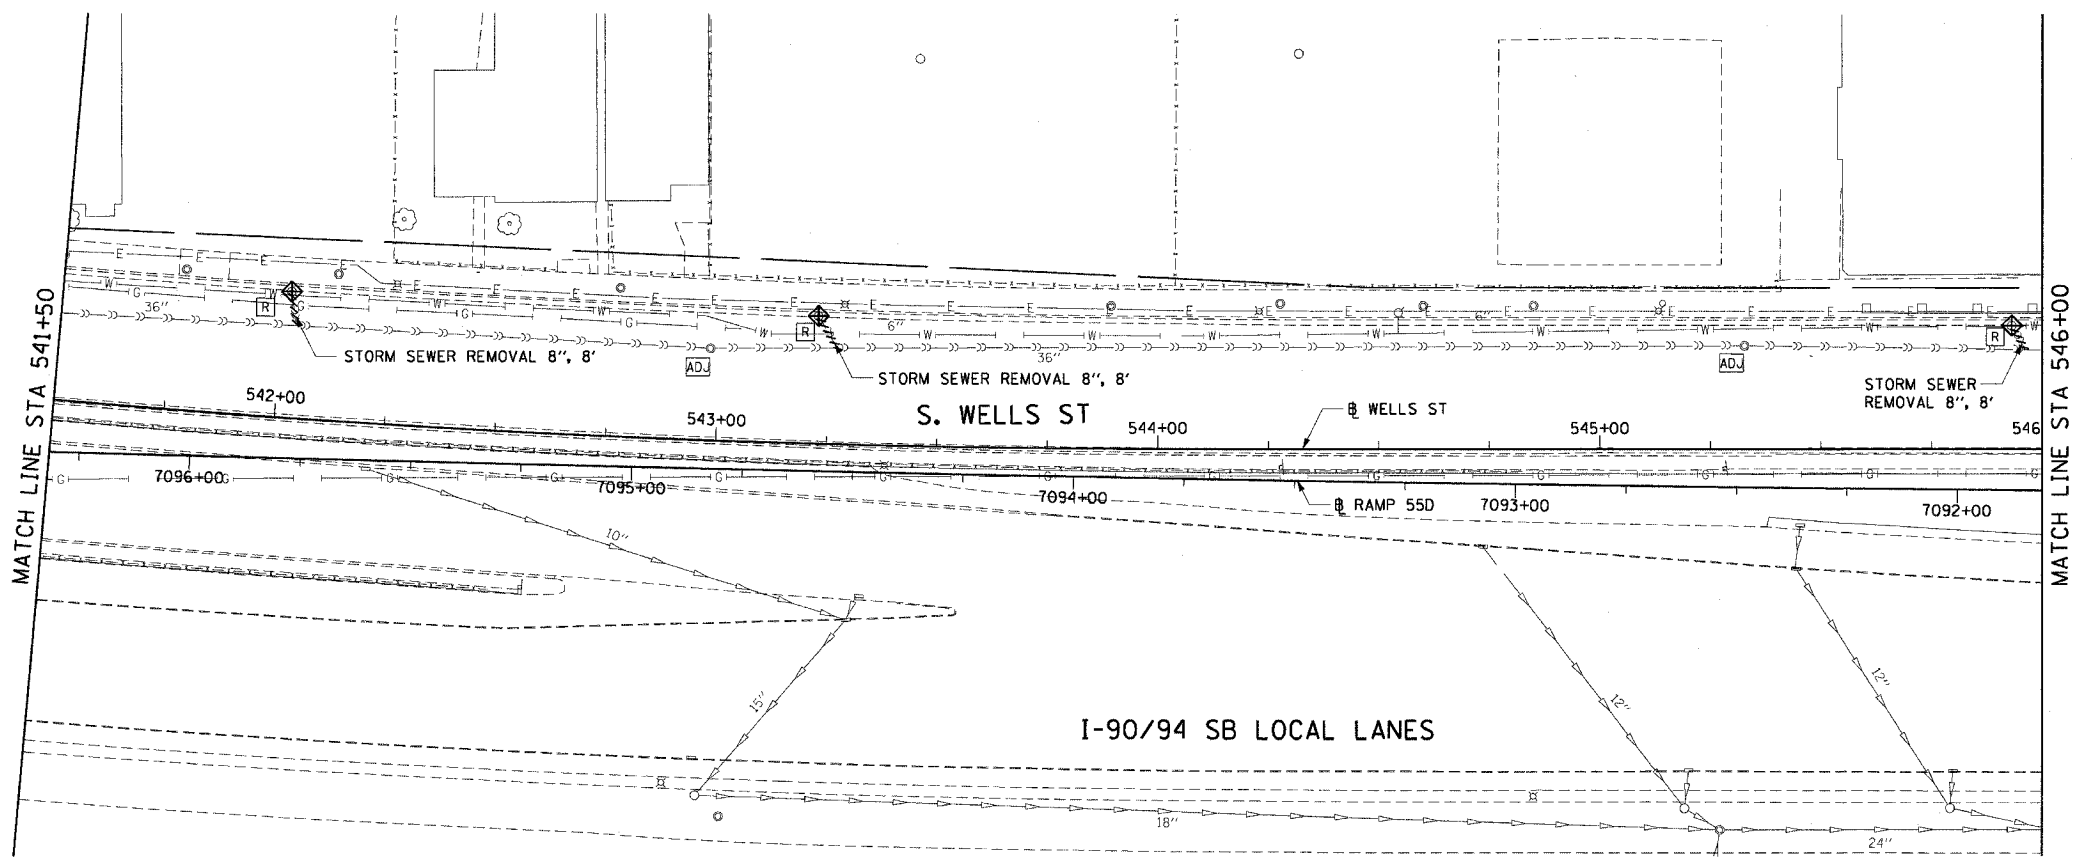


- LEGEND: EXISTING**
- INLET
 - CATCH BASIN
 - MANHOLE
 - STORM SEWER
 - COMBINED SEWER
 - PIPE UNDERDRAIN
 - [R] STRUCTURE TO BE REMOVED
 - [AD] STRUCTURE TO BE ADJUSTED
 - //// STORM SEWER REMOVAL
 - //// COMBINED SEWER REMOVAL

NOTE:
ALL EXISTING OPEN LID DRAINAGE STRUCTURES TO REMAIN THRU STAGE 2 OF CONTRACT 62586 SHALL HAVE INLET FILTERS INSTALLED.

EXISTING CONDITIONS AND REMOVAL

PROPOSED IMPROVEMENTS

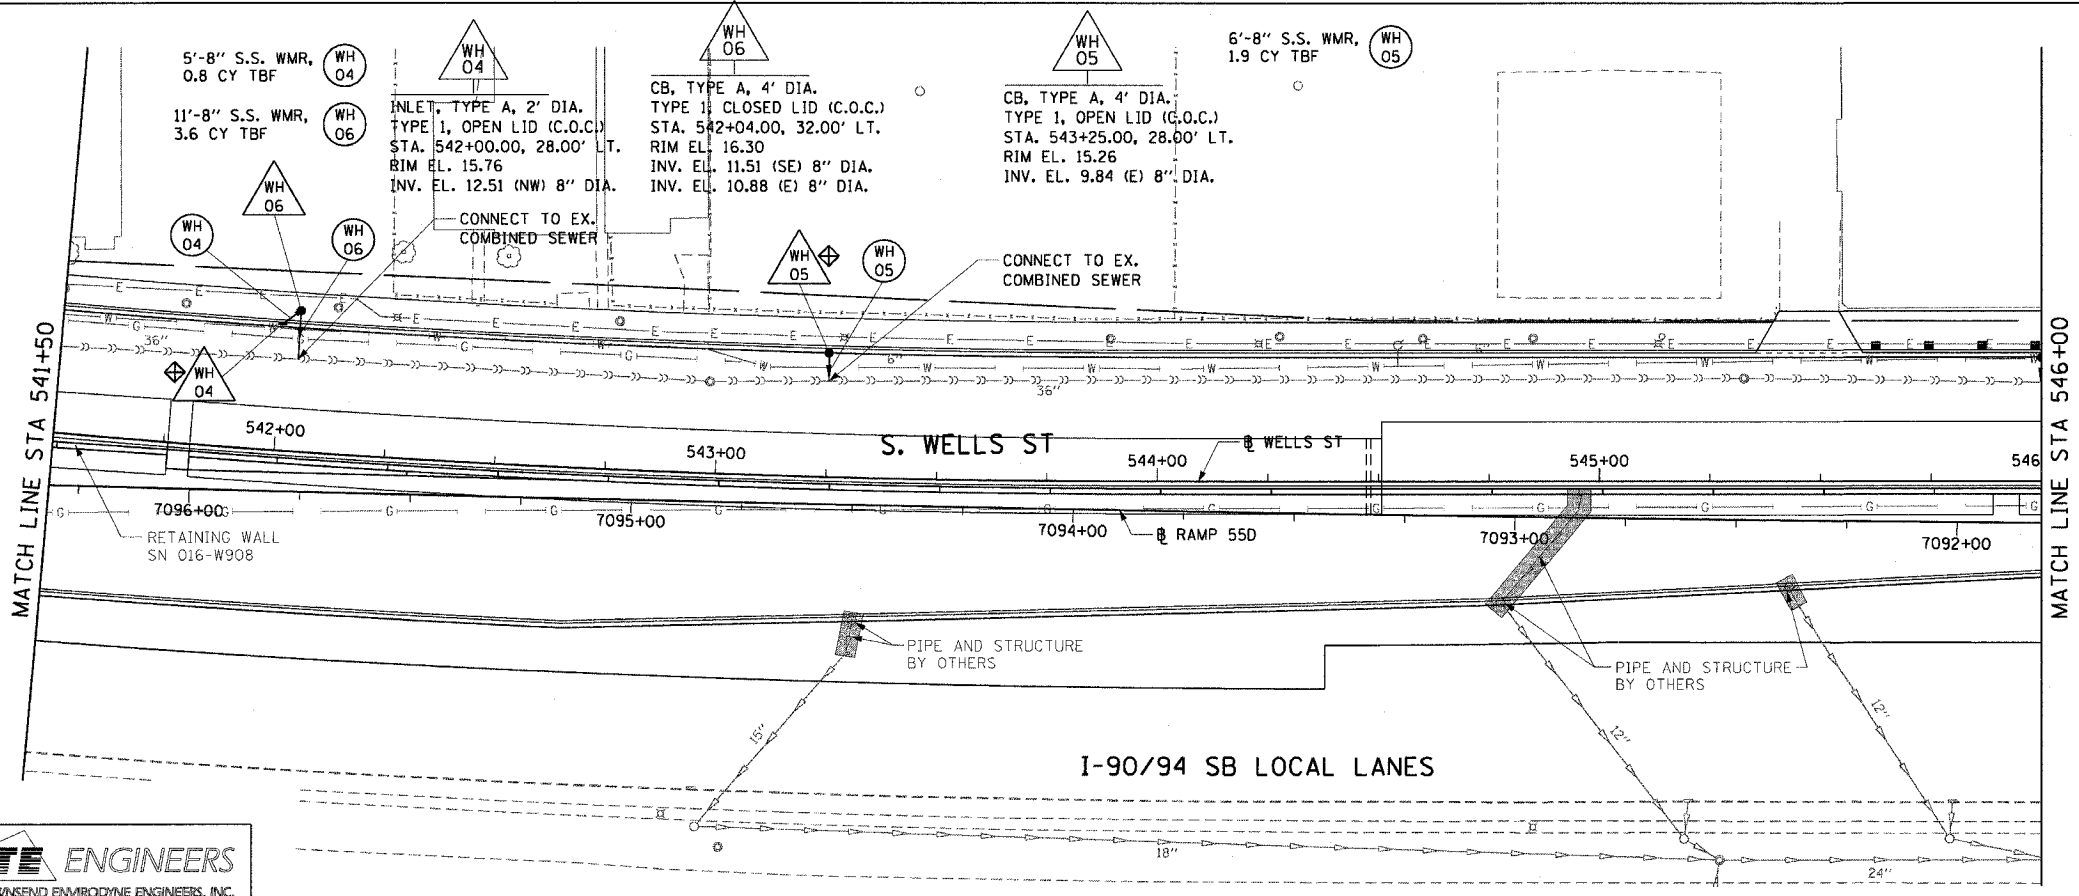

- LEGEND: PROPOSED**
- INLET
 - CATCH BASIN
 - MANHOLE
 - STORM SEWER
 - COMBINED SEWER
 - PIPE UNDERDRAIN
 - PROPOSED SWALE
 - ⊕ INLET FILTER
 - ⊙ (EA 01) PROPOSED STORM SEWER PIPE
 - △ (EA 01) PROPOSED STRUCTURE
 - WORK TO BE DONE BY OTHERS

- NOTES:**
1. SEE DRAINAGE SCHEDULES FOR STRUCTURE, PIPE AND UNDERDRAIN INFORMATION.
 2. SEE ELECTRICAL DRAWINGS FOR PROPOSED CITY ELECTRIC LINE (6-DUCT).
 3. SEE TRAFFIC SIGNAL AND INTERCONNECT PLANS FOR PROPOSED TRAFFIC SIGNAL CONDUITS AND FIBER OPTIC LINES.
 4. INLET FILTERS TO BE INSTALLED ON ALL PROP. DRAINAGE STR.

REVISIONS	
NAME	DATE

ILLINOIS DEPARTMENT OF TRANSPORTATION
F.A.I. 90/94 (DAN RYAN EXPRESSWAY)
59th ST TO 57th ST (WELLS STREET)

**DRAINAGE AND UTILITY PLANS
WELLS STREET**

SCALE: 1"=20'
DATE: December 17, 2004
DRAWN BY: PHP
CHECKED BY: JB

CTE ENGINEERS
CONSOER TOWNSEND ENVIRONMENTAL ENGINEERS, INC.
305 EAST WACKER DRIVE, SUITE 600
CHICAGO, ILLINOIS 60601-5212, PHONE: (312) 938-0300

m:\p\0668\N\4-Ctr\9-Add-Ctr\9\915\DWG\Drainage\00915\032A.DWG 12/17/2004 4:55:05 PM