


STRUCTURE SCHEDULE

ID	PAY ITEM	STA	OFF	ELEV	N INV	S INV	E INV	W INV
C131	CB TC T24F&G	744+25.0	-27.24	658.45			654.00	
C132	CB TA 4 DIA T24F&G	744+40.0	27.54	658.44			653.70	653.70
C133	CB TA 4 DIA T24F&G	745+40.0	-29.54	659.00	653.71		653.50	
C134	CB TA 4 DIA T24F&G	745+40.0	29.54	659.00			653.00	653.21
C135	EX MAN	745+50.0	34.50	659.67	EX INV	EX INV		652.95
C136	CB TA 4 DIA T24F&G	746+40.0	-31.54	659.50	654.41	654.21	654.69	
C137	CB TA 4 DIA T24F&G	746+40.0	31.54	659.50				655.00
C138	CB TA 4 DIA T24F&G	747+35.0	-33.44	659.97		654.89	655.17	
C139	CB TC T24F&G	747+35.0	33.44	659.97				655.50
C140	CB TC T24F&G	752+75.0	-34.00	663.36			659.00	


STRUCTURE SCHEDULE

ID	PAY ITEM	STA	OFF	ELEV	N INV	S INV	E INV	W INV
C141	CB TC T8G	752+75.0	5.25	663.71			658.60	658.80
C142	CB TA 4 DIA T24F&G	752+75.0	34.00	663.36			658.25	658.46
C143	MAN TA 5 DIA T5F CL	752+75.0	42.28	663.71	652.05	652.05		658.21
C144	CB TA 5 DIA T24F&G	754+00.0	-34.00	664.18	EX INV		652.70	
C145	CB TA 5 DIA T24F&G	754+00.0	34.00	664.12	EX INV		652.36	652.36

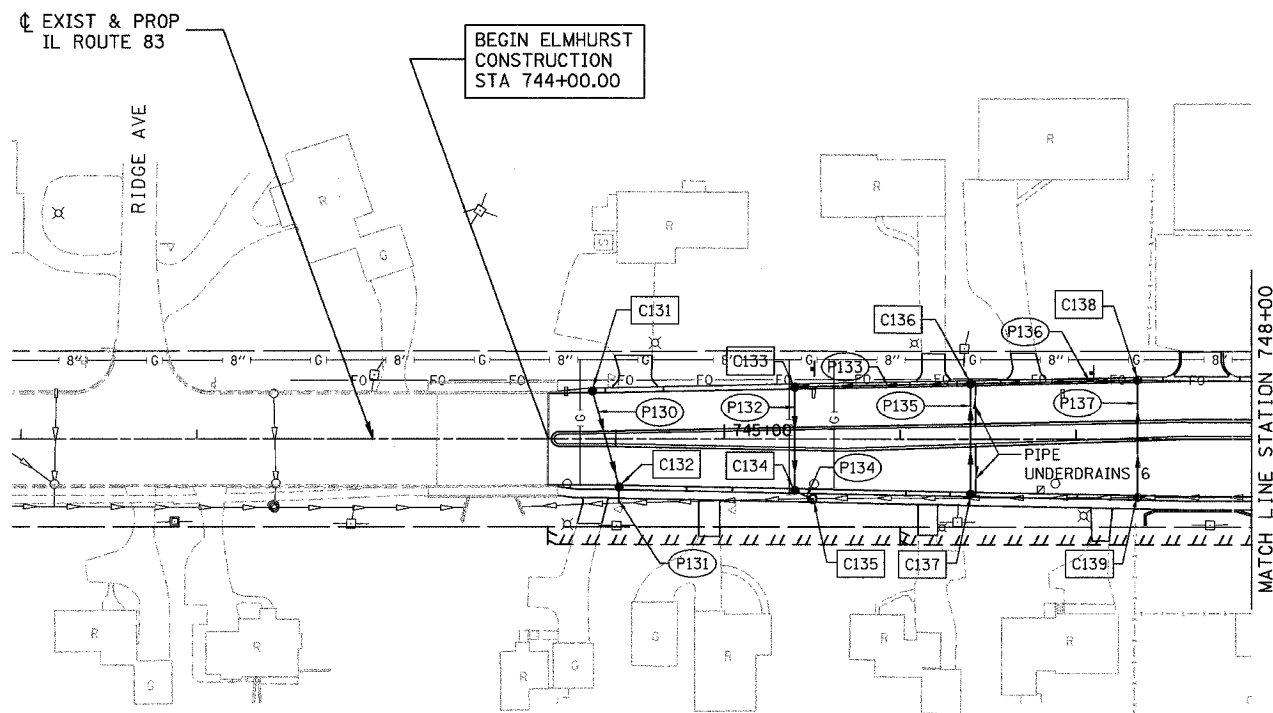

PIPE SCHEDULE

ID	T	DIA	L	S Z	TBF
P130	1	12"	52.8'	0.53	12.1
P131	1	12"	7.4'		2.1
P132	1	15"	55.1'	0.50	19.4
P133	1	15"	96.0'	0.50	29.9
P134	1	15"	7.2'	0.49	3.1
P135	1	12"	59.1'	0.50	13.9
P136	1	12"	91.0'	0.50	25.5
P137	1	12"	62.9'	0.49	14.7
P138	1	12"	35.3'	0.50	8.2
P139	1	12"	24.8'	0.50	6.7

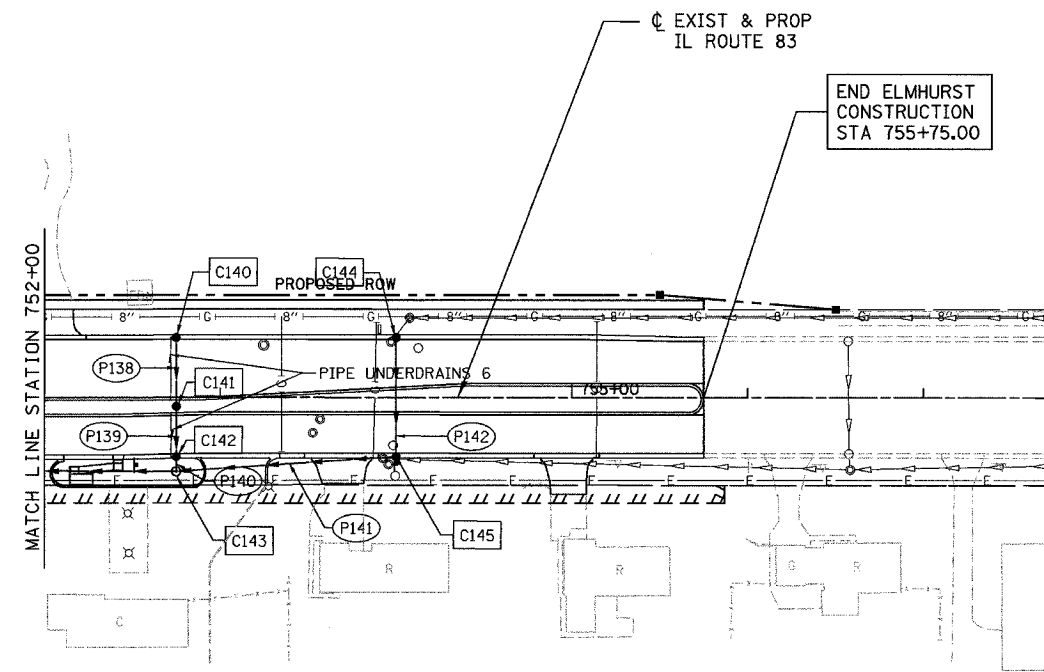

PIPE SCHEDULE

ID	T	DIA	L	S Z	TBF
P140	1	12"	4.3'	0.50	1.3
P141	2	36"	120.3'	0.25	235.3
P142	2	36"	63.0'	0.50	121.8

• STORM SEWER WATERMAIN REQUIREMENT

ILLINOIS DEPARTMENT OF TRANSPORTATION  
PALATINE ROAD OVER IL 83 (ELMHURST RD.)

**ELMHURST ROAD  
PROPOSED DRAINAGE  
AND UTILITY PLAN**

SCALE: 1"=50'  
DATE 12/04

DRAWN BY ACE/CAD  
CHECKED BY TAE



REVISIONS	
NAME	DATE

12/27/2004 03:54:33 PM