


SECTION	COUNTY	TOTAL SHEETS	SHEET NO.
F.A. 140CS-TS-3	WINNEBAGO	28	1
F.H.W.A. REG.	ILLINOIS	PROJECT:	

**STATE OF ILLINOIS
DEPARTMENT OF TRANSPORTATION
DIVISION OF HIGHWAYS**

**FAP ROUTE 303 (US BUSINESS ROUTE 20)
WINNEBAGO COUNTY
SECTION (140CS)TS-3
PROJECT No. HS-0303 (031)
STATE JOB No. C-92-129-04
CONTRACT No. 64A38**

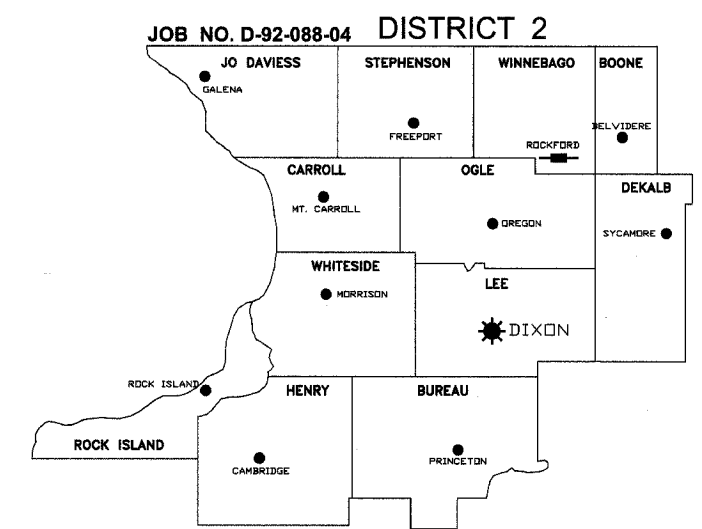

★ DISTRICT HEADQUARTERS
■ PROJECT LOCATION

INDEX OF SHEETS

SHEET NO.	TITLE
1	COVER SHEET
2	SUMMARY OF QUANTITIES
3-4	TYPICAL SECTIONS
5	GENERAL NOTES
6-7	SCHEDULE OF QUANTITIES
8	SOUTH SECOND STREET PLAN & PROFILE
9	SOUTH SECOND STREET UTILITY PLAN & PROFILE
10	SOUTH THIRD STREET PARKING
11	IL 251/BUS 20/WALNUT STREET PLAN & PROFILE
12-13	KISHWAUKEE AVENUE PLAN & PROFILE
14	PAVEMENT ELEVATION DETAILS
15	SOUTH SECOND STREET & WALNUT STREET TEMPORARY SIGNAL PLAN
16	SOUTH SECOND STREET & WALNUT STREET SIGNAL PLAN
17	SOUTH SECOND STREET & WALNUT STREET SIGNAL PLAN DETAILS
18	SOUTH THIRD STREET & WALNUT STREET SIGNAL PLAN
19	STANDARD DETAILS
20	CITY OF ROCKFORD STANDARD DETAILS
21	CITY OF ROCKFORD WATER DETAILS
22	ROCKRIVER WATER RECLAMATION DISTRICT STANDARD DETAILS
23-24	DISTRICT 2 STANDARDS
25-28	CROSS-SECTIONS

STATE STANDARDS

280001-02	TEMPORARY EROSION CONTROL SYSTEM
420001-05	PAVEMENT JOINTS
424001-03	CURB RAMPS FOR SIDEWALKS
602401	MANHOLE, TYPE A
602601	PRECAST REINFORCED CONCRETE FLAT SLAB TOP
602701	CAST IRON STEPS
604001-02	FRAME AND LIDS, TYPE 1
606001-02	CONCRETE CURB TYPE B AND COMBINATION CONCRETE CURB AND GUTTER
606301-02	PC CONCRETE ISLANDS AND MEDIANS
606306-01	CORRUGATED PC CONCRETE MEDIANS
667101	PERMANENT SURVEY MARKERS
701501-03	LANE CLOSURE, 2L 2W, DAY OR NIGHT OPERATIONS, FOR SPEEDS < 45 MPH
701601-04	URBAN LANE CLOSURE MULTILANE 1W OR 2W WITH NONTRAVERSABLE MEDIAN
701606-04	LANE CLOSURE, MULTILANE, 2W, WITH MOUNTABLE MEDIAN, FOR SPEEDS < 45 MPH
701701-04	LANE CLOSURE, MULTILANE, INTERSECTION, FOR SPEEDS < 45 MPH
701801-03	LANE CLOSURE, MULTILANE, 1W OR 2W, CROSSWALK OR SIDEWALK CLOSURE, FOR SPEEDS < 45 MPH
702001-05	TRAFFIC CONTROL DEVICES
720001	SIGN PANEL MOUNTING DETAILS
720006	SIGN PANEL ERECTION DETAILS
720011	METAL POSTS (SIGNS, MARKERS AND DELINEATORS)
720016-01	MAST ARM MOUNTED STREET NAME SIGNS
729001	APPLICATION OF TYPE A AND B METAL POSTS
780001-01	TYPICAL PAVEMENT MARKINGS
805001	ELECTRICAL SERVICE INSTALLATION DETAILS
814001	CONCRETE HANDHOLES
857001	STANDARD PHASE DESIGNATION DIAGRAMS AND PHASE SEQUENCES
877011-02	STEEL COMBINATION MAST ARM ASSEMBLY AND POLE
878001-03	CONCRETE FOUNDATION DETAILS
880001	SPAN WIRE MOUNTED SIGNALS AND FLASHING BEACON INSTALLATION
880006	TRAFFIC SIGNAL MOUNTING DETAILS
886001	DETECTOR LOOP INSTALLATIONS
886006	TYPICAL LAYOUT FOR DETECTION LOOPS
**4.1	PC CONCRETE ISLANDS AND MEDIANS ACCESSIBLE TO THE DISABLED

** DISTRICT 2 STANDARD INCLUDED IN PLANS ON PAGE 23

SCALES:


PLAN & PROFILE:	1"=20' HORIZONTAL - 1"=5' VERTICAL
CROSS SECTIONS:	1"=10' HORIZONTAL - 1"=5' VERTICAL

COMMITMENTS

ALL TREES REMOVED FROM THE PROJECT AREA FOR CONSTRUCTION WILL BE REPLACED WITH DECIDUOUS TREE SPECIES WHICH ARE NATIVE TO THE DISTRICT 2 AREA. TREES WILL BE REPLACED ACCORDING TO IDOT DEPARTMENTAL POLICY. THE LOCATION OF THE REPLACEMENT TREES SHALL BE DETERMINED BY THE CITY OF ROCKFORD, THE ENGINEER, OR AS INDICATED ON THE PLAN SHEETS.

DESIGN DESIGNATION

1560(24) - ARTERIAL-1.3(B-20)

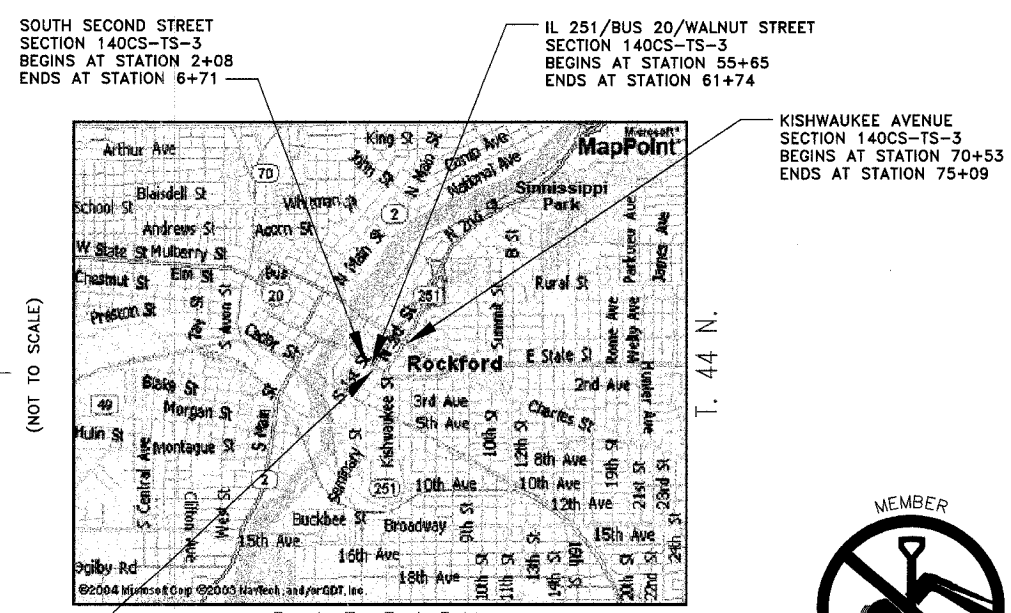

R. 1 E. 3rd P.M.
ROCKFORD TOWNSHIP, SECTION 26
WINNEBAGO COUNTY

SOUTH SECOND STREET = 421 FEET = 0.080 MILES
SOUTH THIRD STREET = 176 FEET = 0.033 MILES
IL 251/BUS 20/WALNUT STREET = 609 FEET = 0.115 MILES
KISHWAUKEE AVENUE = 456 FEET = 0.086 MILES
TOTAL PROJECT LENGTH = 1662 FEET = 0.314 MILES



CALL J.U.L.I.E. BEFORE YOU DIG
1-800-892-0123
TOLL FREE

STATE OF ILLINOIS
DEPARTMENT OF TRANSPORTATION
DIVISION OF HIGHWAYS

SUBMITTED Dec 17 2004
Gregory L. North
DEPUTY DIRECTOR OF HIGHWAYS, REGION ENGINEER

February 4, 2005
Bradley S. Lange
ENGINEER OF DESIGN AND ENVIRONMENT

February 4, 2005
Victor Maden
DIRECTOR OF HIGHWAYS, CHIEF ENGINEER

McCLURE ENGINEERING ASSOCIATES, INC.
7282 Argus Drive Rockford, Illinois 61107
(815) 398-2332 FAX (815) 398-2496
Design Firm License: Illinois #184-000816



Bradley S. Lange 12/1/2004 DATE
BRADLEY S. LANGE
ILLINOIS REGISTERED PROFESSIONAL ENGINEER
NO. 062-055472
EXPIRES 11-30-2005

"PRINTED BY THE AUTHORITY OF THE STATE OF ILLINOIS"

SENIOR SQUAD LEADER: REBECCA MARRUFFO (815) 284-5902
PROJECT ENGINEER: BRADLEY S. LANGE (815) 398-2332
CONSULTANT: McCLURE ENGINEERING ASSOCIATES, INC.

CONTRACT No. 64A38