
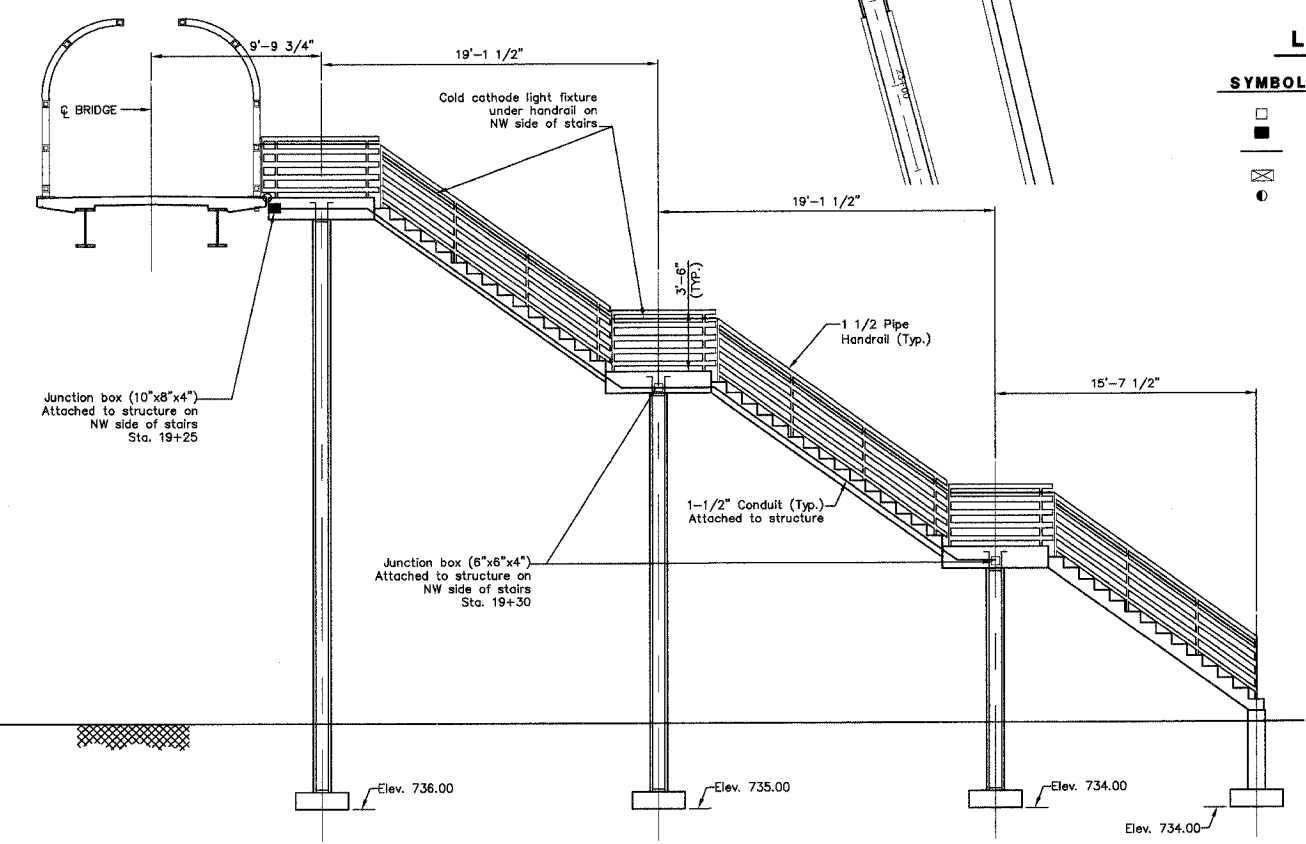
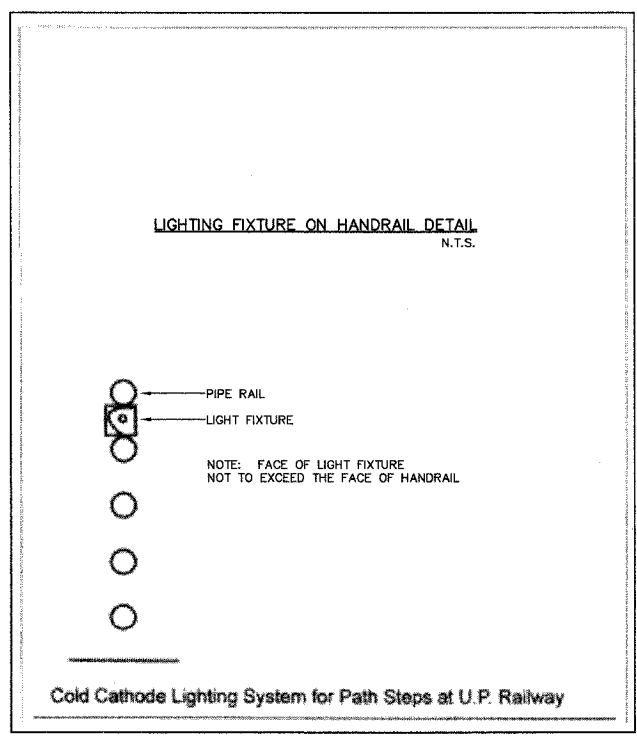


BRIDGE CROSS SECTION

 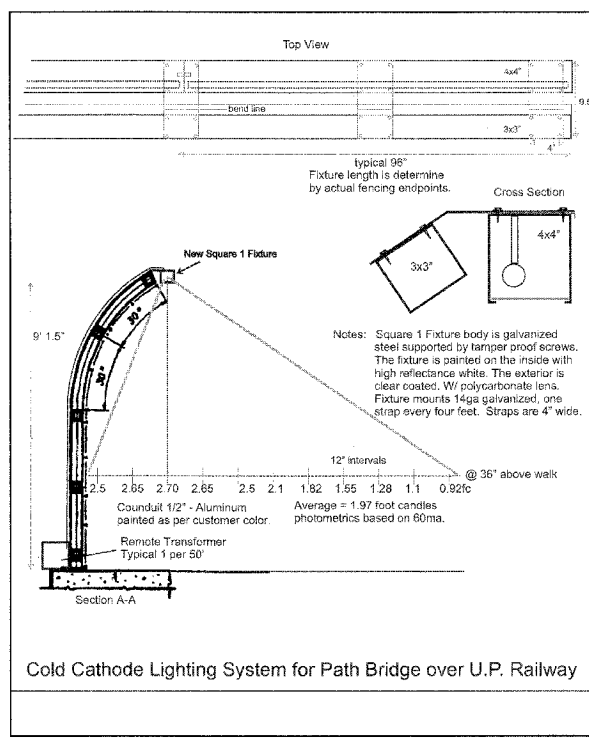


ELEVATION

LEGEND

SYMBOL	DESCRIPTION
□	JUNCTION BOX 6"x6"x4"
■	JUNCTION BOX 10"x8"x4"
—	1-1/2" CONDUIT
⊠	LIGHTING CONTROL CABINET
○	COMMONWEALTH EDISON SERVICE DROP

PREPARED FOR:
WHEATON PARK DISTRICT
 666 S. MAIN STREET
 WHEATON, ILLINOIS 60187



PREPARED BY:
CEMCON, Ltd.
 Consulting Engineers, Land Surveyors & Planners
 2280 White Oak Circle, Suite 100
 Aurora, Illinois 60504-9675
 Ph: 630.862.2100 Fax: 630.862.2199
 E-Mail: cadd@cemcon.com Website: www.cemcon.com

REVISIONS		REVISIONS			
NO.	DATE	DESCRIPTION	NO.	DATE	DESCRIPTION

LIGHTING LAYOUT PLAN – BICYCLE PATH BRIDGE			
PEDESTRIAN/BICYCLE PATH BRIDGE OVER UNION PACIFIC RAILROAD			
FILE NAME: OVR LIGHT	DSGN. BY: MMH	JOB NO.: 551.007	FLD. BK./PG.: -----
DISC. NUMBER: 551007	DRN. BY: DRA	DATE: 04-26-04	SCALE: 1" = 50'
SHEET NO. 53B of 54			

TAB: OVR LIGHT
 XREF: OVR_50.DWG
 Copyright © 2003 Cemcon, Ltd. All rights reserved.