


F.A.U. RITE	SECTION	COUNTY	TOTAL SHEETS	SHEET NO.
2585	00-00068-01-WR	COOK	145	101
STA.	TO STA.			
FED. ROAD DIST. NO.	ILLINOIS	FED. AID PROJECT		


CONTRACT NO. 83785

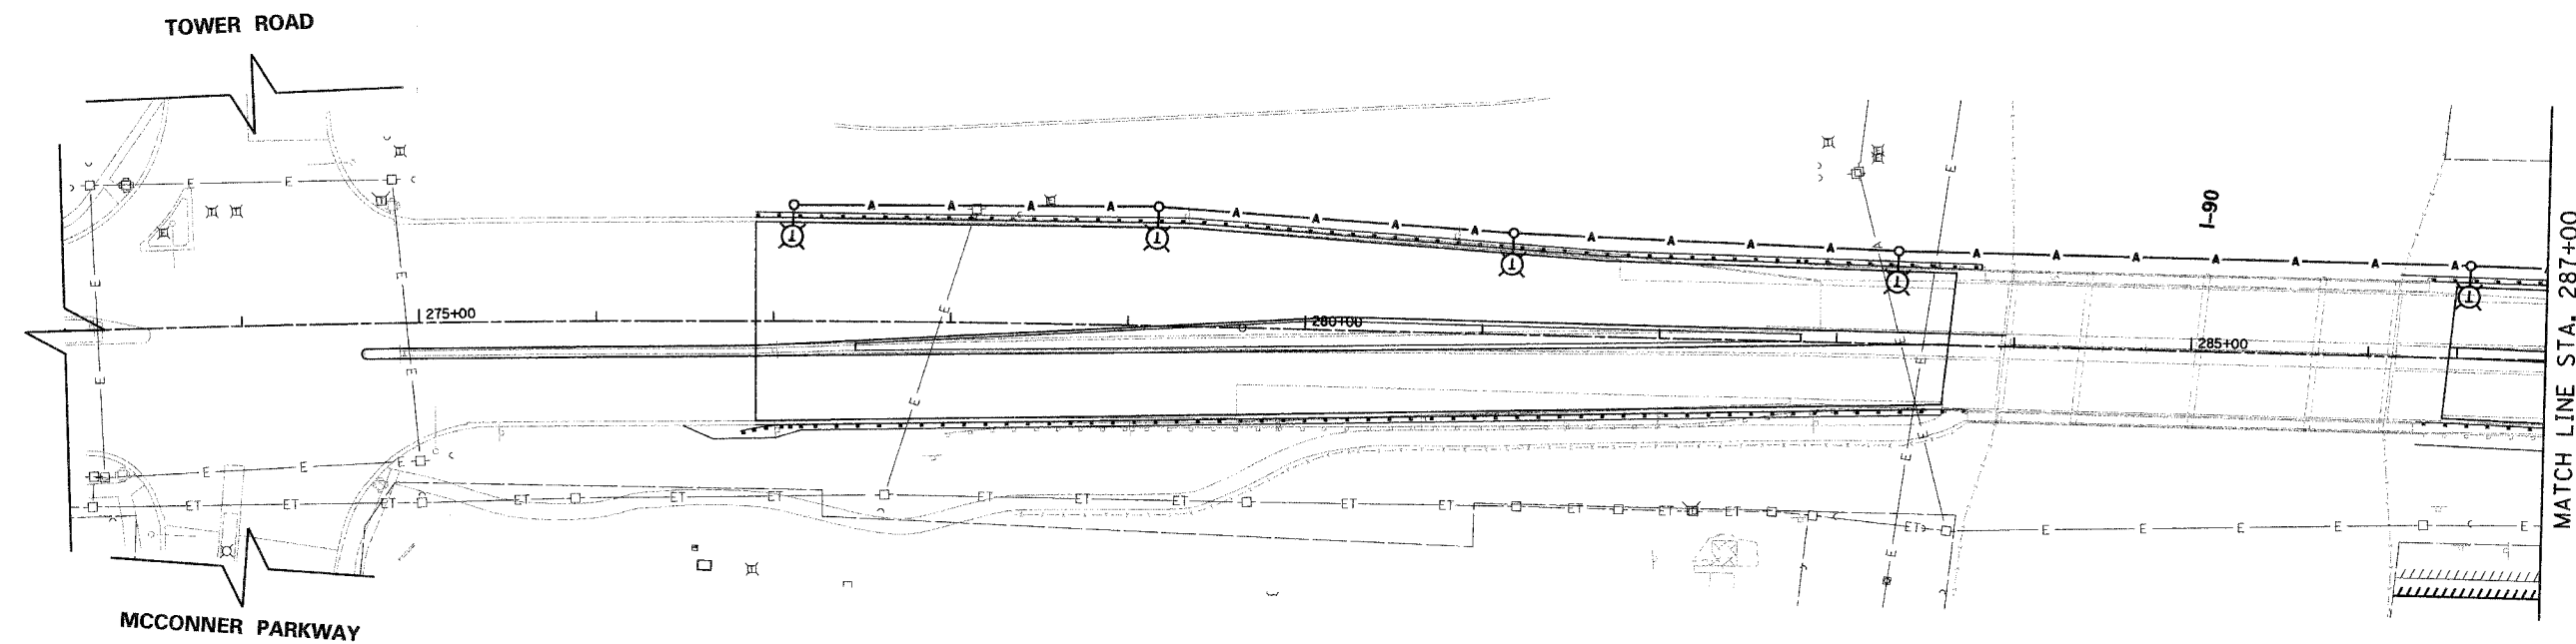

LEGEND

- TEMPORARY WOOD POLE WITH 10' MAST ARM AND 400 WATT LUMINAIRE MOUNTED AT 45'
- TEMPORARY WOOD POLE WITH 10' MAST ARM AND 400 WATT LUMINAIRE MOUNTED AT 45' (POLE SHARED WITH TRAFFIC SIGNALS)
- TEMPORARY LIGHTING CONTROLLER, PHOTOCELL OPERATED
- AERIAL CABLE, 3-1/2 No. 4 WITH MESSENGER WIRE


MEACHAM ROAD

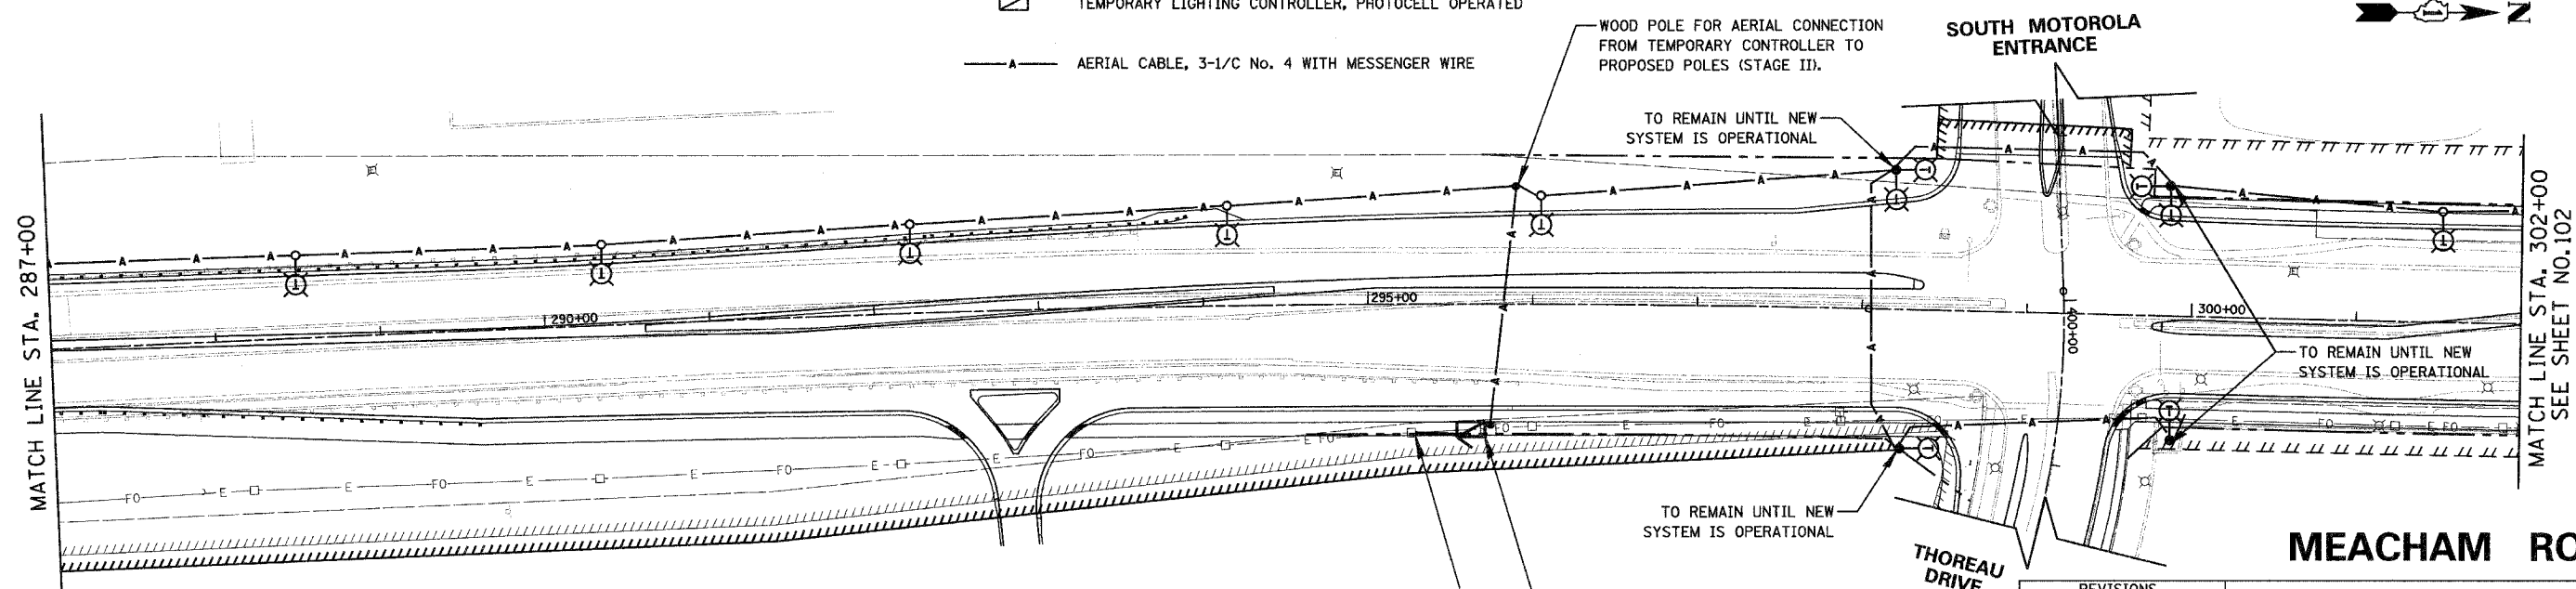

MEACHAM ROAD

REVISIONS	
NAME	DATE

 ILLINOIS DEPARTMENT OF TRANSPORTATION
 VILLAGE OF SCHAUMBURG
MEACHAM ROAD
 LIGHTING IMPROVEMENTS
 TEMPORARY LIGHTING PLAN
 STA. 273+00 TO STA. 302+00
 SCALE: 1"=50'
 DATE: DECEMBER 2004
 DRAWN BY: KDM
 CHECKED BY: JMV



n:\proj\3266\design\lighting\3266-temp\lighting01.dgn