
 
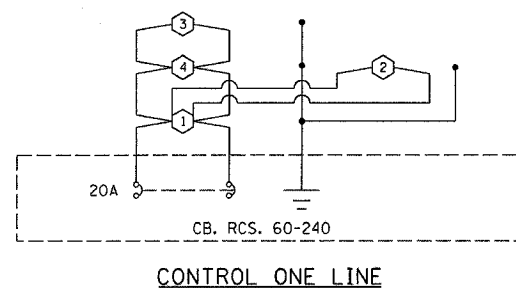


F.A.P. RTE.	SECTION	COUNTY	TOTAL SHEETS	SHEET NO.
774		EFFINGHAM	344	113
FED. ROAD DIST. NO. 7 ILLINOIS FED. AID PROJECT				
*107WRS-1, 107BY, 107BY-1 & 107B-2				
CONTRACT NO. 94827				



LEGEND:

- CONDUIT w/GROUND
- CONTROLLER
- LIGHT UNIT-1
- SERVICE POLE

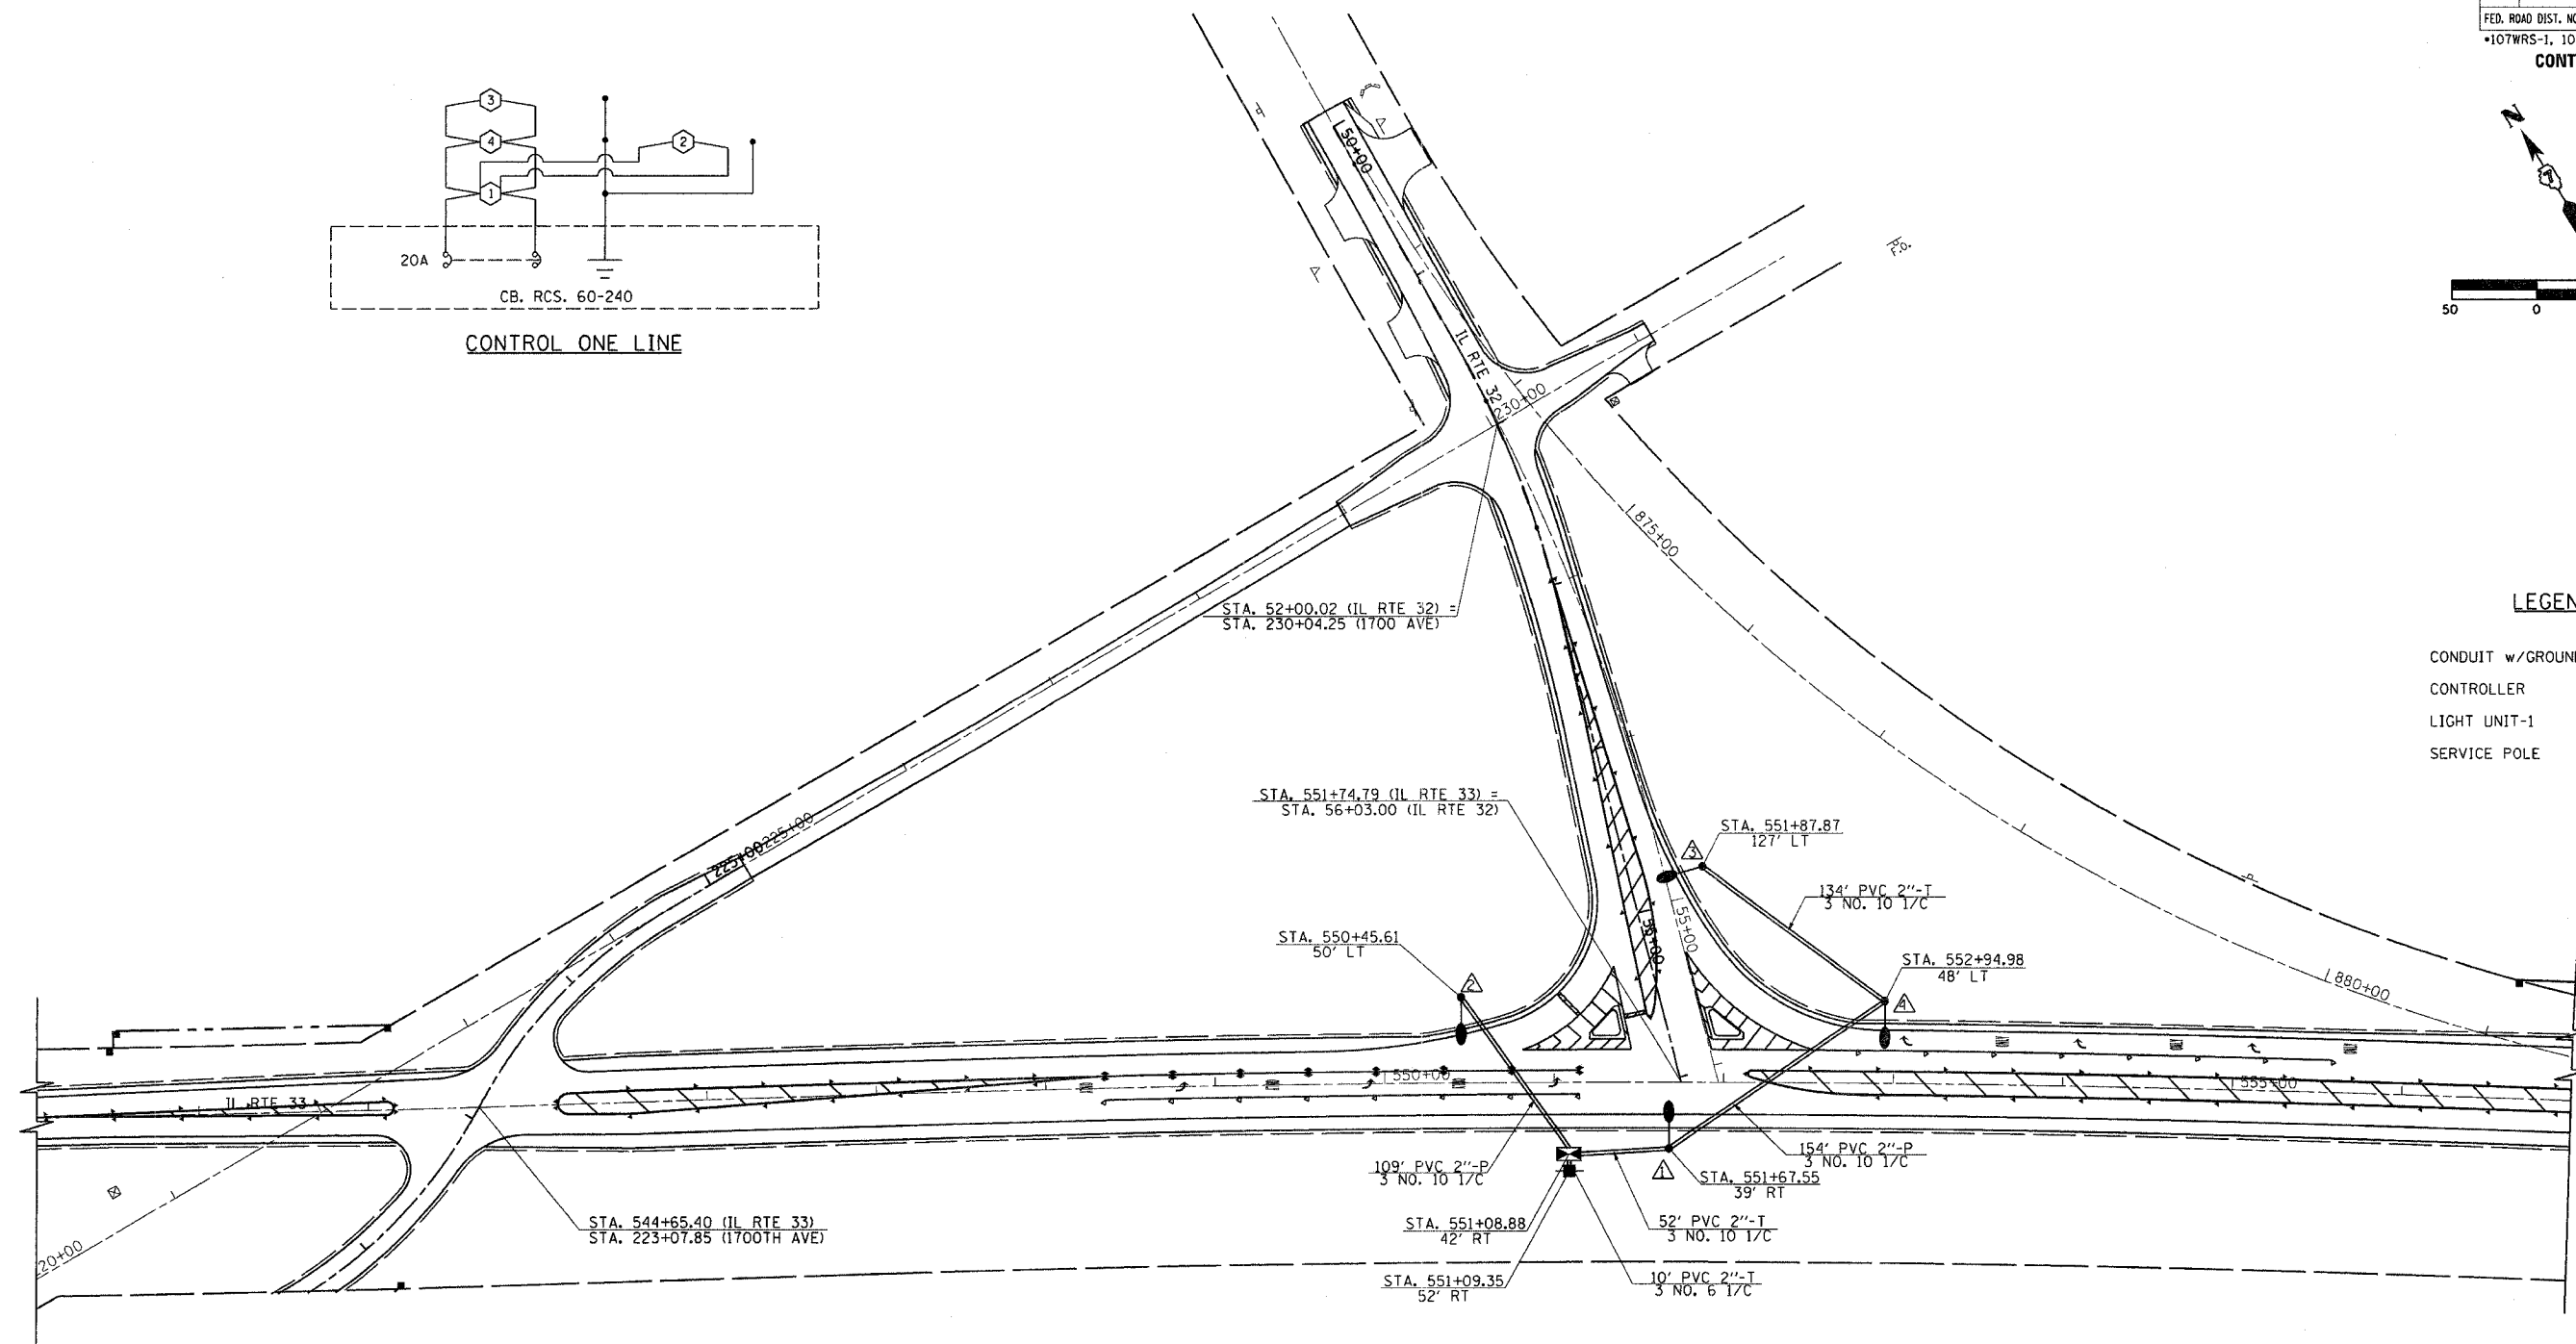

LIGHT/CABLE LAYOUT

REVISIONS	
NAME	DATE

ILLINOIS DEPARTMENT OF TRANSPORTATION

IL RTE 32/33 WYE
LIGHTING PLANS
SHEET 1 OF 8

DATE 8/02
DRAWN BY ASB
CHECKED BY BWD