

**WIND CONE NOTES**

THE PROPOSED WIND CONES SHALL BE INSTALLED AS SHOWN ON SHEETS 13 & 14, AND IN ACCORDANCE WITH THE SPECIAL PROVISIONS.


THE PROPOSED POWER CABLES TO EACH WIND CONE AND THE RESPECTIVE SPLICE CAN WILL BE PAID FOR UNDER ITEM:  
AS108658 3/C #8, 600V UG CABLE IN UD PER L.F.

THE LOCATION, SIZE AND TYPE OF MATERIAL OF EXISTING UNDERGROUND UTILITIES INDICATED ON THE PLANS IS NOT REPRESENTED AS BEING ACCURATE, SUFFICIENT OR COMPLETE. IT SHALL BE THE CONTRACTOR'S RESPONSIBILITY TO DETERMINE THE ACTUAL LOCATION OF ALL SUCH FACILITIES, INCLUDING SERVICE CONNECTIONS TO UNDERGROUND UTILITIES. PRIOR TO CONSTRUCTION, THE CONTRACTOR SHALL NOTIFY THE UTILITY COMPANIES OF HIS OPERATIONAL PLANS AND SHALL OBTAIN FROM THE RESPECTIVE UTILITY COMPANIES DETAILED INFORMATION AND ASSISTANCE RELATIVE TO THE LOCATION OF THEIR FACILITIES AND THE WORKING SCHEDULE OF THE COMPANIES FOR REMOVAL OR ADJUSTMENT WHERE REQUIRED. IN THE EVENT AN UNEXPECTED UTILITY INTERFERENCE IS ENCOUNTERED DURING CONSTRUCTION, THE CONTRACTOR SHALL IMMEDIATELY NOTIFY THE UTILITY COMPANY OF JURISDICTION. THE ENGINEER SHALL ALSO BE IMMEDIATELY NOTIFIED. ANY SUCH MAINS AND SERVICES SHALL BE RESTORED TO SERVICE AT ONCE AND PAID FOR BY THE CONTRACTOR AT NO ADDITIONAL COST TO THE CONTRACT.

CALL J.U.L.I.E. FOR UTILITY INFORMATION AT 1-800-892-0123.


NOTE: SEE SHEETS 19 & 20 FOR DETAILS ON ELECTRICAL SERVICE & CONTROL FOR WIND CONES.

01/31/2005, 10:56 AM  
I:\Airports\MtVernon\B19-05RWY\Design\Sheets\R-14ELE.dgn

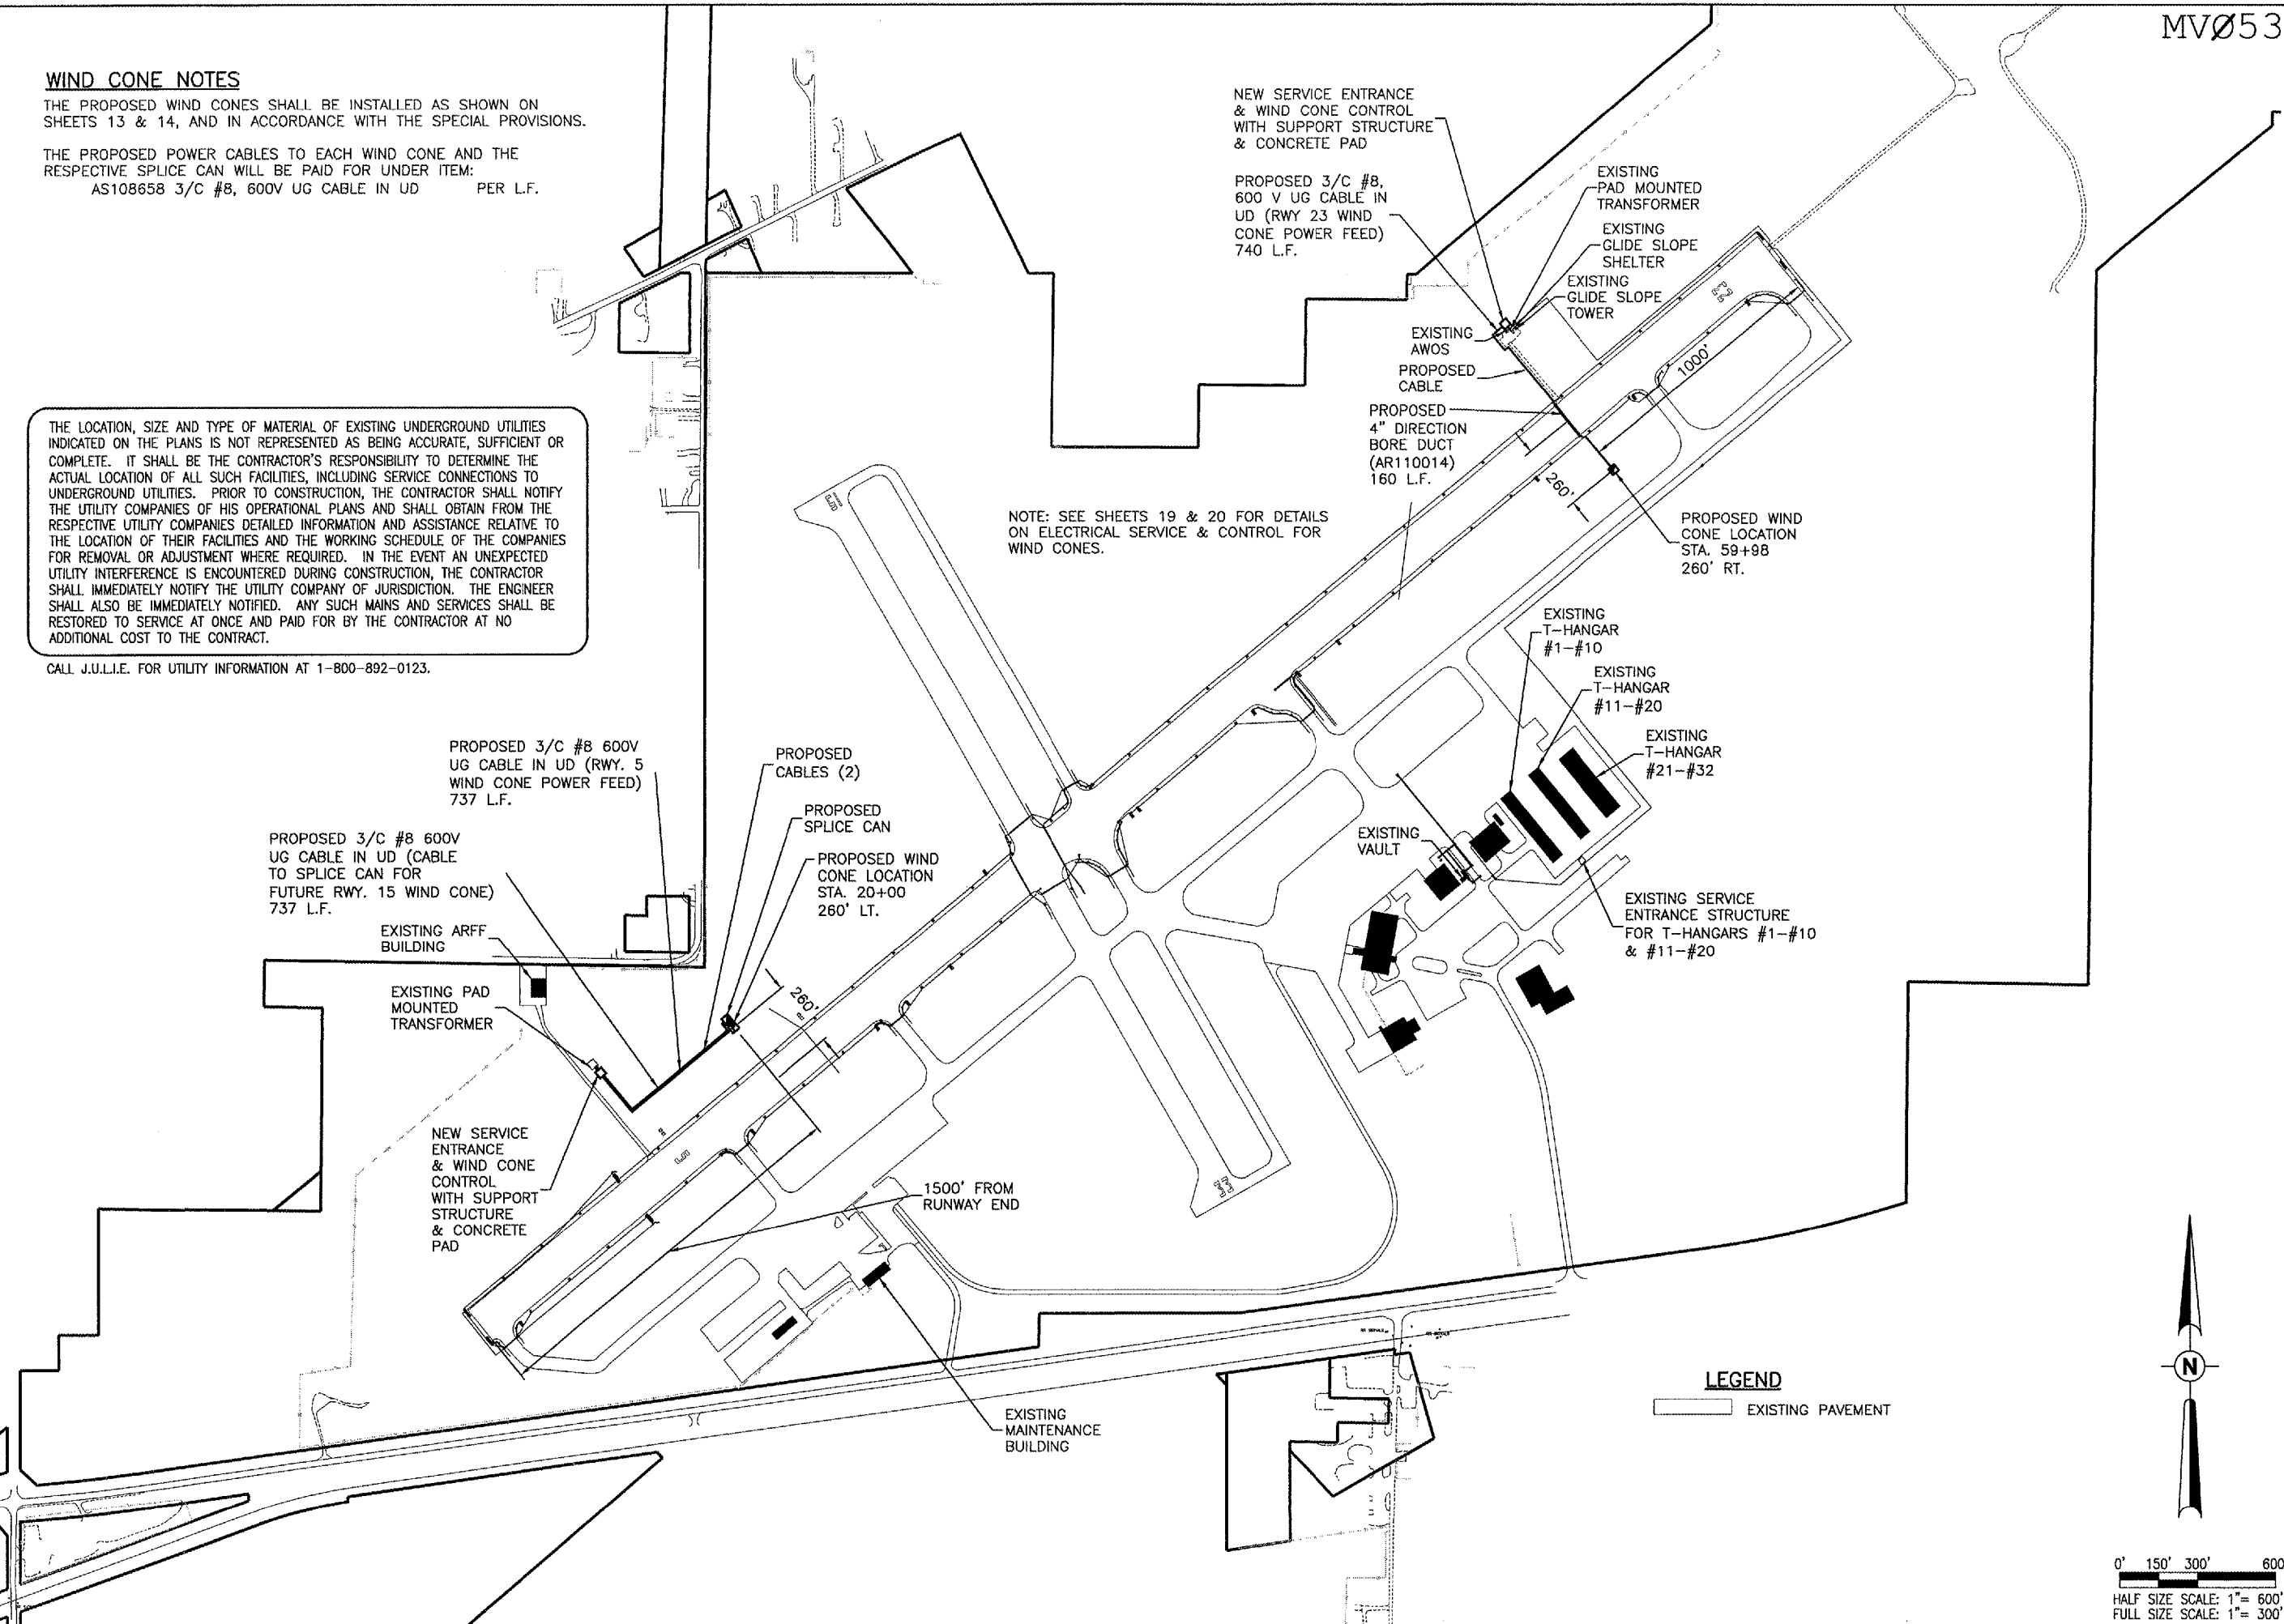

**LEGEND**

 EXISTING PAVEMENT



0' 150' 300' 600'  
HALF SIZE SCALE: 1" = 600'  
FULL SIZE SCALE: 1" = 300'

BY	
REVISION	
DATE	



IL PROJ.: MVN-3428 A.I.P. PROJ.: 3-17-0074-B1

HE Project No. B19-05RWYD 0803
Filename R-14ELE.dgn
Scale 1"=300'
Date 11/17/04
LAYOUT R.A.W. 11/17/04
DRAWN B.A.K. 11/17/04
REVIEWED C.A.H. ?



REHABILITATE RUNWAY 5-23  
PROPOSED ELECTRICAL PLAN