


*NOTE: MARKED PIPES ARE CONNECTED TO DRY LAND BRIDGE DRAINAGE SYSTEM WITH A CONCRETE COLLAR. REFER TO DRY LAND BRIDGE PLANS FOR SCUPPER AND DRAINAGE SYSTEM DETAILS

RECONSTRUCTION LIMIT O/S = 166.17 LT
 RECONSTRUCTION LIMIT O/S = 152.77' RT
 WIDENING AND RESURFACING LIMIT O/S = 120.80' RT

PLAN
 SURVEYED BY: _____ DATE: _____
 ALIGNED AND CHECKED BY: _____
 NOTE BOOK NO. _____
 PLOT FILE NAME _____

PROFILE
 SURVEYED BY: _____ DATE: _____
 GRADES CHECKED BY: _____
 NOTE BOOK NO. _____
 STRUCTURE NOTATIONS CHECKED BY: _____

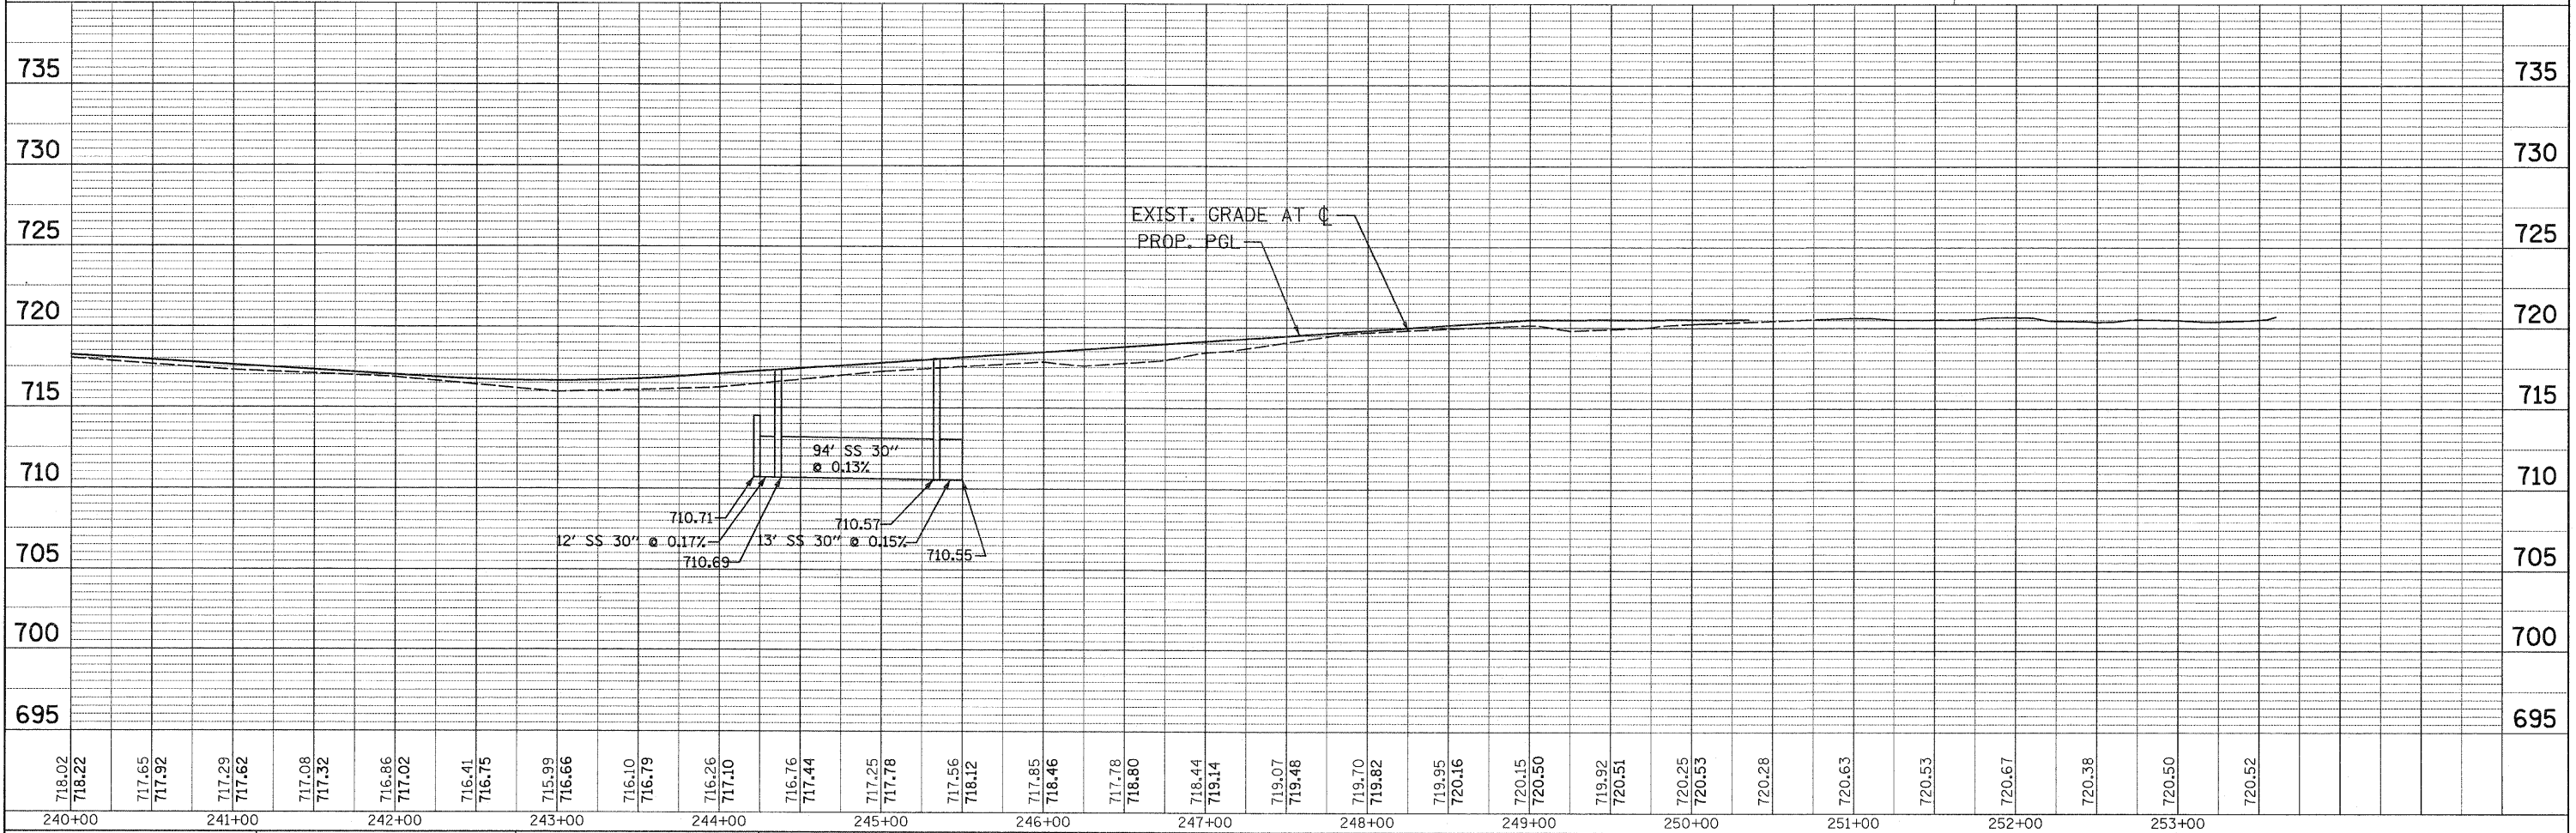


718.02	718.22	717.65	717.92	717.29	717.62	717.08	717.32	716.86	717.02	716.41	716.75	715.99	716.66	716.10	716.79	716.26	717.10	716.76	717.44	717.25	717.78	717.56	718.12	717.85	718.46	717.78	718.80	718.44	719.14	719.07	719.48	719.70	719.82	719.95	720.16	720.15	720.50	719.92	720.51	720.25	720.53	720.28	720.63	720.53	720.67	720.38	720.52	720.50	720.52
240+00	241+00	241+00	241+00	242+00	242+00	243+00	243+00	244+00	244+00	245+00	245+00	246+00	246+00	247+00	247+00	248+00	248+00	249+00	249+00	250+00	250+00	251+00	251+00	252+00	252+00	253+00	253+00	254+00	254+00	255+00	255+00	256+00	256+00	257+00	257+00	258+00	258+00	259+00	259+00	260+00	260+00	261+00	261+00	262+00	262+00	263+00	263+00	264+00	264+00

PATRICK ENGINEERING INC.
 4970 VARSITY DRIVE
 LISLE, IL 60532
 patrickengineering.com

USER NAME = ckersten@lisle.il.gov
 PLOT CONFIG = PDF(Grey, Large).plt
 PLOT SCALE = 1:620
 PLOT DATE = 1/4/2011 10:10:19 AM

DESIGNED - D.DOERFLER
 DRAWN - D.DOERFLER
 CHECKED - A.JAMES
 DATE - 01/31/2011

 REVISED -
 REVISED -
 REVISED -
 REVISED -



ILLINOIS ROUTE 53
DRAINAGE AND UTILITIES PLAN AND PROFILE

SCALE: 1"=50'
 SHEET NO. DRA-23 OF 36
 STA. 240+00 TO STA. 250+12.07

F.A.U. RTE. 2578	SECTION 532B	COUNTY DUPAGE	TOTAL SHEETS 781	SHEET NO. 278
FED. ROAD DIST. NO.		ILLINOIS FED. AID PROJECT		

CONTRACT NO. 60477

D:\IDOT\9356_A0_IL53\Drawings\CADD Sheets\019\39797-sht-drain-278.dgn