
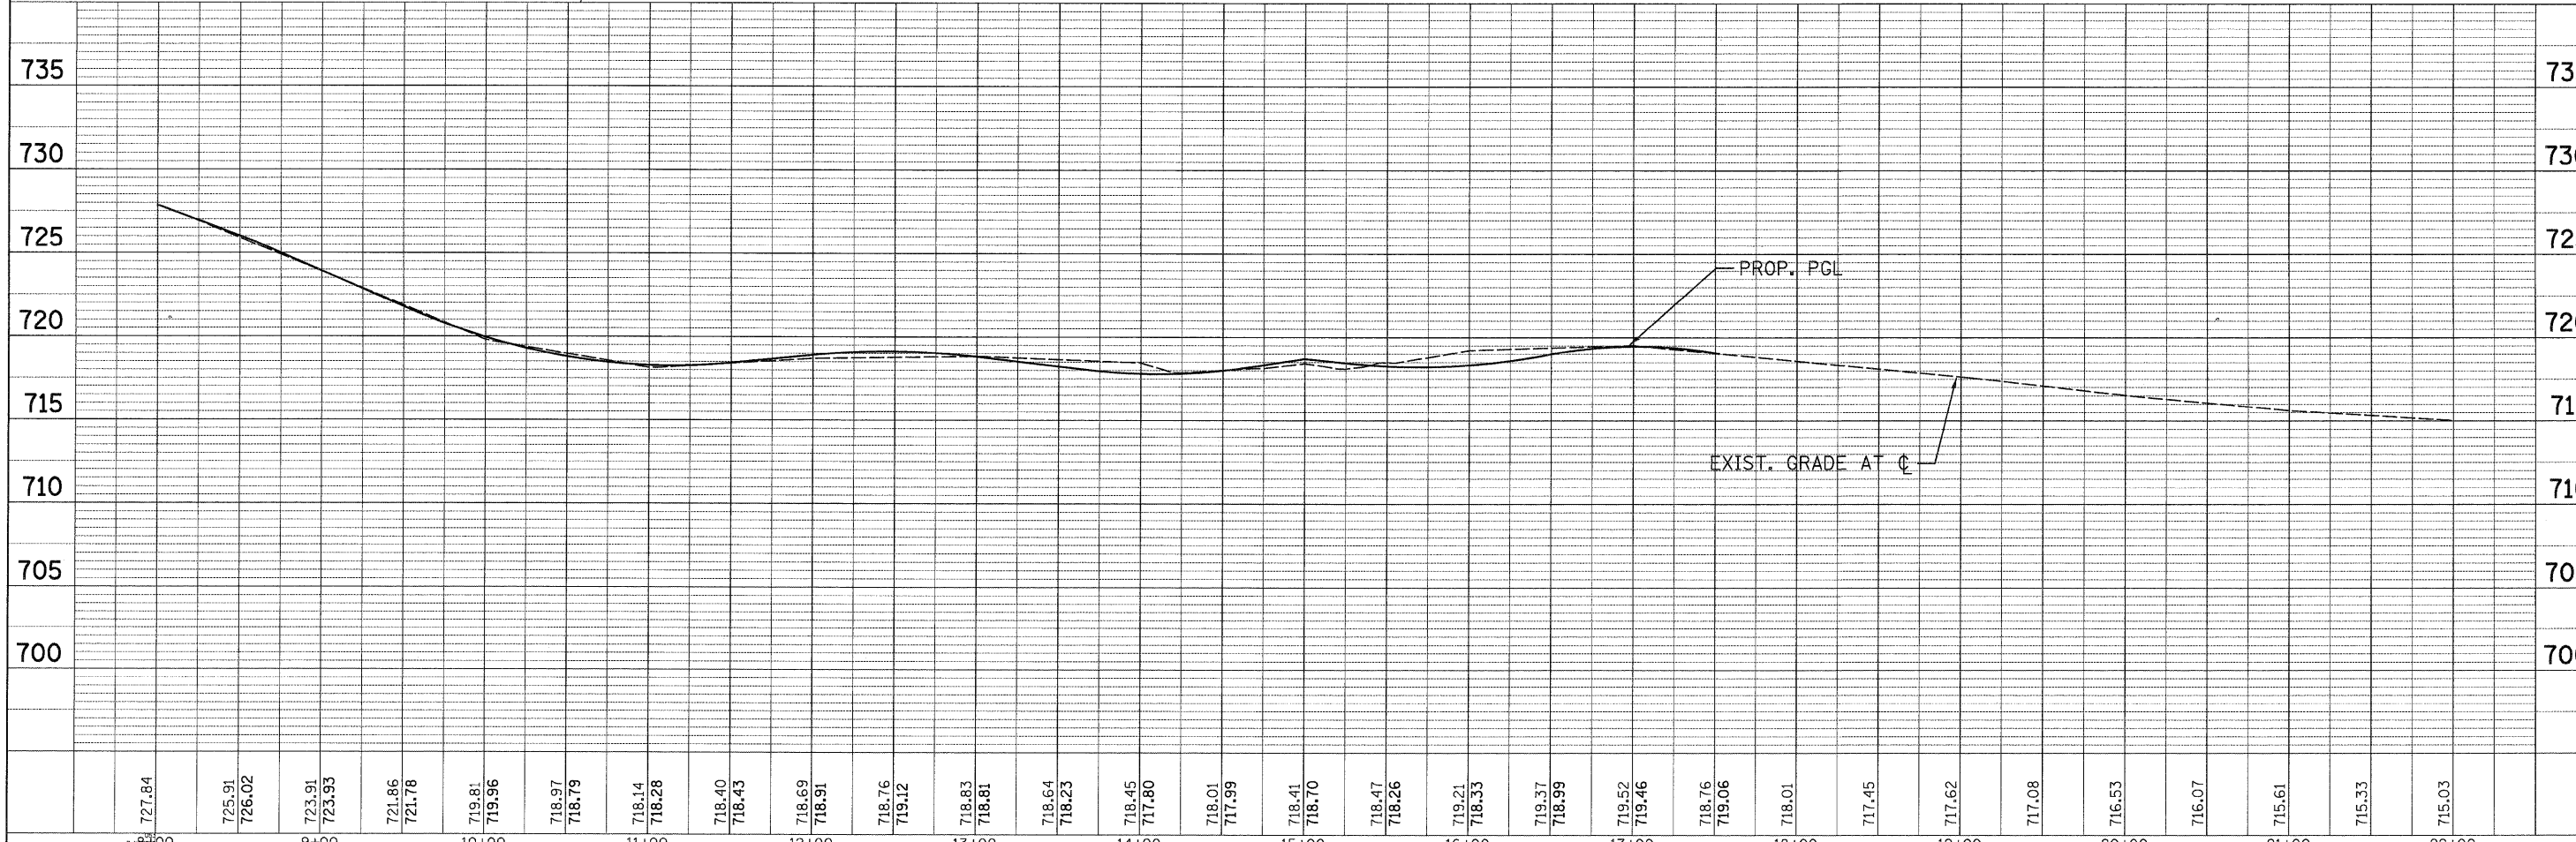


PLAN	SURVEYED	BY	DATE
	PLOTTED		
	NOTE BOOK		
	NO.		
	CHECKED		
	ALIGNED		
	DATE		
	FILE NAME		

PROFILE	SURVEYED	BY	DATE
	PLOTTED		
	NOTE BOOK		
	NO.		
	CHECKED		
	STRUCTURE		
	NOTATIONS		
	CHKD		

 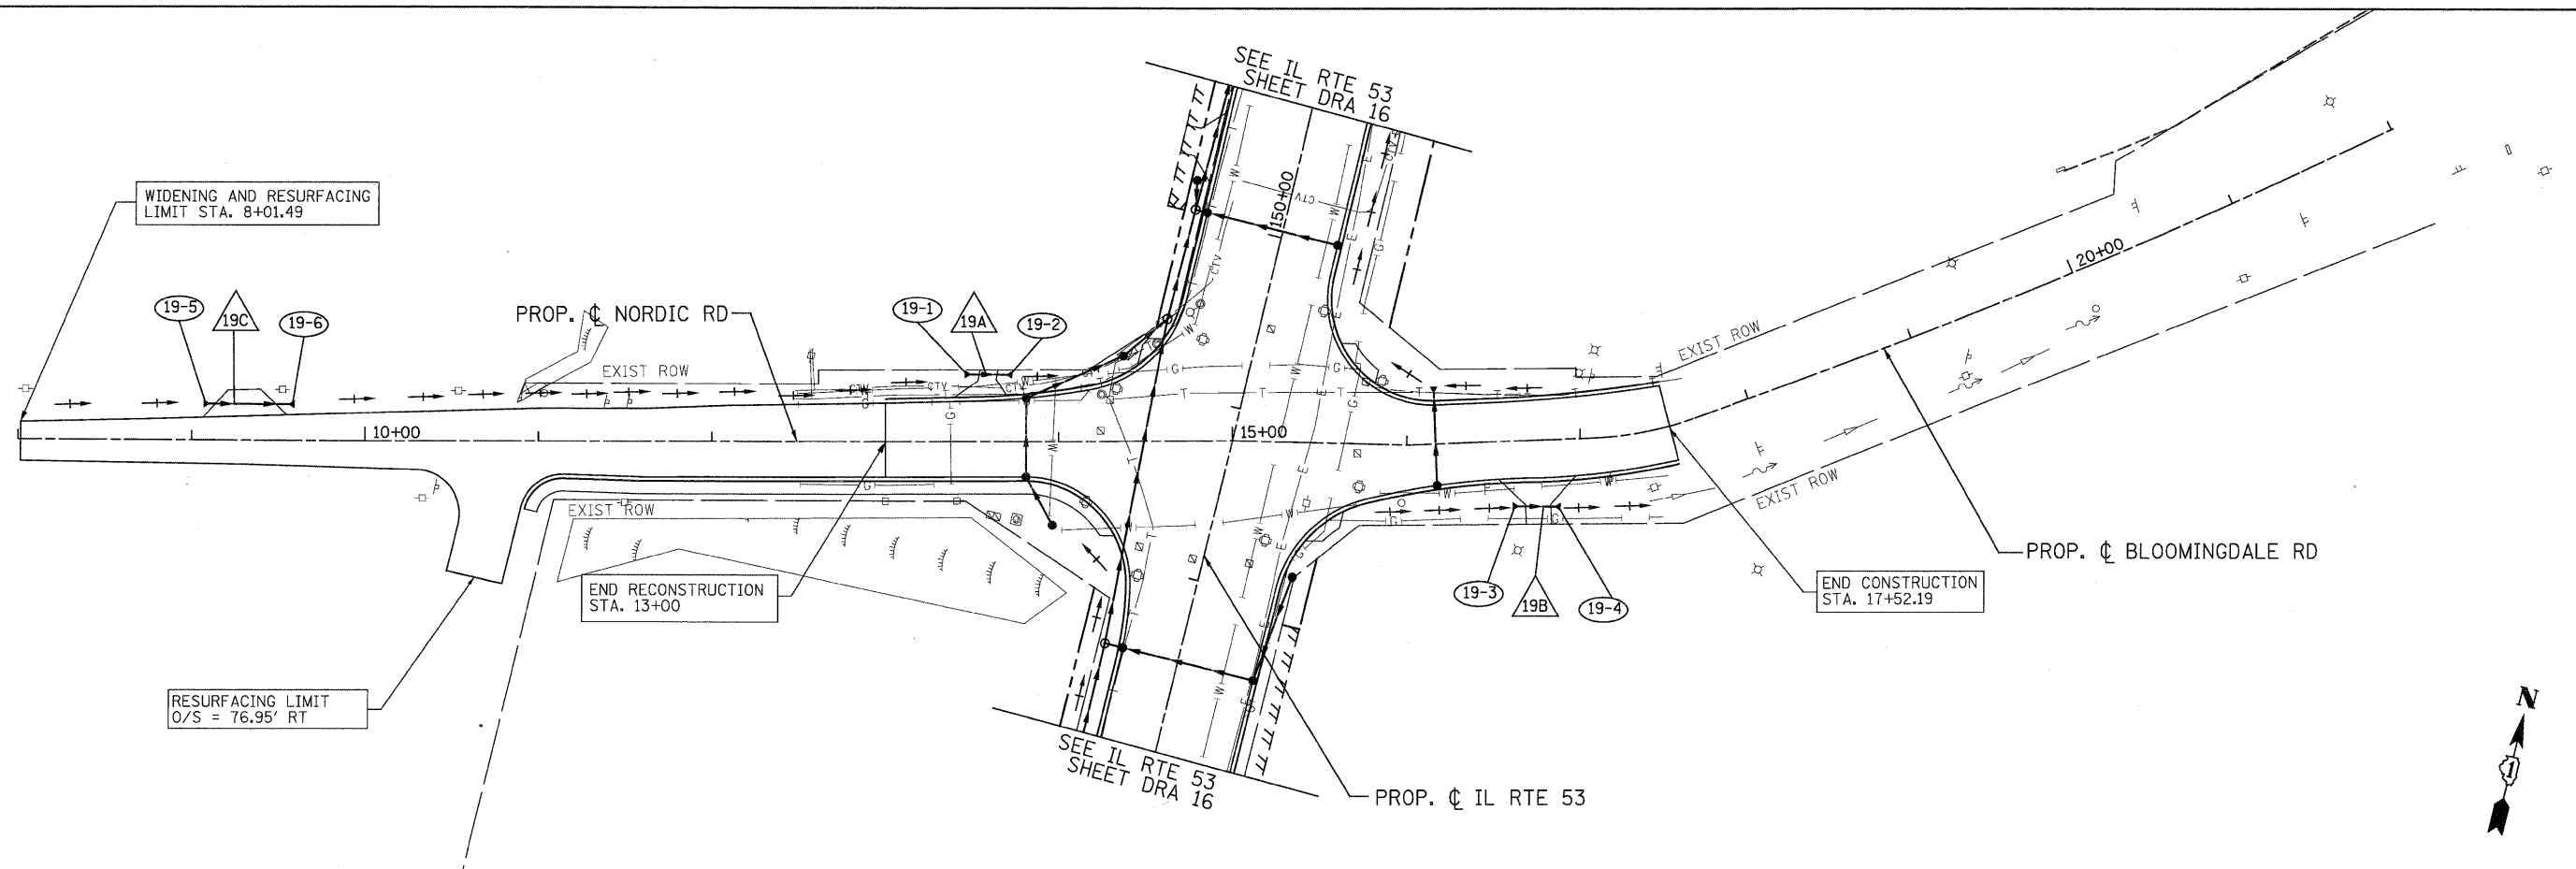


727.84	725.91	726.02	723.91	723.93	721.86	721.78	719.81	719.96	718.97	718.79	718.14	718.28	718.40	718.43	718.69	718.91	718.76	719.12	718.83	718.81	718.64	718.23	718.45	717.80	718.01	717.99	718.41	718.70	718.47	718.26	719.21	718.33	719.37	718.99	719.52	719.46	718.76	719.06	718.01	717.45	717.62	717.08	716.53	716.07	715.61	715.33	715.03
8+00	9+00	10+00	11+00	12+00	13+00	14+00	15+00	16+00	17+00	18+00	19+00	20+00	21+00	22+00																																	

PATRICK ENGINEERING INC.
 4670 VARSITY DRIVE
 USLE, IL 60532
 patrickengineering.com

USER NAME = ckersten(Lisle_R)
 PLOT CONFIG = PDF(Greg_Large).plt
 PLOT SCALE = 1:50
 PLOT DATE = 12/3/2010 1:07:01 PM

DESIGNED - D.DOERFLER
 DRAWN - D.DOERFLER
 CHECKED - A.JAMES
 DATE - 12/3/2010



**NORDIC ROAD
 DRAINAGE AND UTILITIES PLAN AND PROFILE**

SCALE: 1"=50' SHEET NO. DRA-27 OF 36 STA. TO STA.

F.A.U. RTE.	SECTION	COUNTY	TOTAL SHEETS	SHEET NO.
2578	532B	DUPAGE	781	282
CONTRACT NO. 60477			ILLINOIS FED. AID PROJECT	

G:\1001\9356.A0 - (IL53)\Drawings\CADD Sheets\019139797-shd-drain-282.dgn