
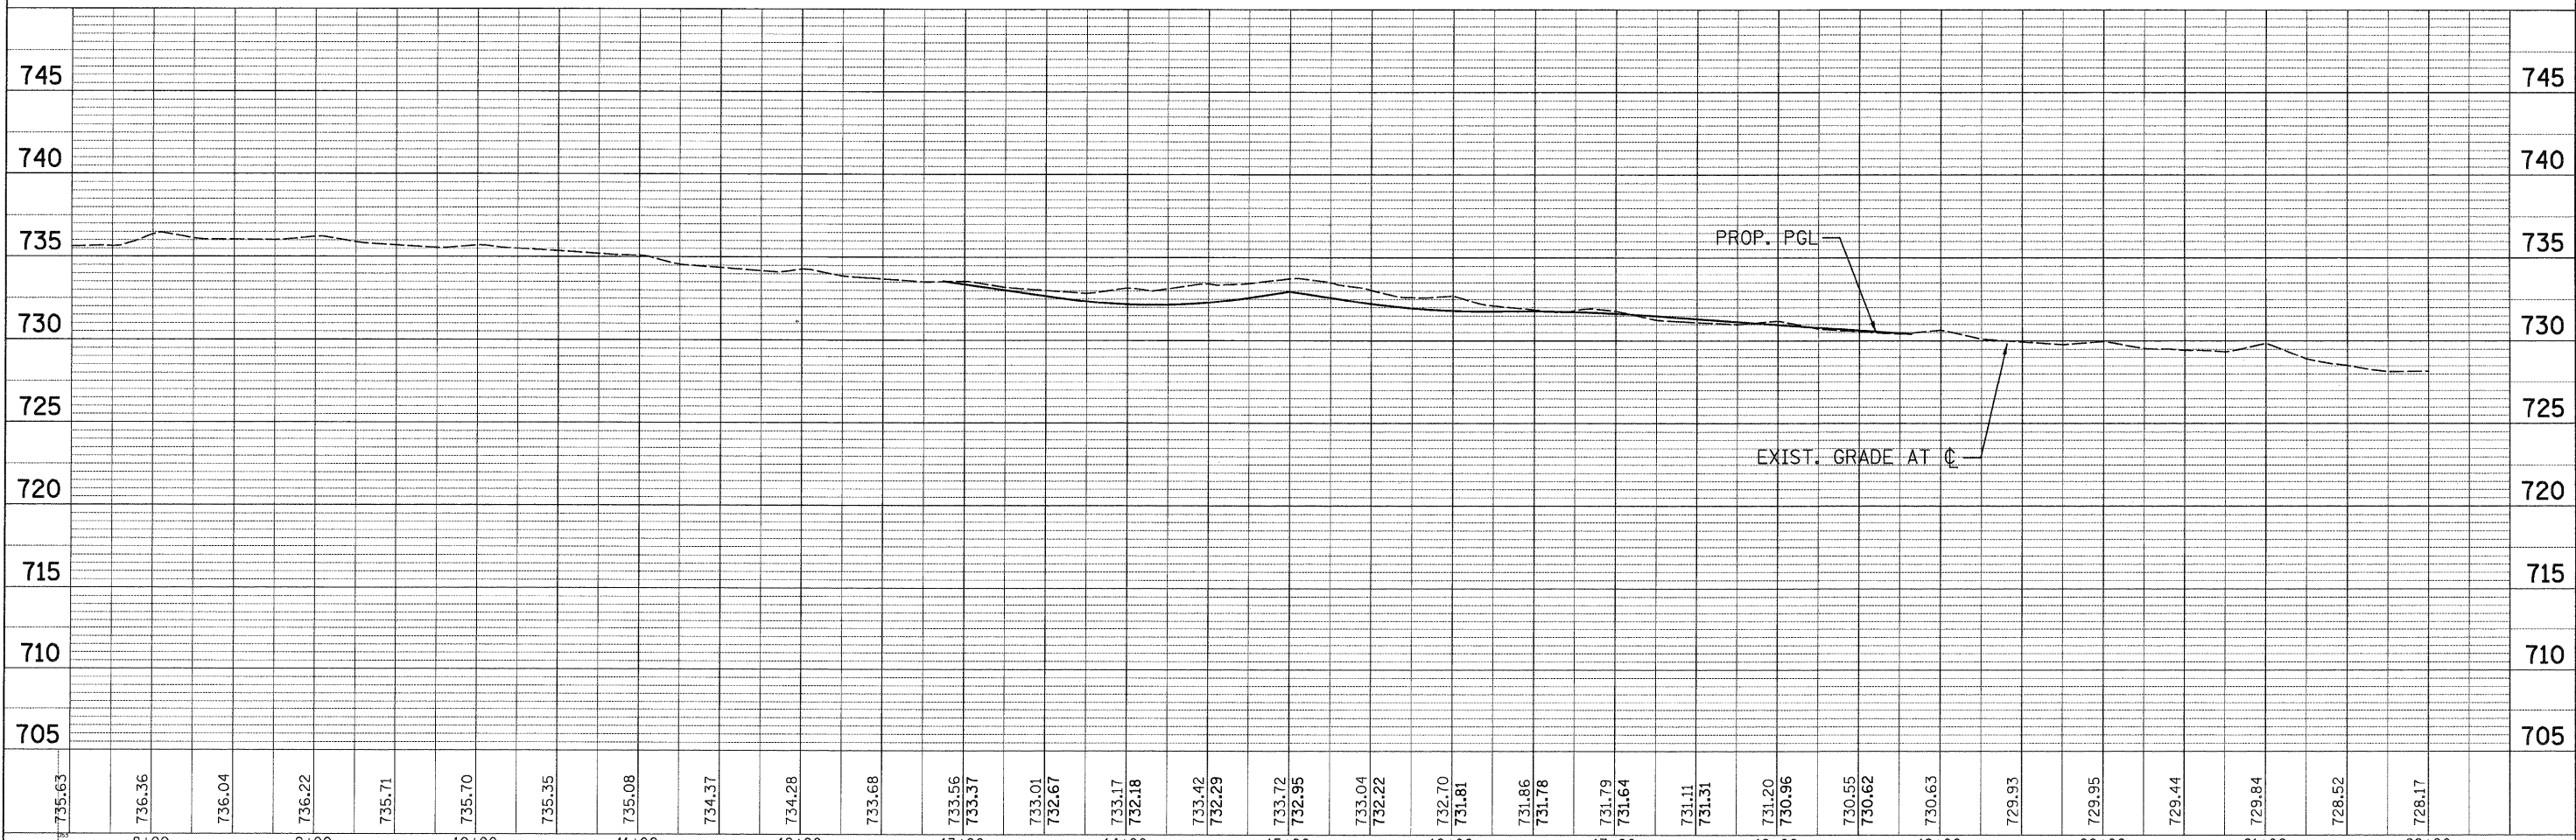


PLAN	BY	DATE
SURVEYED		
PLOTTED		
ALIGNMENT CHECKED		
NOTE BOOK NO.		
CADD FILE NAME		

PROFILE	BY	DATE
SURVEYED		
GRADES CHECKED		
STRUCTURE NOTATIONS CHECKED		
NOTE BOOK NO.		

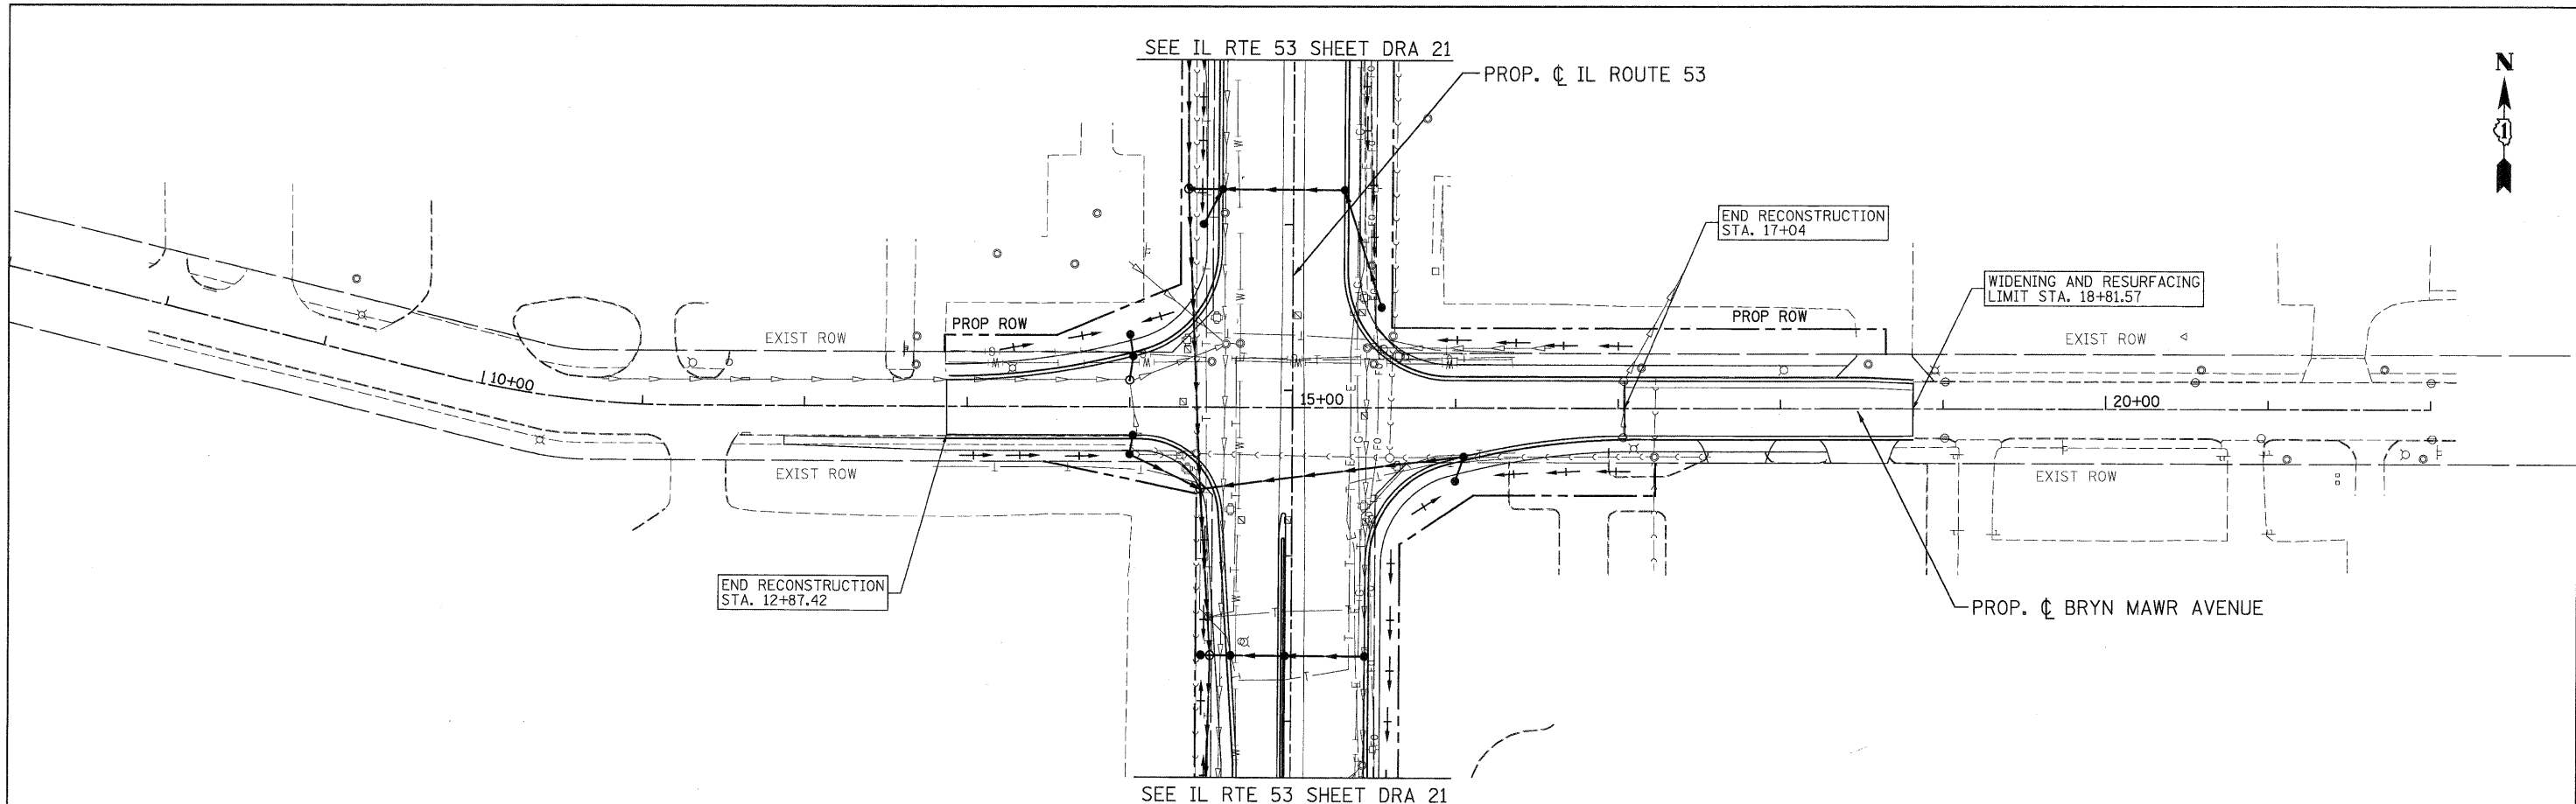

<b>PATRICK ENGINEERING INC.</b> 4970 VARSITY DRIVE LISLE, IL 60532 patrickengineering.com	USER NAME = okersten(Lisle_R) PLOT CONFIG = PDF(Gray, Large).plt PLOT SCALE = 1:50 PLOT DATE = 12/3/2018 1:07:14 PM	DESIGNED - D.DOERFLER DRAWN - D.DOERFLER CHECKED - A.JAMES DATE - 12/3/2010	REVISED - REVISED - REVISED - REVISED -	Illinois Department of Transportation	<b>BRYN MAWR AVENUE          DRAINAGE AND UTILITIES PLAN AND PROFILE</b>		F.A.U. RTE. 2578 SECTION 532B COUNTY DUPAGE ILLINOIS FED. AID PROJECT	TOTAL SHEETS 781 SHEET NO. 285 CONTRACT NO. 60477
	SCALE: 1"=50' SHEET NO. DRA-30 OF 36 STA. 11+00 TO STA. 19+45				FED. ROAD DIST. NO.			

Q:\DOT\9356.A0\_(IL53)\Drawings\CADD Sheets\019139797-shd-drain\_285.dgn