
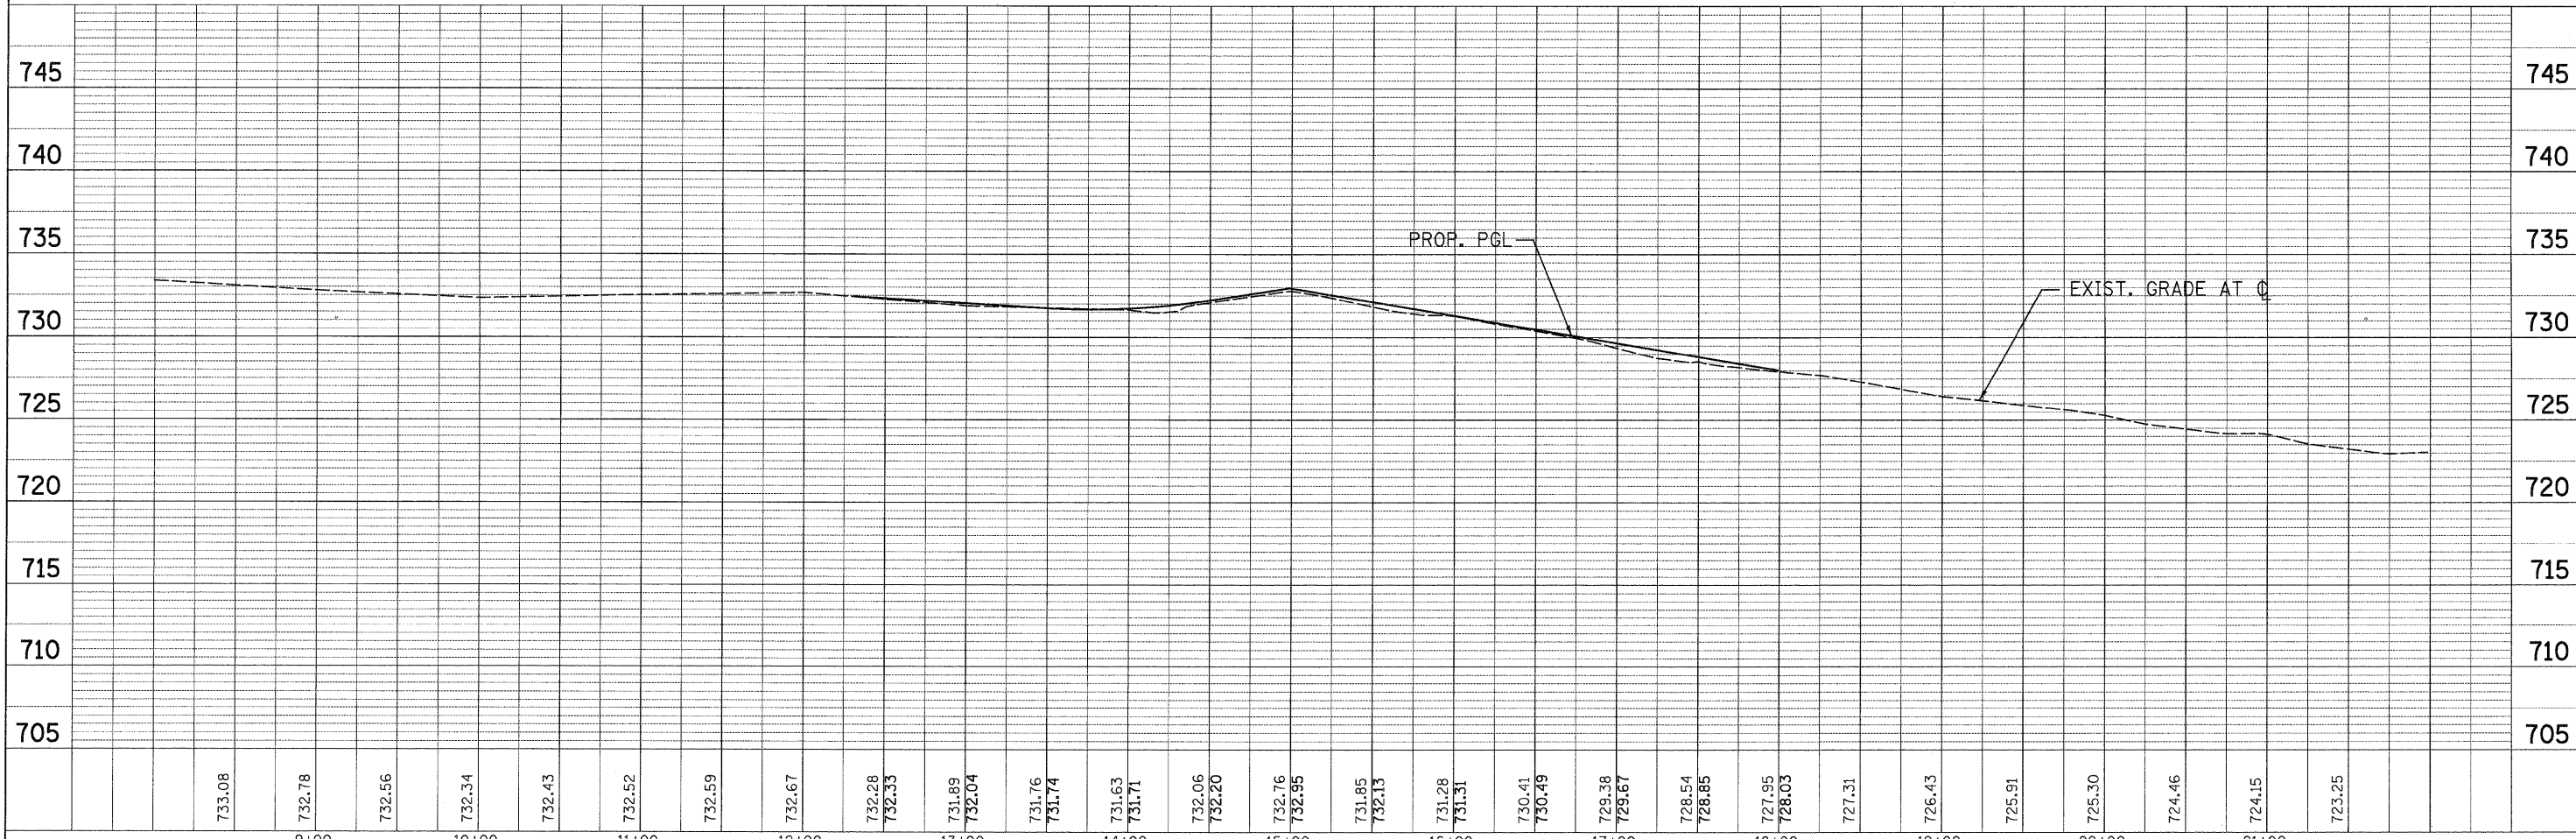


PLAN	DESIGNED	BY	DATE
	PROPOSED		
	ALIGNED		
	CHECKED		
	NO.		
	FILE NAME		

PROFILE	GRADES CHECKED	BY	DATE
	STRUCTURE NOT AT THIS CHORD		
	NO.		

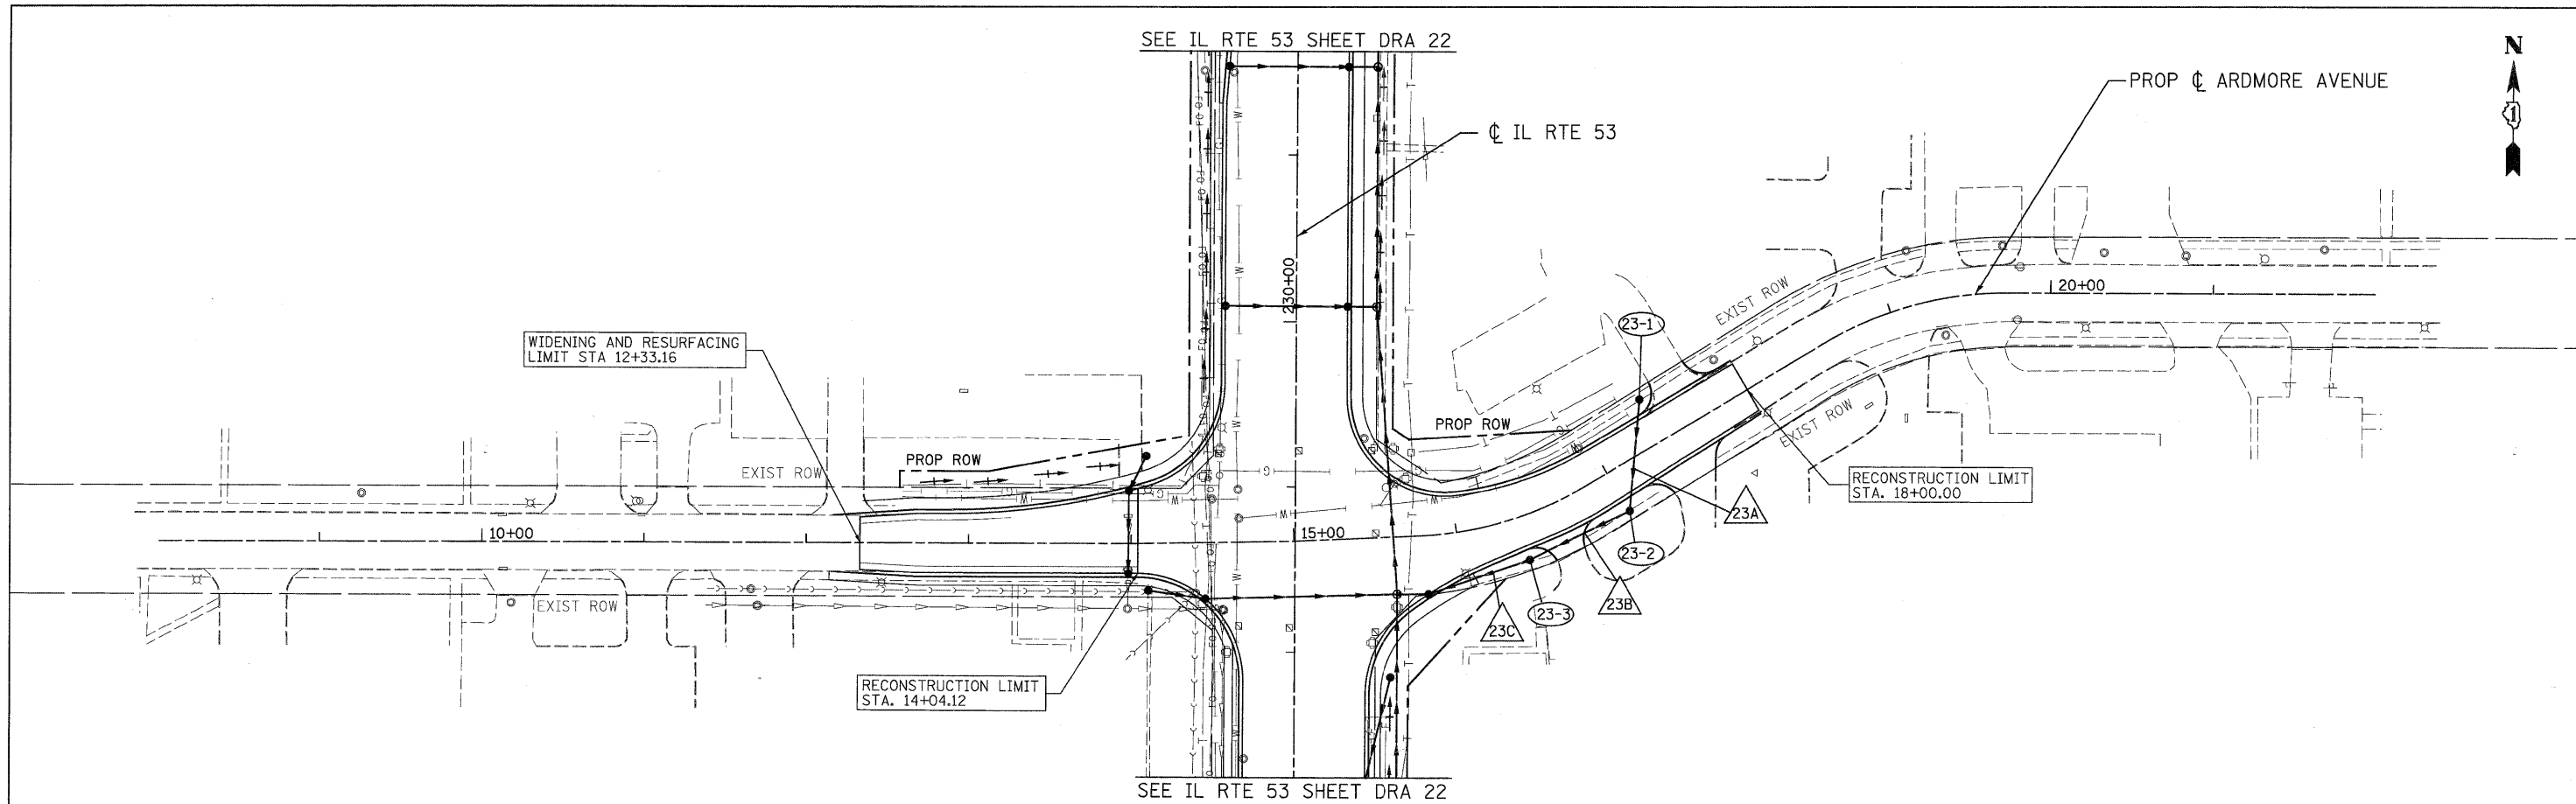

<b>PATRICK ENGINEERING INC.</b> 4070 VARSITY DRIVE LISLE, IL 60532 patrickengineering.com	USER NAME = ckersten(Lisle_R)	DESIGNED - D.DOERFLER	REVISED -	<b>Illinois Department of Transportation</b>	<b>ARDMORE AVENUE DRAINAGE AND UTILITIES PLAN AND PROFILE</b> SCALE: 1"=50'    SHEET NO. DRA-31 OF 36    STA. 11+50.00 TO STA. 17+81.53			F.A.U. RTE. 2578	SECTION 532B	COUNTY DUPAGE	TOTAL SHEETS 781	SHEET NO. 286
	PLOT CONFIG= PDFI(Gray_Large).plt	DRAWN - D.DOERFLER	REVISED -					CONTRACT NO. 60477				
	PLOT SCALE = 1:50	CHECKED - A.JAMES	REVISED -					ILLINOIS FED. AID PROJECT				
	PLOT DATE = 12/3/2010 1:07:18 PM	DATE - 12/3/2010	REVISED -									

G:\DOT\9356\_A0\_IL\53\Drawings\CADD Sheets\019139797-sht-drain\_286.dgn