
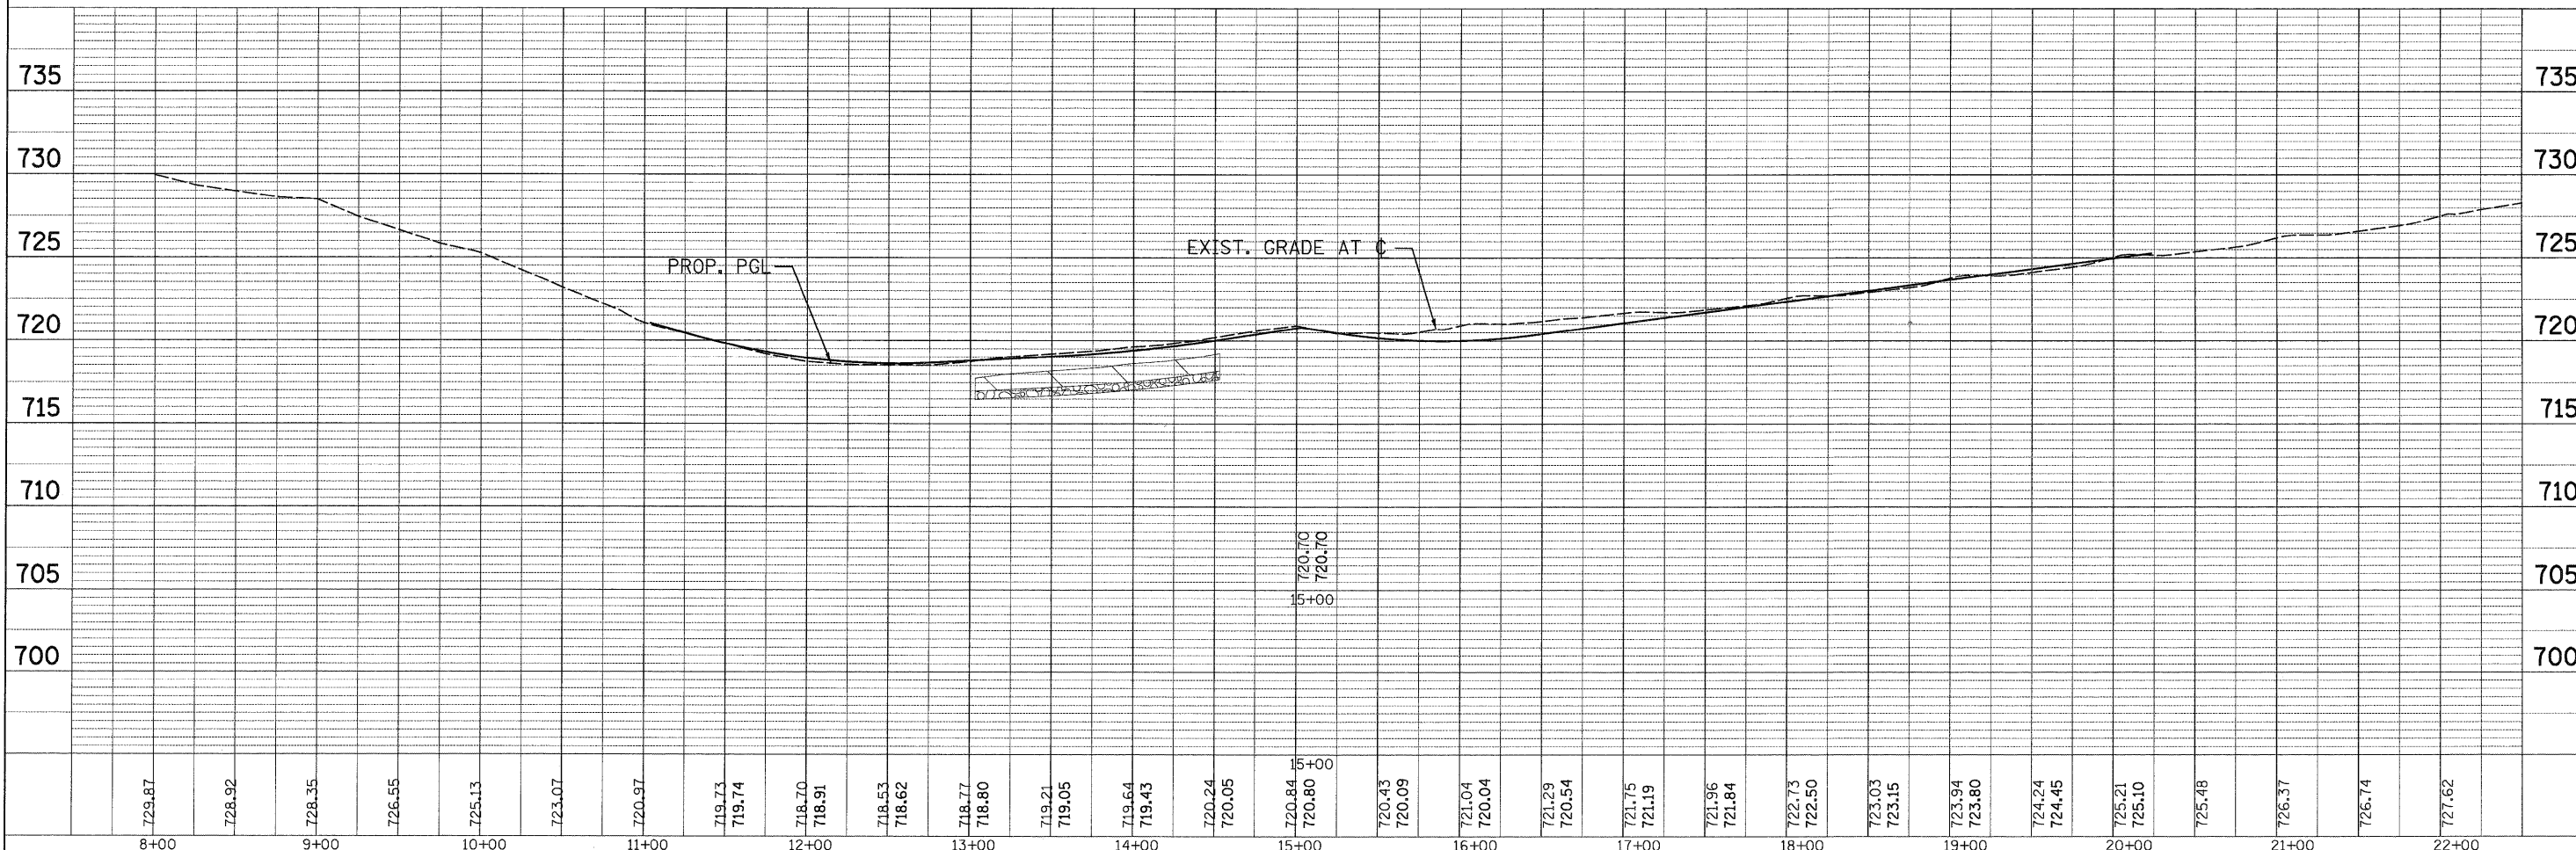


| | | |
|------|-----------|------|
| PLAN | SURVEYED | DATE |
| | PLOTTED | |
| | CHECKED | |
| | BY | |
| | NO. | |
| | FILE NAME | |

| | | |
|---------|-----------|------|
| PROFILE | SURVEYED | DATE |
| | PLOTTED | |
| | CHECKED | |
| | BY | |
| | NO. | |
| | FILE NAME | |

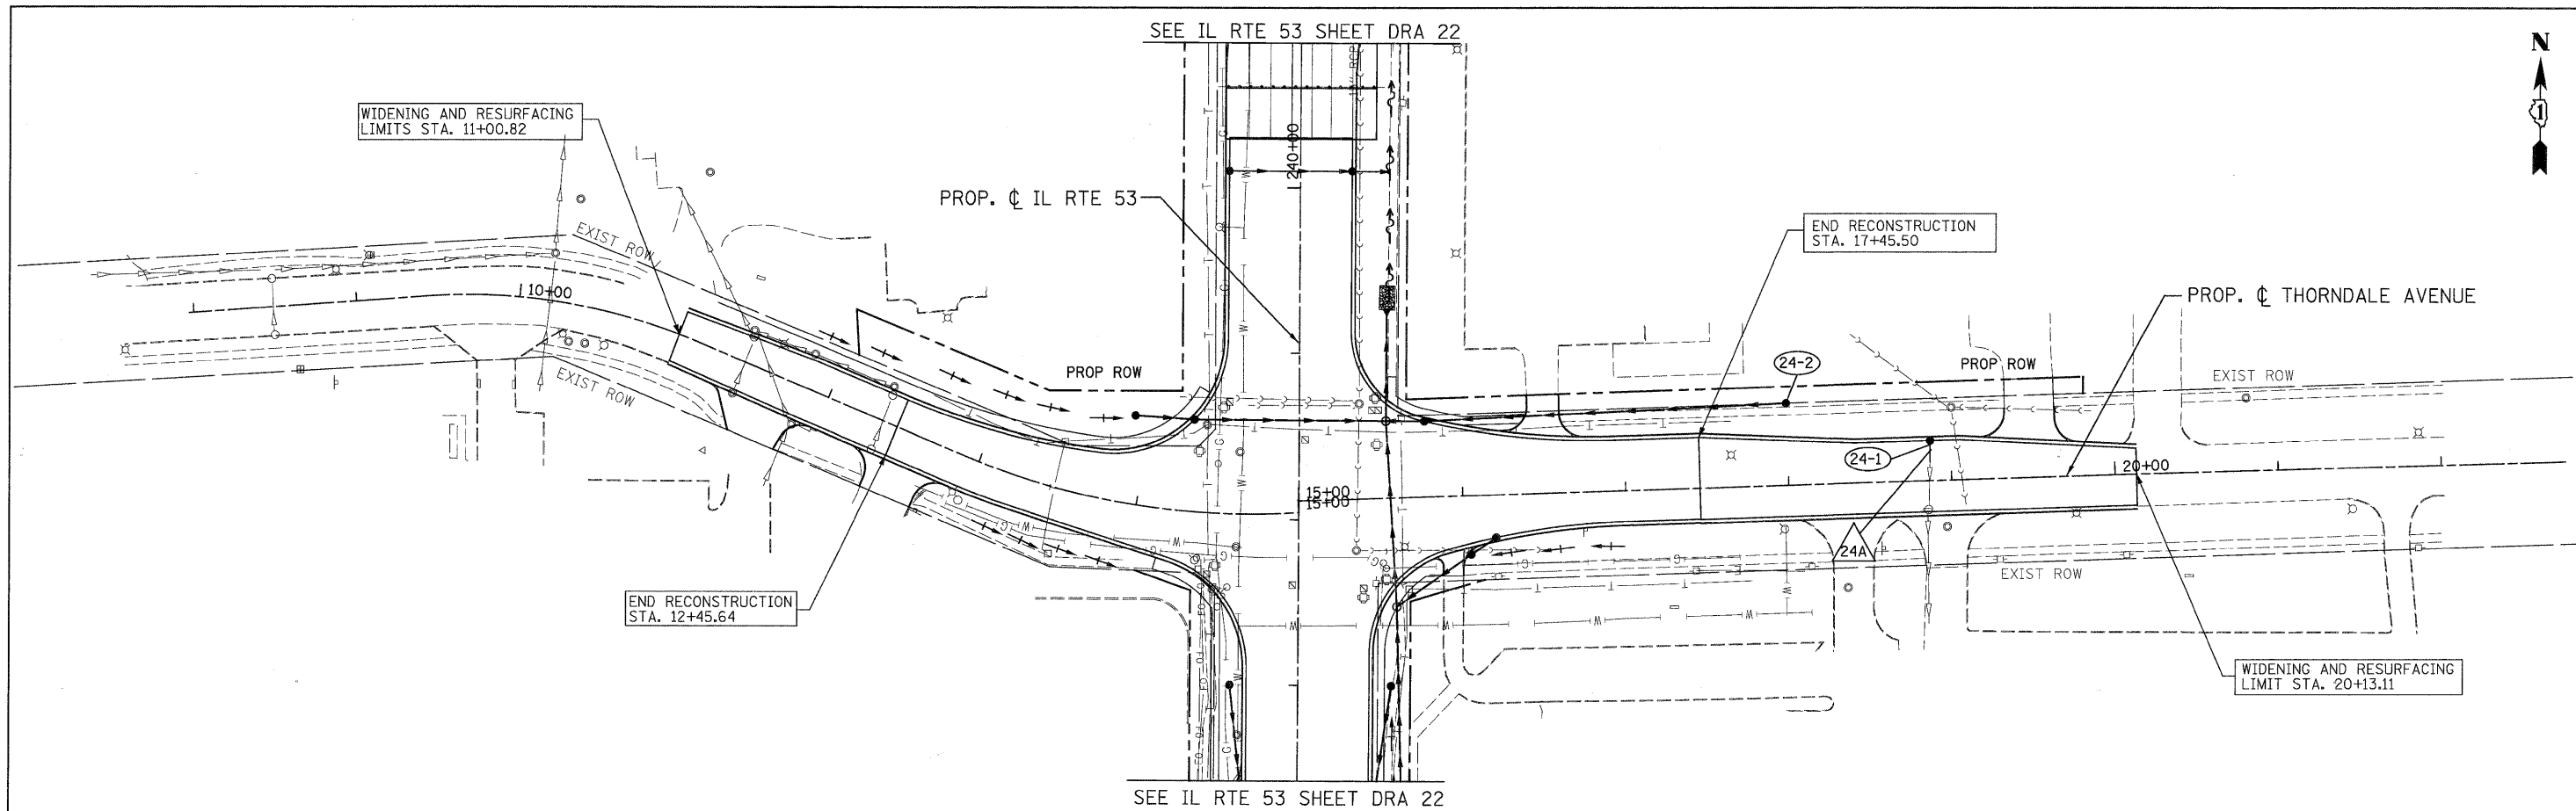


| | | | | | | | | | | | | | | | | | | | | | | | | | | | | | | | | | | | | | | | | | | | | | | | | | | | | | |
|---|
| 8+00 | 729.87 | 9+00 | 728.92 | 10+00 | 728.35 | 11+00 | 726.55 | 725.13 | 723.07 | 720.97 | 719.73 | 719.74 | 718.70 | 718.91 | 718.53 | 718.62 | 718.77 | 718.80 | 719.21 | 719.05 | 719.64 | 719.43 | 720.24 | 720.05 | 720.84 | 720.80 | 720.70 | 720.70 | 720.43 | 720.09 | 721.04 | 720.04 | 721.29 | 720.54 | 721.75 | 721.19 | 721.96 | 721.84 | 722.73 | 722.50 | 723.03 | 723.15 | 723.94 | 723.80 | 724.24 | 724.45 | 725.21 | 725.10 | 725.48 | 726.37 | 726.74 | 727.62 | 22+00 |
|---|

PATRICK ENGINEERING INC.
4970 VARSITY DRIVE
LISLE, IL 60532
patrickengineering.com

USER NAME = ckersten(Lisle.R)
PLOT CONFIG = PDFIgray_Large.plt
PLOT SCALE = 1:50
PLOT DATE = 12/3/2010 1:07:22 PM

DESIGNED - D.DOERFLER
DRAWN - D.DOERFLER
CHECKED - A.JAMES
DATE - 12/3/2010

 REVISED -
REVISED -
REVISED -
REVISED -



**THORNDALE AVENUE
DRAINAGE AND UTILITIES PLAN AND PROFILE**

SCALE: 1"=50' SHEET NO. DRA-32 OF 36 STA. 9+50 TO STA. 20+12

| | | | | |
|---------------------|---------|---------------------------|--------------|-----------|
| F.A.U. RTE. | SECTION | COUNTY | TOTAL SHEETS | SHEET NO. |
| 2578 | 532B | | 781 | 287 |
| FED. ROAD DIST. NO. | | ILLINOIS FED. AID PROJECT | | |
| | | CONTRACT NO. 60477 | | |

G:\IDOT\9356_A6_(IL53)\Drawings\CADD Sheets\019139797-ahd-drain-287.dgn