
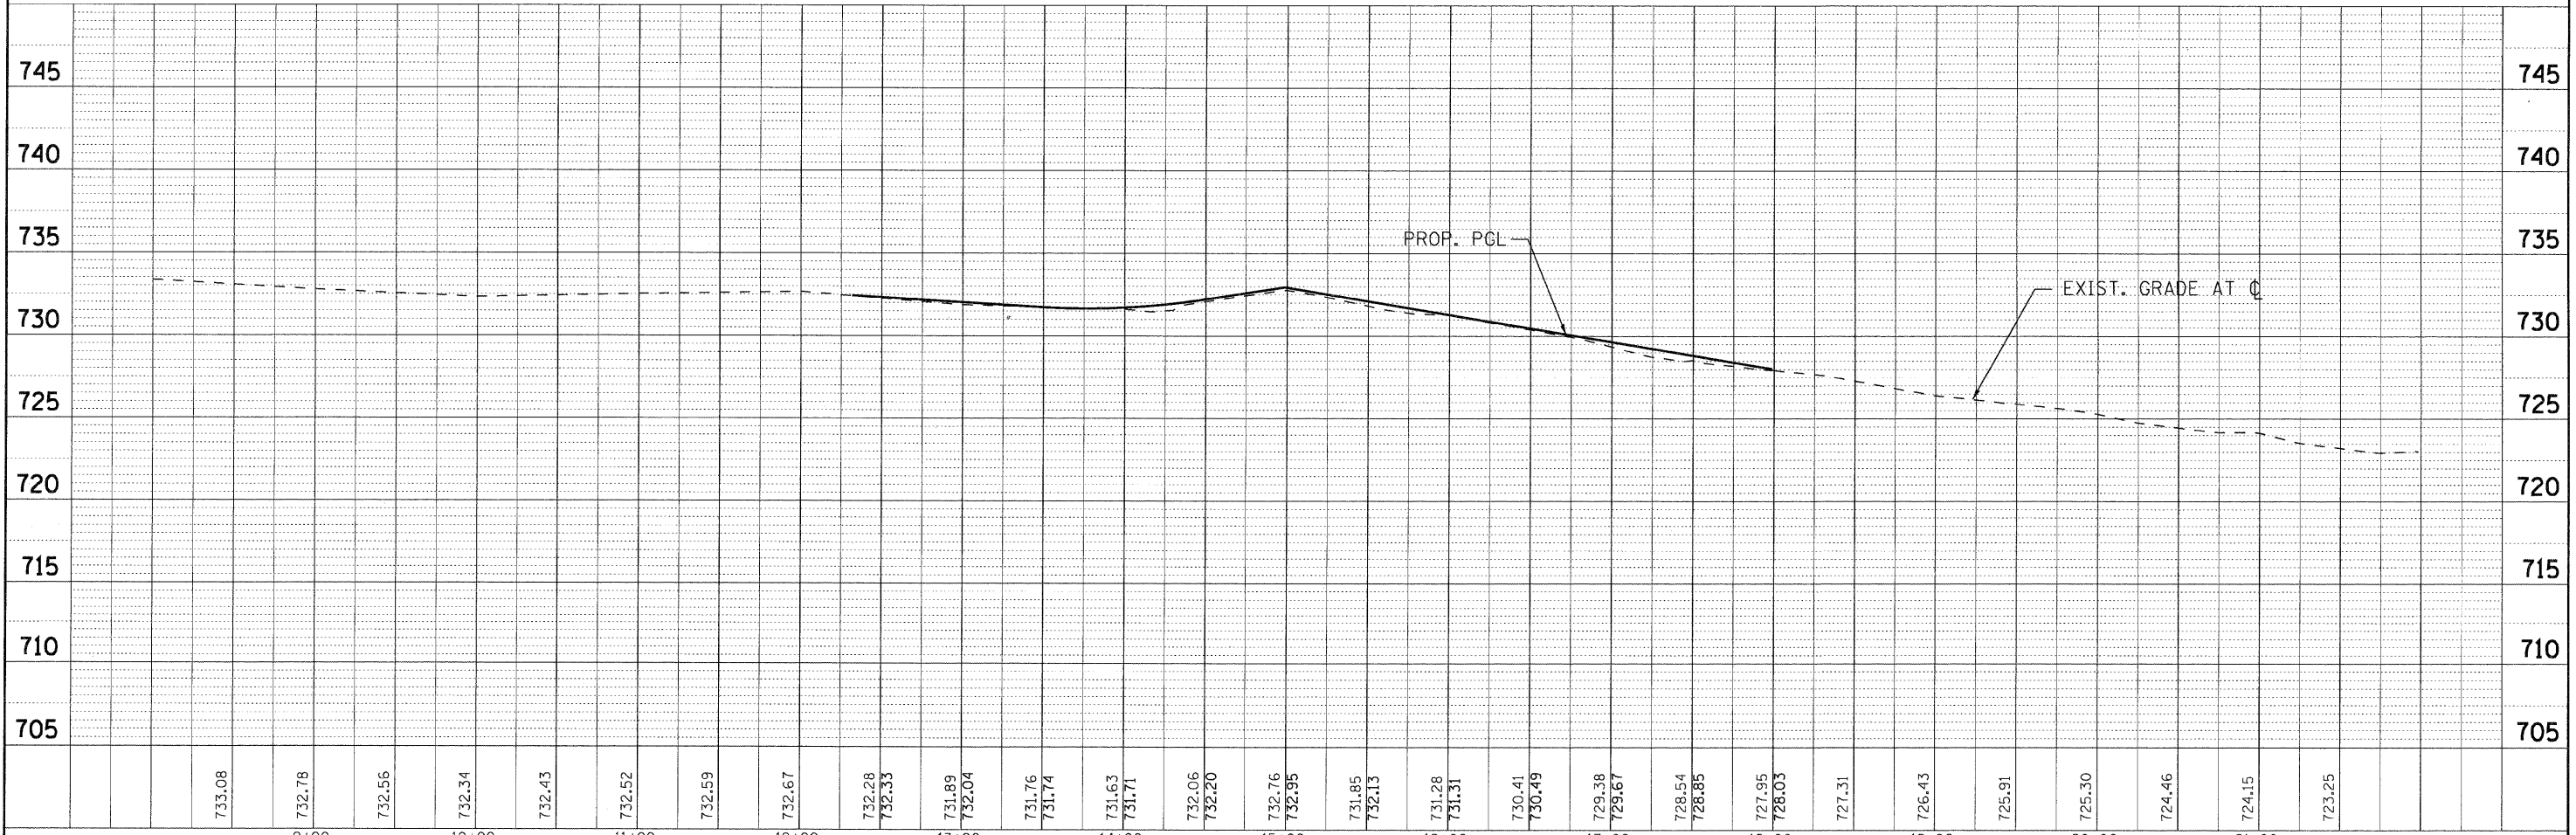


PLAN	SURVEYED	BY	DATE
	PLOTTED		
	NOTED		
	NOTE BOOK NO.		
	STRUCTURE NOTATION'S		
	NO.		
	FILE NAME		

PROFILE	SURVEYED	BY	DATE
	PLOTTED		
	NOTED		
	NOTE BOOK NO.		
	STRUCTURE NOTATION'S		
	NO.		
	FILE NAME		

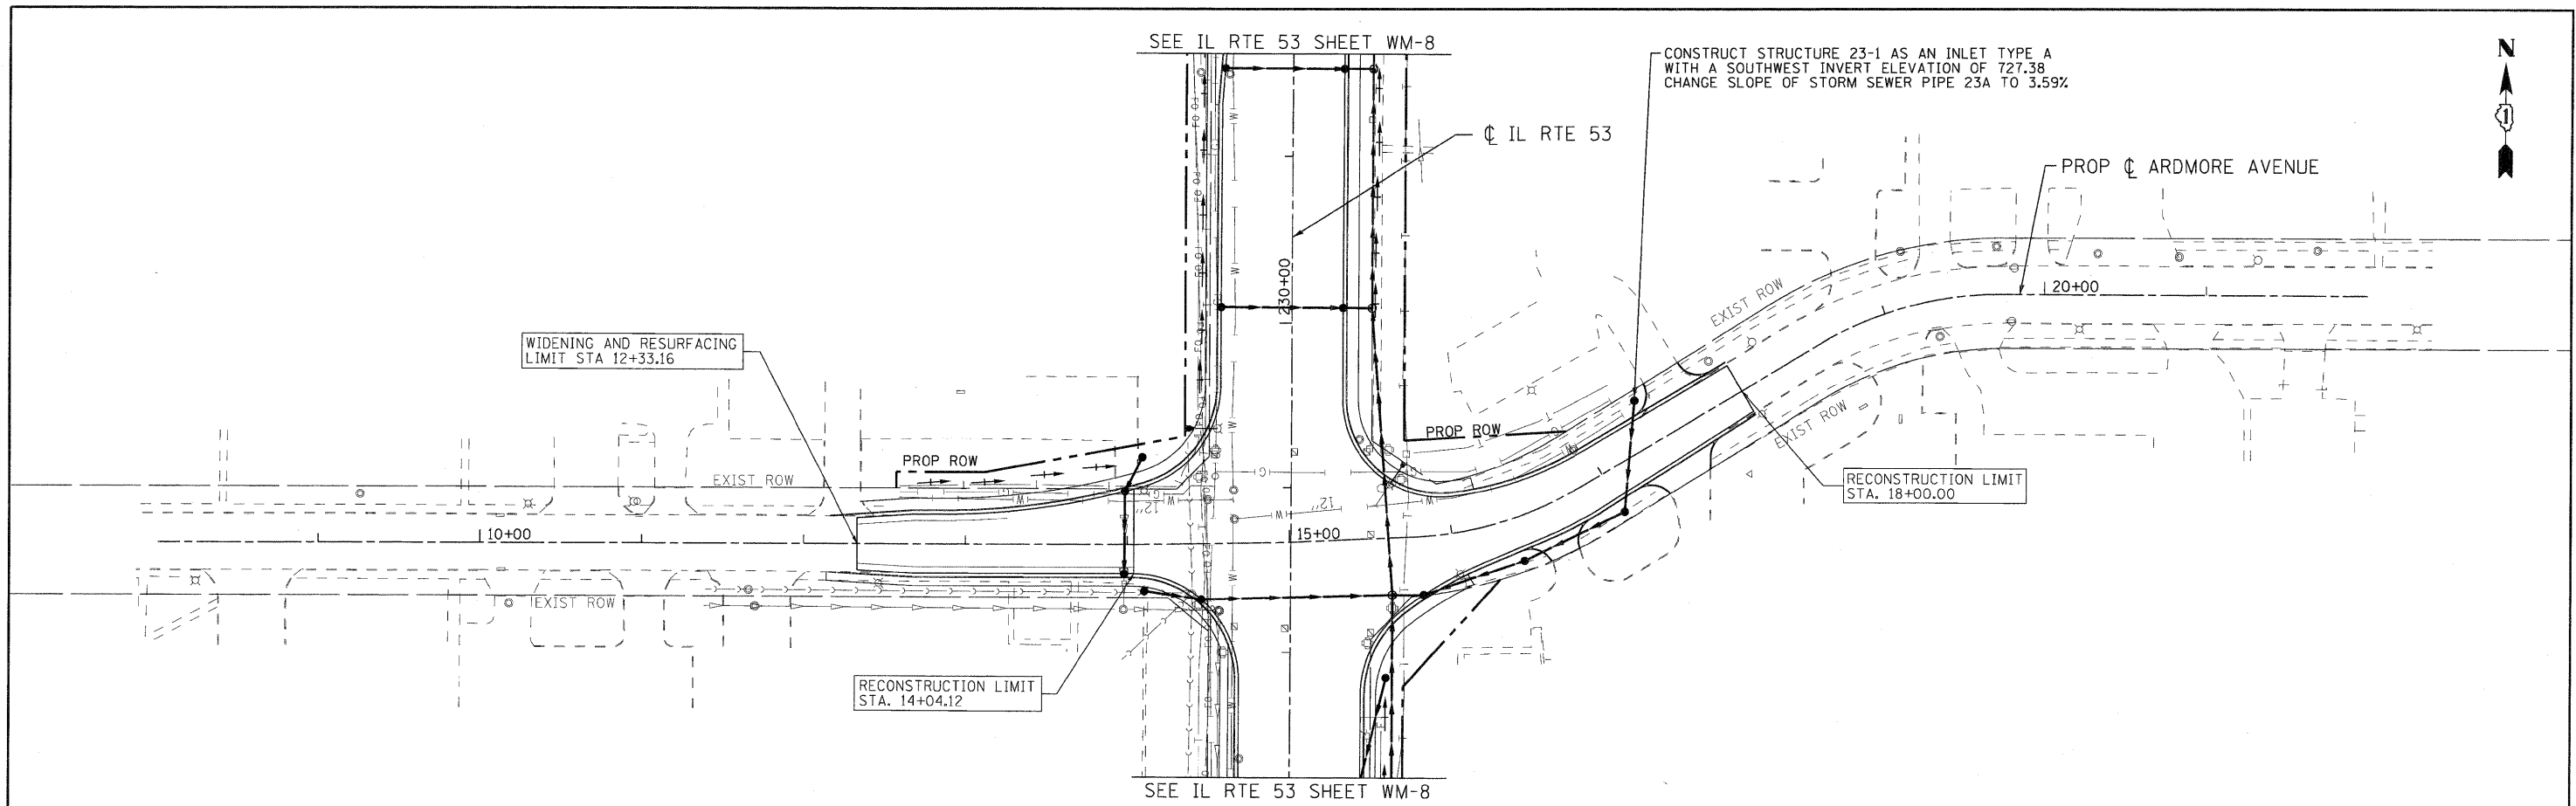

	USER NAME = lusername	DESIGNED - SMV	REVISED -		ARDMORE AVENUE WATER AND SEWER REPLACEMENT PLAN AND PROFILE			F.A.U. RTE. 2578	SECTION 532B	COUNTY	TOTAL SHEETS 781	SHEET NO. 361
	PLT CONFIG = PDF22X34.plt	DRAWN - LKB	REVISED -		SCALE: 1"=50'	SHEET NO. WM-13 OF 18	STA. 11+50.00 TO STA. 17+81.53	FED. ROAD DIST. NO.	ILLINOIS FED. AID PROJECT	CONTRACT NO. 60477		
PLT SCALE = 1:50	CHECKED - SMV	DATE - 7-30-2010	REVISED -									
PLT DATE = 11/24/2010 9:23:56 AM												

I:\Crystal Lake\1145V\102547-Rt 53 W and S\CADD-SURVEY\DRAWINGS\DCNS\B&W-WM-PP-sht.27B.dgn