


MATCH LINE SEE DRAWING RL-2  
PATH STA 158+50

EXISTING CONTROLLER CABINET #1  
(MAIN DISTRIBUTION CENTER MDC).  
CONTAINS MAIN DISTRIBUTION  
PANEL MDP AND LIGHTING PANELS  
LP1 AND LP2

**NOTES:**

1. SEE DRAWING GE-1 FOR ELECTRICAL SYMBOL LIST, ABBREVIATIONS, AND GENERAL NOTES.
2. THE CONTRACTOR SHALL FURNISH AND INSTALL NEW WIRING FROM RELOCATED POLE P64 TO POLE P65, AND SPLICE TO EXISTING CIRCUIT IN LIGHT POLE P65 HANDHOLE. CHANGE OVER SHALL BE DONE DURING DAYLIGHT HOURS AFTER ALL OTHER WORK IS DONE. MAINTAIN EXISTING LIGHTING DURING HOURS OF DARKNESS. ALL MATERIALS AND LABOR FOR CONNECTING NEW WIRING TO EXISTING LIGHT POLE (LIGHTING STANDARD) SHALL BE INCLUDED IN THE "1/4\" DIA. COILABLE NONMETALLIC CONDUIT IN TRENCH\" PAY ITEM. SEPARATE PAYMENT WILL NOT BE MADE.

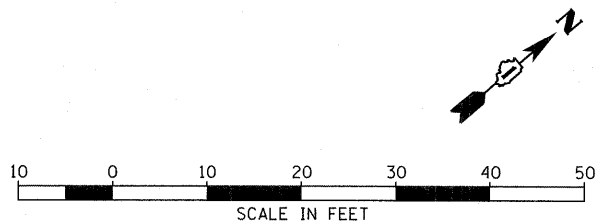

McDonough Associates Inc.  
Engineers / Architects  
130 East Randolph Street Chicago, Illinois 60601

FILE NAME = DI60K64-SHT-RL1.dgn	USER NAME = jlefour	DESIGNED - JLW	REVISED -
		DRAWN - CJM	REVISED -
		CHECKED - KMY	REVISED -
		DATE - 12/17/10	REVISED -

**STATE OF ILLINOIS  
DEPARTMENT OF TRANSPORTATION**

**MULTI-USE PATH PROPOSED LIGHTING PLAN**

F.A.P. RTE. 330	SECTION 73 R-B	COUNTY COOK	TOTAL SHEETS 136	SHEET NO. 42
RL-1		CONTRACT NO. 60K64		
ILLINOIS FED. AID PROJECT				

SCALE: 1" = 10' SHEET NO. 1 OF 5 SHEETS STA. 155+50 TO STA. 158+50