



STATE OF ILLINOIS
DEPARTMENT OF TRANSPORTATION

GENERAL NOTES:


1. Refer to Civil Drawings for grade elevations.
2. Refer to Civil Drawings for retaining wall dimensions.
3. Refer to Piping Drawings for existing piping layout.
4. All water feature piping is schedule 80 PVC unless indicated otherwise.

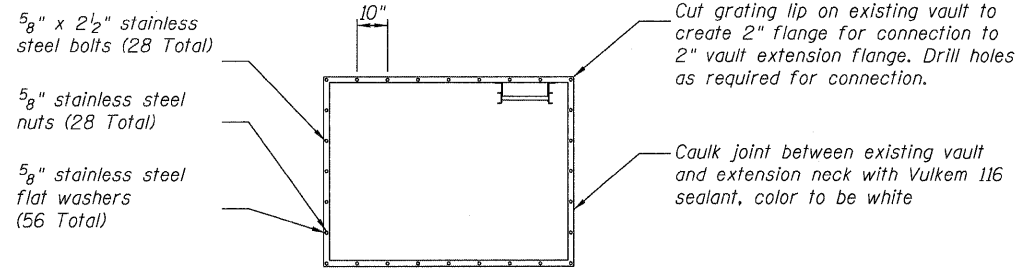


FLANGE DETAIL
Scale: 3/8" = 1'-0"

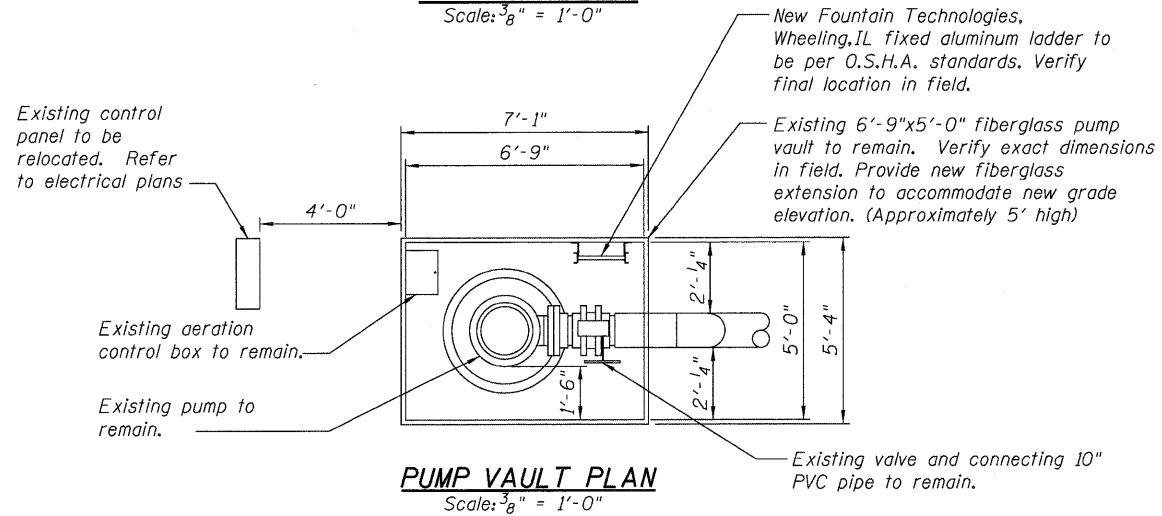


PUMP VAULT PLAN
Scale: 3/8" = 1'-0"

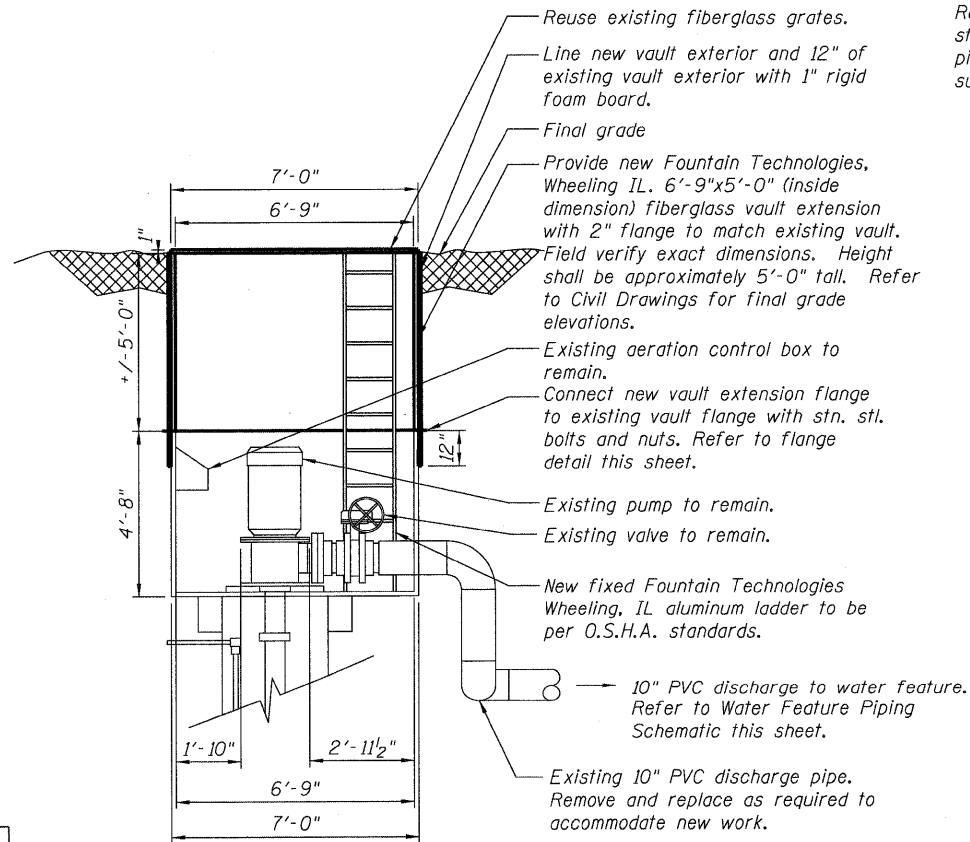


PUMP VAULT SECTION
Scale: 3/8" = 1'-0"

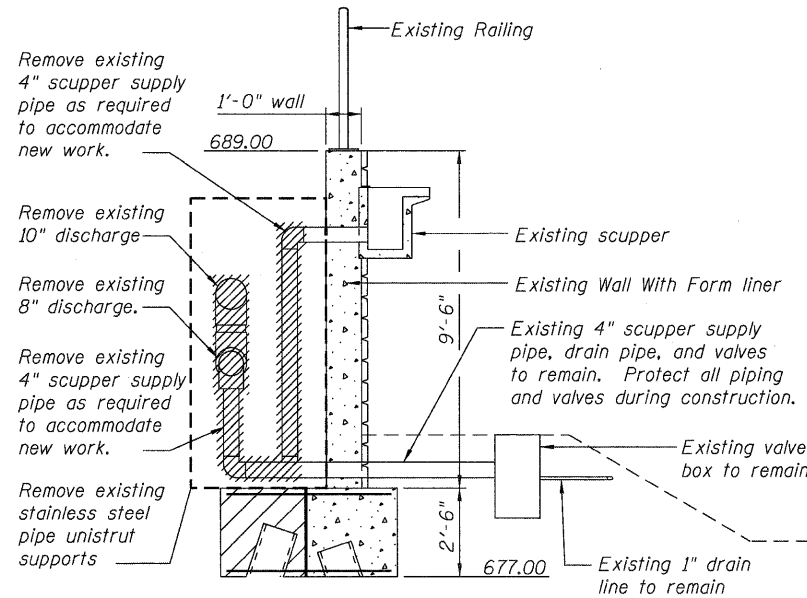

EXISTING WATER FEATURE PIPING DEMOLITION
TYPICAL OF 8
Scale: 3/8" = 1'-0"

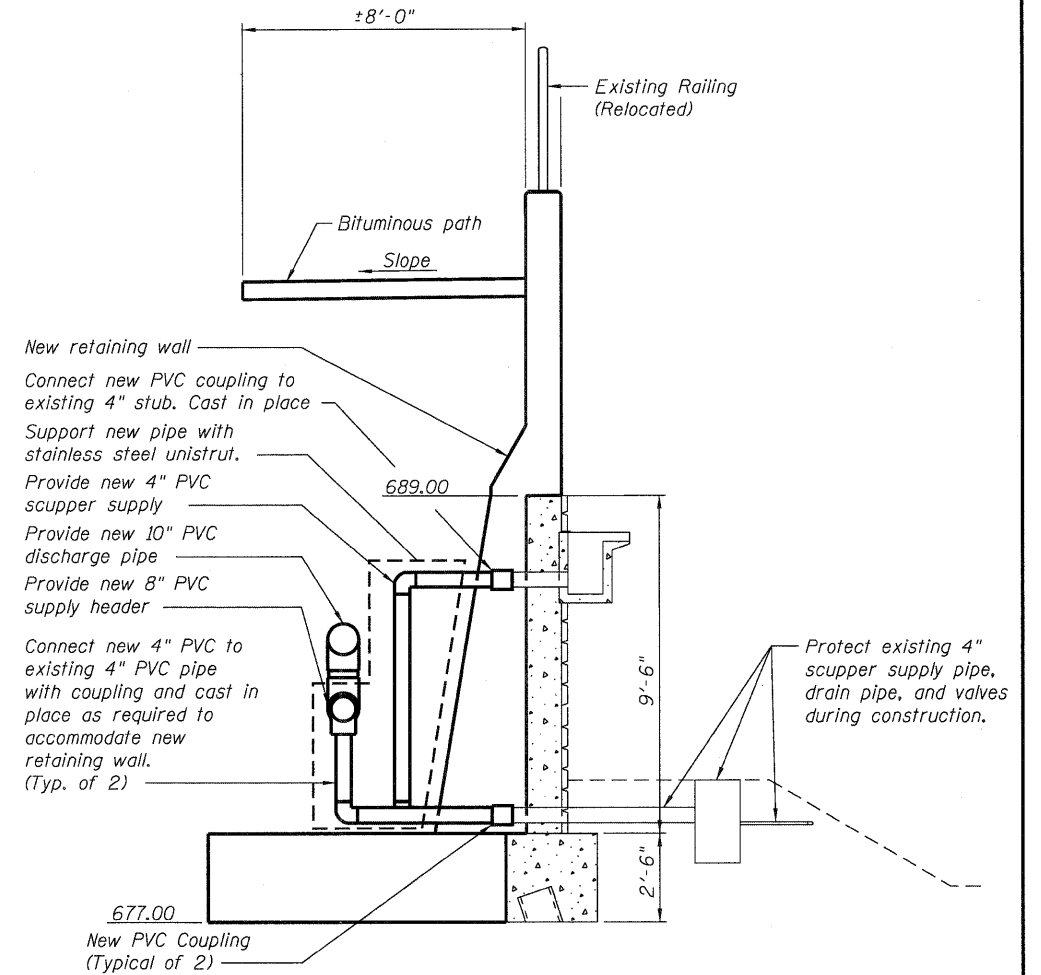

NEW WATER FEATURE PIPING
TYPICAL OF 8
Scale: 3/8" = 1'-0"

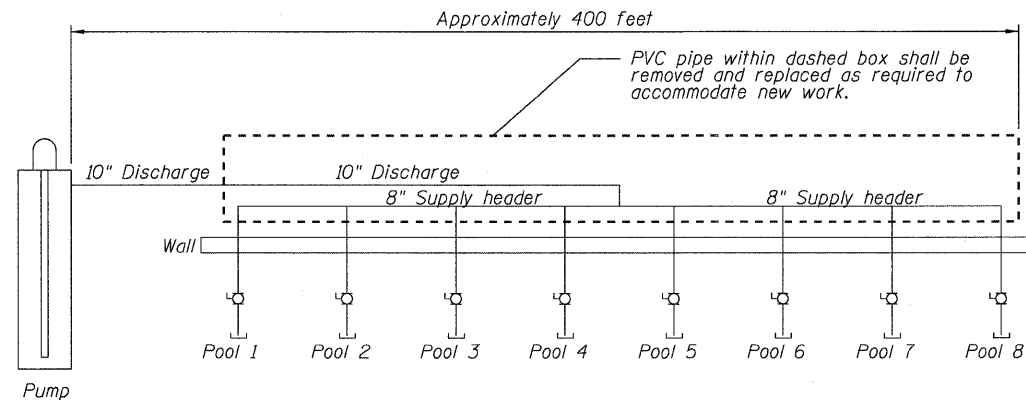

WATER FEATURE PIPING SCHEMATIC
Scale: Not to Scale

DESIGNED	WMC
CHECKED	APF
DRAWN	WMC
CHECKED	APF

WATER FEATURE REVISIONS

SHEET NO. 12	F.A.P RTE.	SECTION	COUNTY	TOTAL SHEETS	SHEET NO.
	330	73 R-B	COOK	136	101
23 SHEETS	CONTRACT NO. 60K64		DATE: 12/17/10 ILLINOIS FED. AID PROJECT		

McDonough Associates Inc.
Engineers / Architects
130 East Randolph Street Chicago, Illinois 60601