
 



 





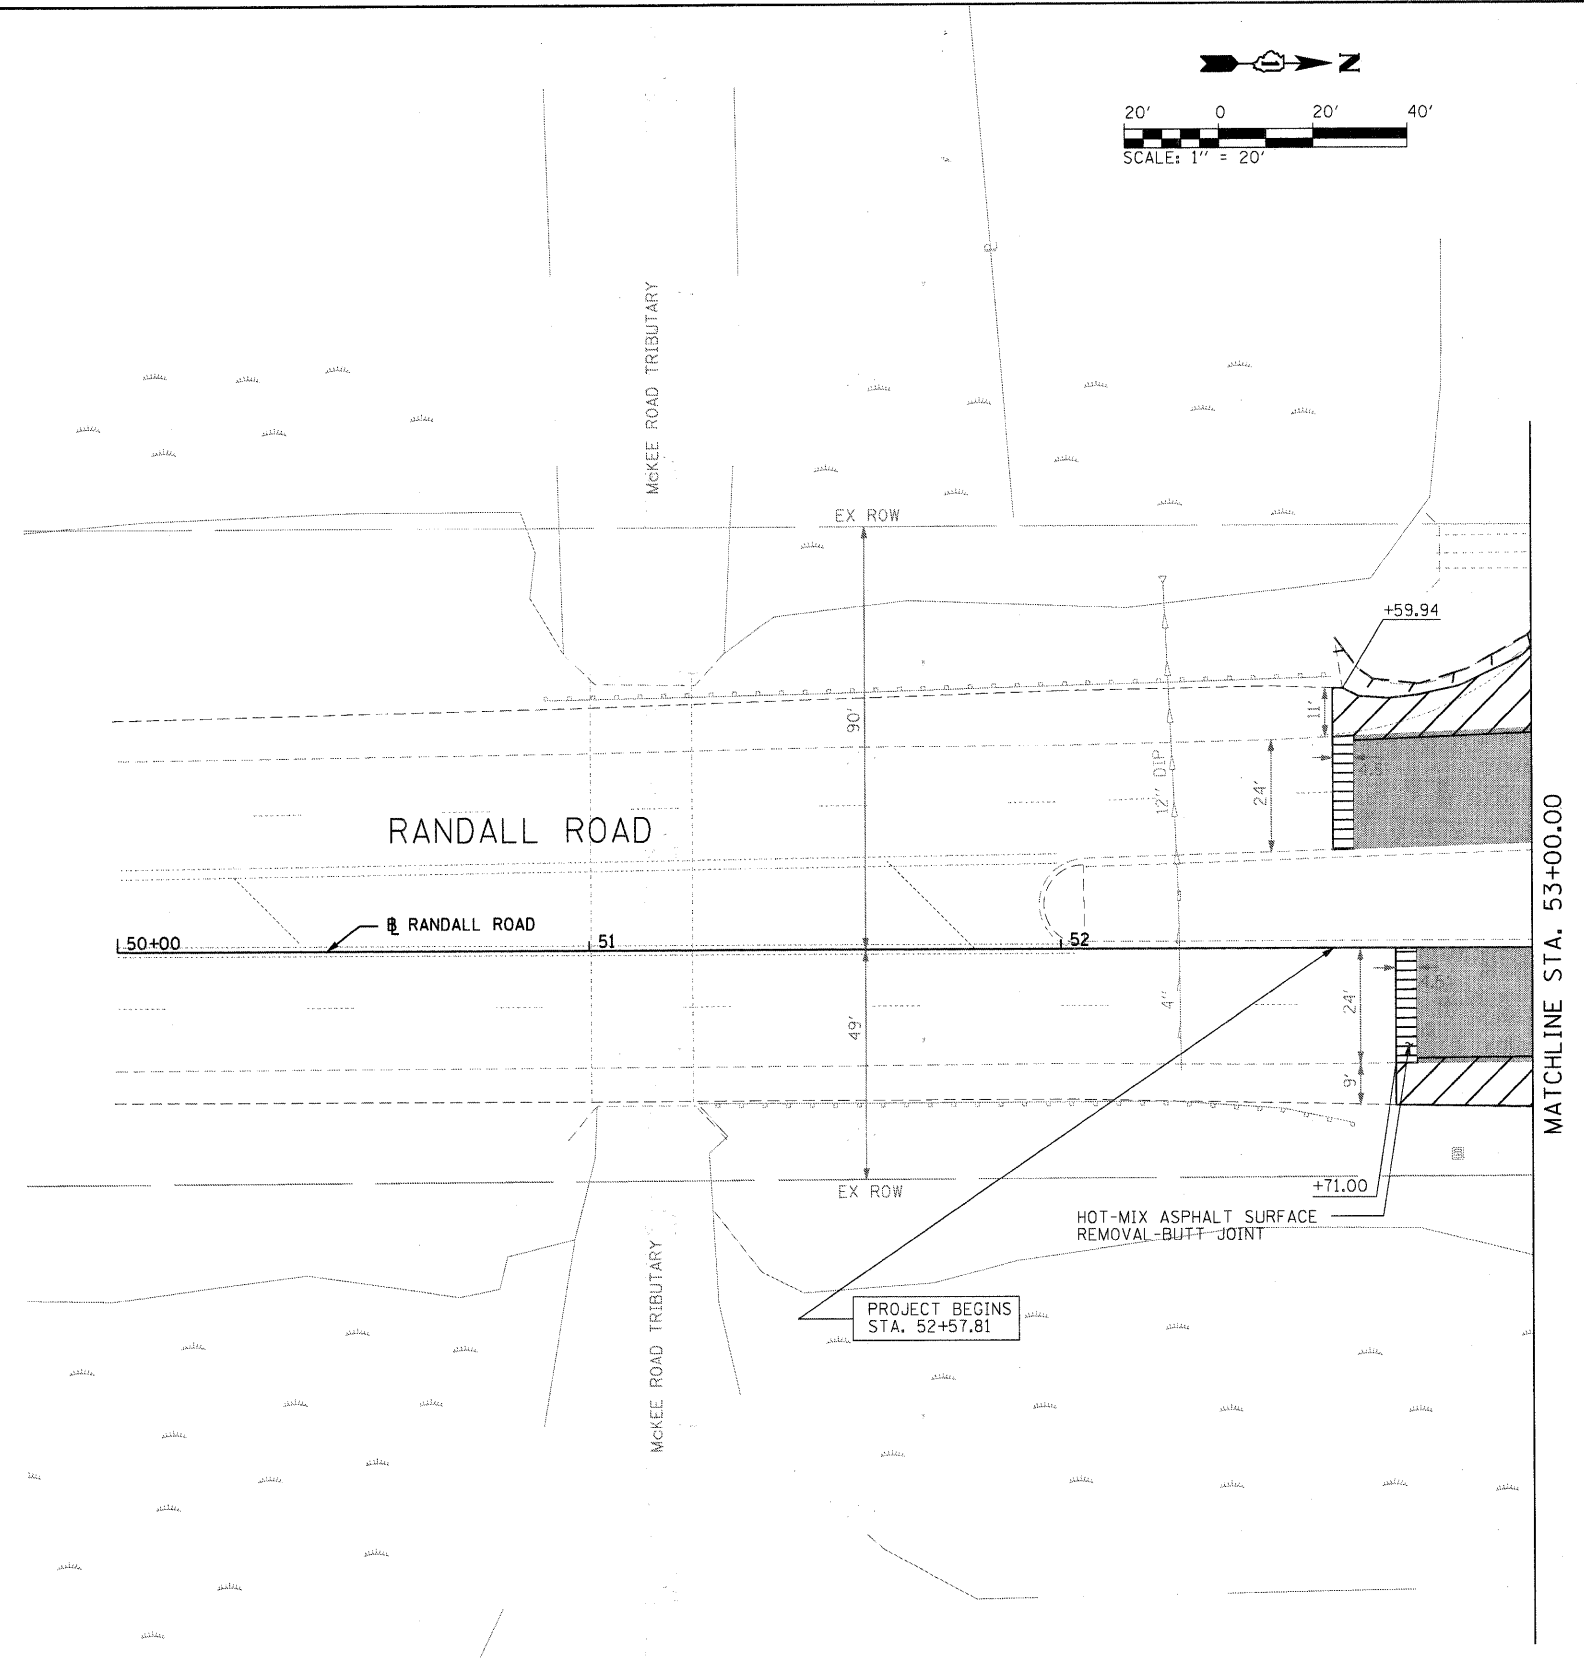


NOTES:

1. HOT-MIX ASPHALT SHOULDERS TO BE REMOVED SHALL BE CONSIDERED PART OF THE ROADWAY PAVEMENT AND WILL BE PAID FOR AS PAVEMENT REMOVAL (ITEM NO. 44000100).
2. FULL DEPTH SAWCUT CONSTRUCTION JOINTS SHALL BE PROVIDED FOR PAVEMENT REMOVAL. THE COST FOR SAWCUT SHALL BE INCLUDED WITHIN THE COST FOR PAVEMENT REMOVAL (ITEM NO. 44000100).
3. SEE TEMPORARY TRAFFIC SIGNAL PLANS FOR REMOVAL OF EXISTING SIGNAL EQUIPMENT AND POLES.
4. SEE GENERAL NOTES FOR LIST OF UTILITY COMPANY CONTACTS WHEN COORDINATING CONSTRUCTION WITH UTILITY COMPANIES.
5. ALL RAISED REFLECTIVE PAVEMENT MARKERS ON EXISTING PAVEMENT SHALL BE REMOVED PRIOR TO HMA SURFACE REMOVAL AND PAVEMENT REMOVAL.
6. EXISTING ROADWAY LIGHTING CONTROLLER, ROADWAY LIGHTING HANDHOLES AND ELECTRIC SERVICE SHALL BE REMOVED. REFER TO ELECTRICAL LIGHTING PLANS FOR SEQUENCE OF REMOVALS. EXISTING SERVICE CONDUCTORS SHALL BE REMOVED AND CONDUIT SHALL BE ABANDONED IN PLACE.
7. REFER THE THE ALIGNMENT, TIES & BENCHMARK SHEET FOR INTERSECTION ALIGNMENT INFORMATION.

LEGEND:

-  HOT-MIX ASPHALT SURFACE REMOVAL VARIABLE DEPTH
-  PAVEMENT REMOVAL (44000100)
-  ISLAND AND MEDIAN REMOVAL PAID FOR AS MEDIAN REMOVAL
-  SIDEWALK REMOVAL
-  HOT-MIX ASPHALT SURFACE REMOVAL BUTT JOINT
-  COMBINATION CONCRETE CURB AND GUTTER REMOVAL
- XXX TREE / STORM SEWER / SIGN REMOVAL
-  FRAMES AND GRATES TO BE ADJUSTED (60300105)
-  ADJUST FRAME AND LID
-  REMOVE
-  EXISTING WETLAND, DO NOT DISTURB
-  WETLAND IMPACT AREA



FILE NAME = I:\hennico\02292833\rdm\acadd\sheet\AP.REM.B1.dgn

| | | | | | | | | | | | | |
|--|-------------------------------|-------------------|-----------|---|--|-----------------|-------------------------|--------------------------------|---------------------------|--------------|--|--|
|  <p>CMT CRAWFORD, MURPHY & TILLY, INC. CONSULTING ENGINEERS License No. 084-000813</p> | USER NAME = Matt Baldwin | DESIGNED - PWK | REVISED - | <p>STATE OF ILLINOIS DEPARTMENT OF TRANSPORTATION</p> | <p>RANDALL ROAD ROADWAY REMOVAL PLAN</p> | F.A.P. RTE. 336 | SECTION 01-00269-00-CH | COUNTY KANE | TOTAL SHEETS 124 | SHEET NO. 15 | | |
| | PLOT SCALE = 20,000.00' / IN. | CHECKED - KDF | REVISED - | | | SCALE: 1"=20' | SHEET NO. 1 OF 6 SHEETS | STA. 50+00.00 TO STA. 53+00.00 | ILLINOIS FED. AID PROJECT | | | |
| | PLOT DATE = 12/29/2010 | DATE - 12/29/2010 | REVISED - | | | | | | | | | |
| | CONTRACT NO. 63533 | | | | | | | | | | | |