




DATE	
BY	
PLAN	SUBMITTED
	ALIGNED
	NOTED
	NO.

DATE	
BY	
PROFILE	GRADES CHECKED
	BLM. NOTED
	NO.

FILE NAME = J:\keneco\929803.dwg
 J:\keneco\929803.dwg\cadd\sheets\1R_DR_02.dwg

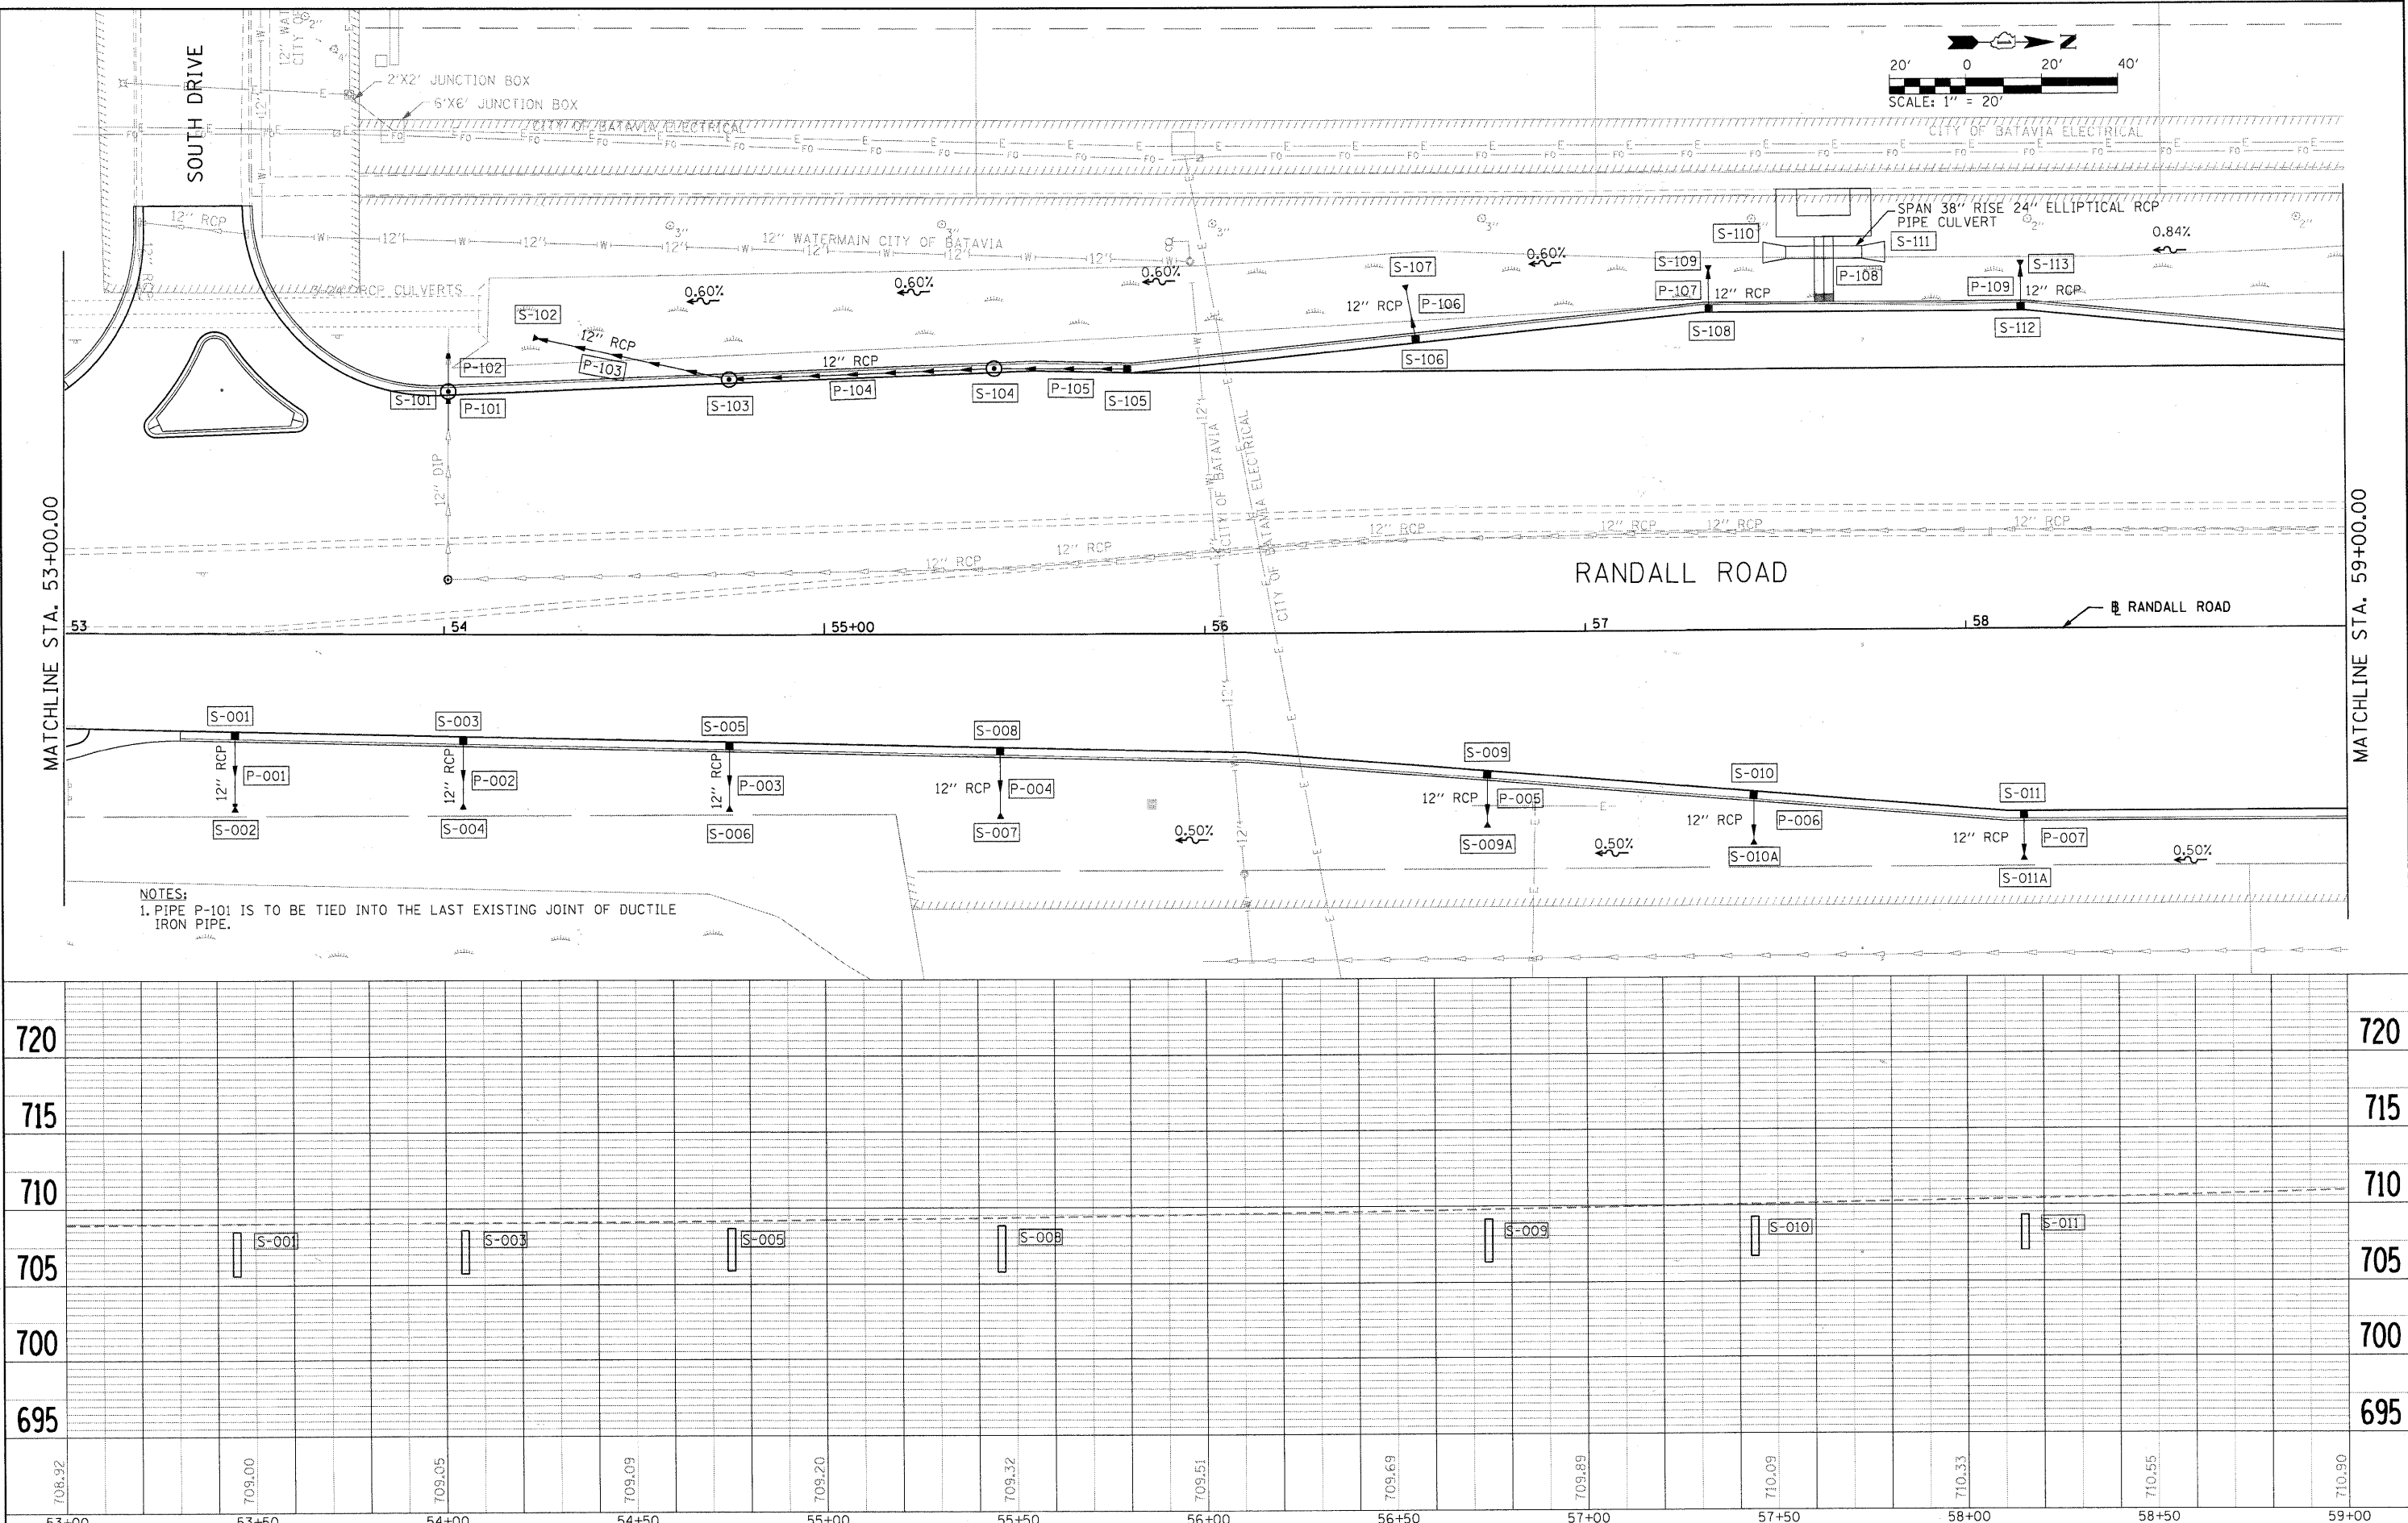

 NOTES:
 1. PIPE P-101 IS TO BE TIED INTO THE LAST EXISTING JOINT OF DUCTILE IRON PIPE.

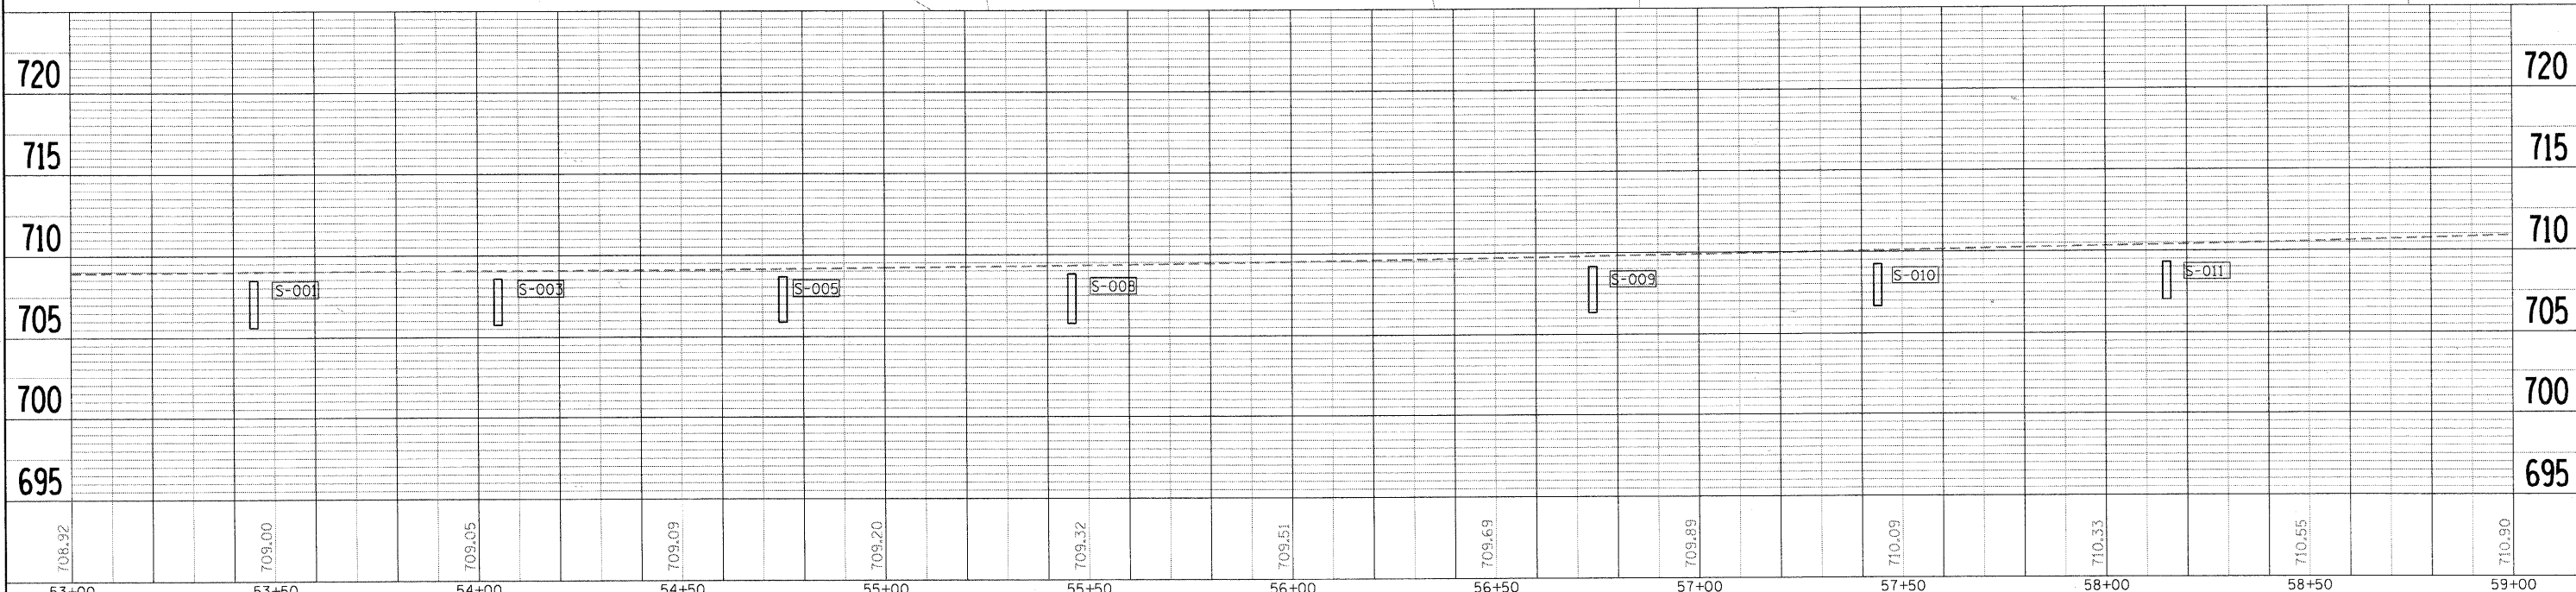

DESIGNED - PWK	REVISD -	STATE OF ILLINOIS DEPARTMENT OF TRANSPORTATION	DRAINAGE AND UTILITY PLAN		F.A.P. RTE. 336	SECTION 01-00269-00-CH	COUNTY KANE	TOTAL SHEETS 124	SHEET NO. 45	
DRAWN - ERD	REVISD -		SCALE: 20'H 5'V SHEET NO. 2 OF 6 SHEETS STA. 53+00.00 TO STA. 59+00.00		CONTRACT NO. 63533					
CHECKED - KDF	REVISD -		ILLINOIS FED. AID PROJECT							
PLOT DATE = 12/29/2010	DATE = 12/29/2010									