


LIGHTING PLAN

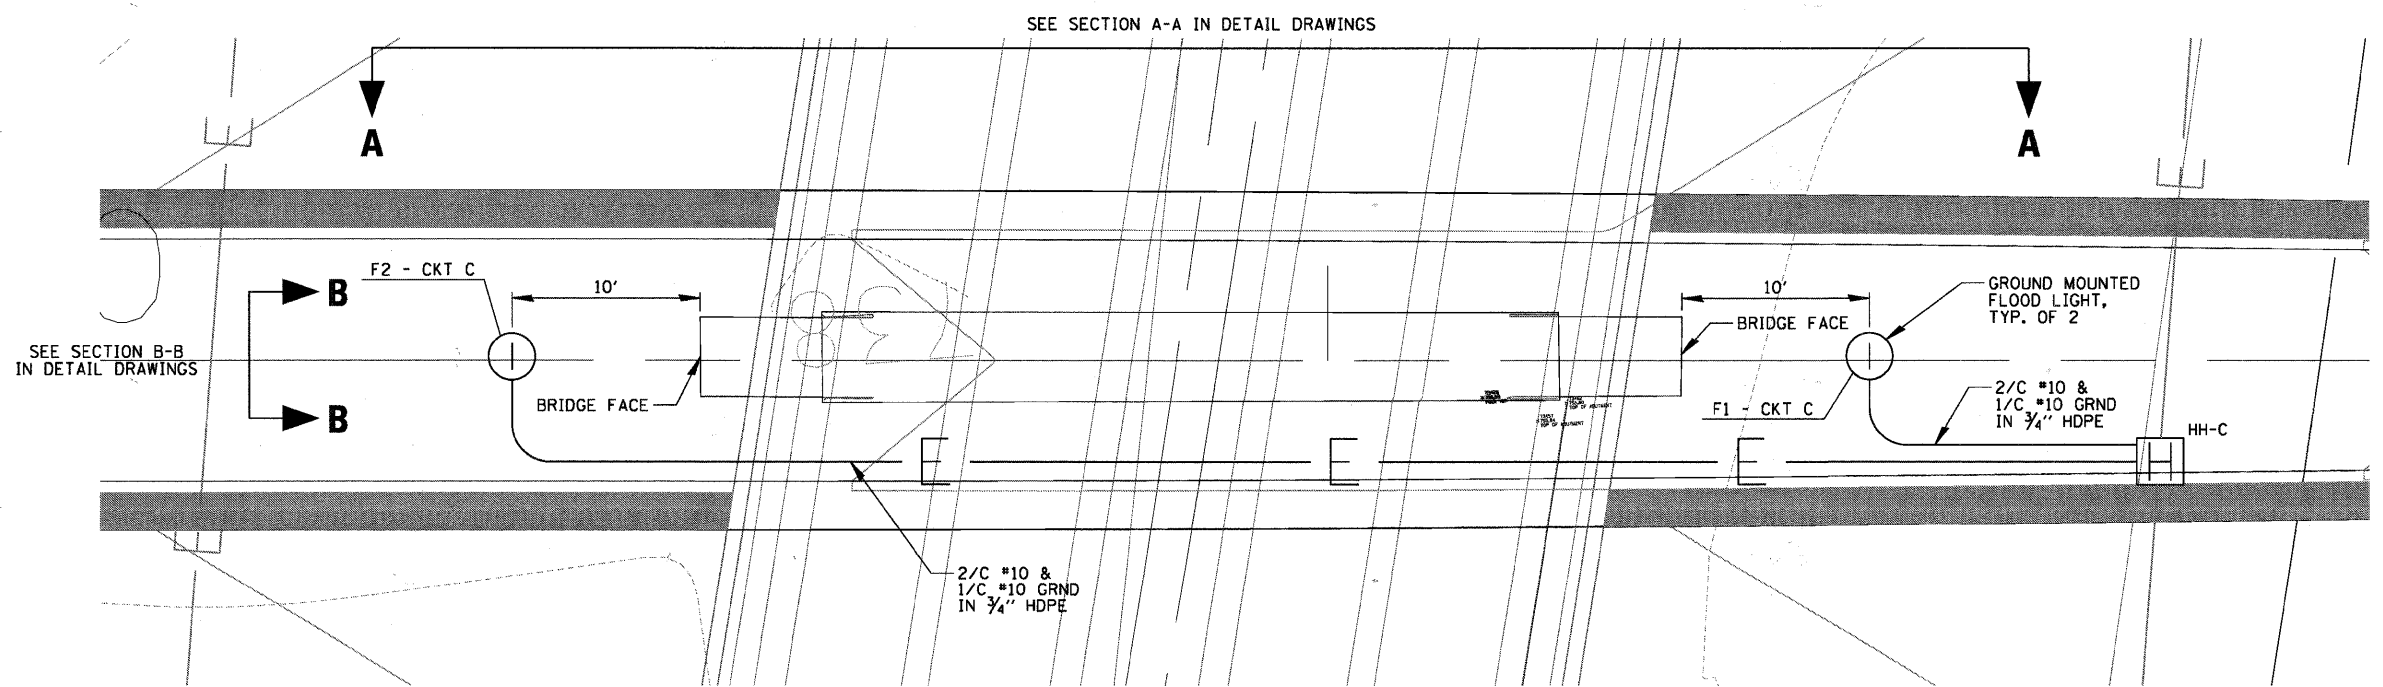

ENLARGED LIGHTING PLAN
N.T.S.

FILE NAME = P:\CBBEL WEST Proj\elects\2009\09-02\2 CAD\G.v1\LDgn\Shht\ELECT-2.dgn

WILLS BURKE KELSEY ASSOCIATES LTD.
110 West Main Street, Suite 201
St. Charles, Illinois 60174
(630) 443-7755

USER NAME = #USER#	DESIGNED - KWB	REVISED -
PLOT SCALE = AS SHOWN	DRAWN - AJD	REVISED -
PLOT DATE = 12/17/2010	CHECKED -	REVISED -
	DATE - 12/17/10	REVISED -

STATE OF ILLINOIS
DEPARTMENT OF TRANSPORTATION

STEARNS ROAD /RTE 31 BRIDGE	
LIGHTING PLAN	
SCALE: AS SHOWN	SHEET NO. 76 OF 80 SHEETS
STA. _____	TO STA. _____

F.A.P. RTE. 361	SECTION 09-00214-02-LS	COUNTY KANE/DUPAGE	TOTAL SHEETS 80	SHEET NO. 76
CONTRACT NO. 63542				
FED. ROAD DIST. NO. 1 ILLINOIS FED. AID PROJECT				