

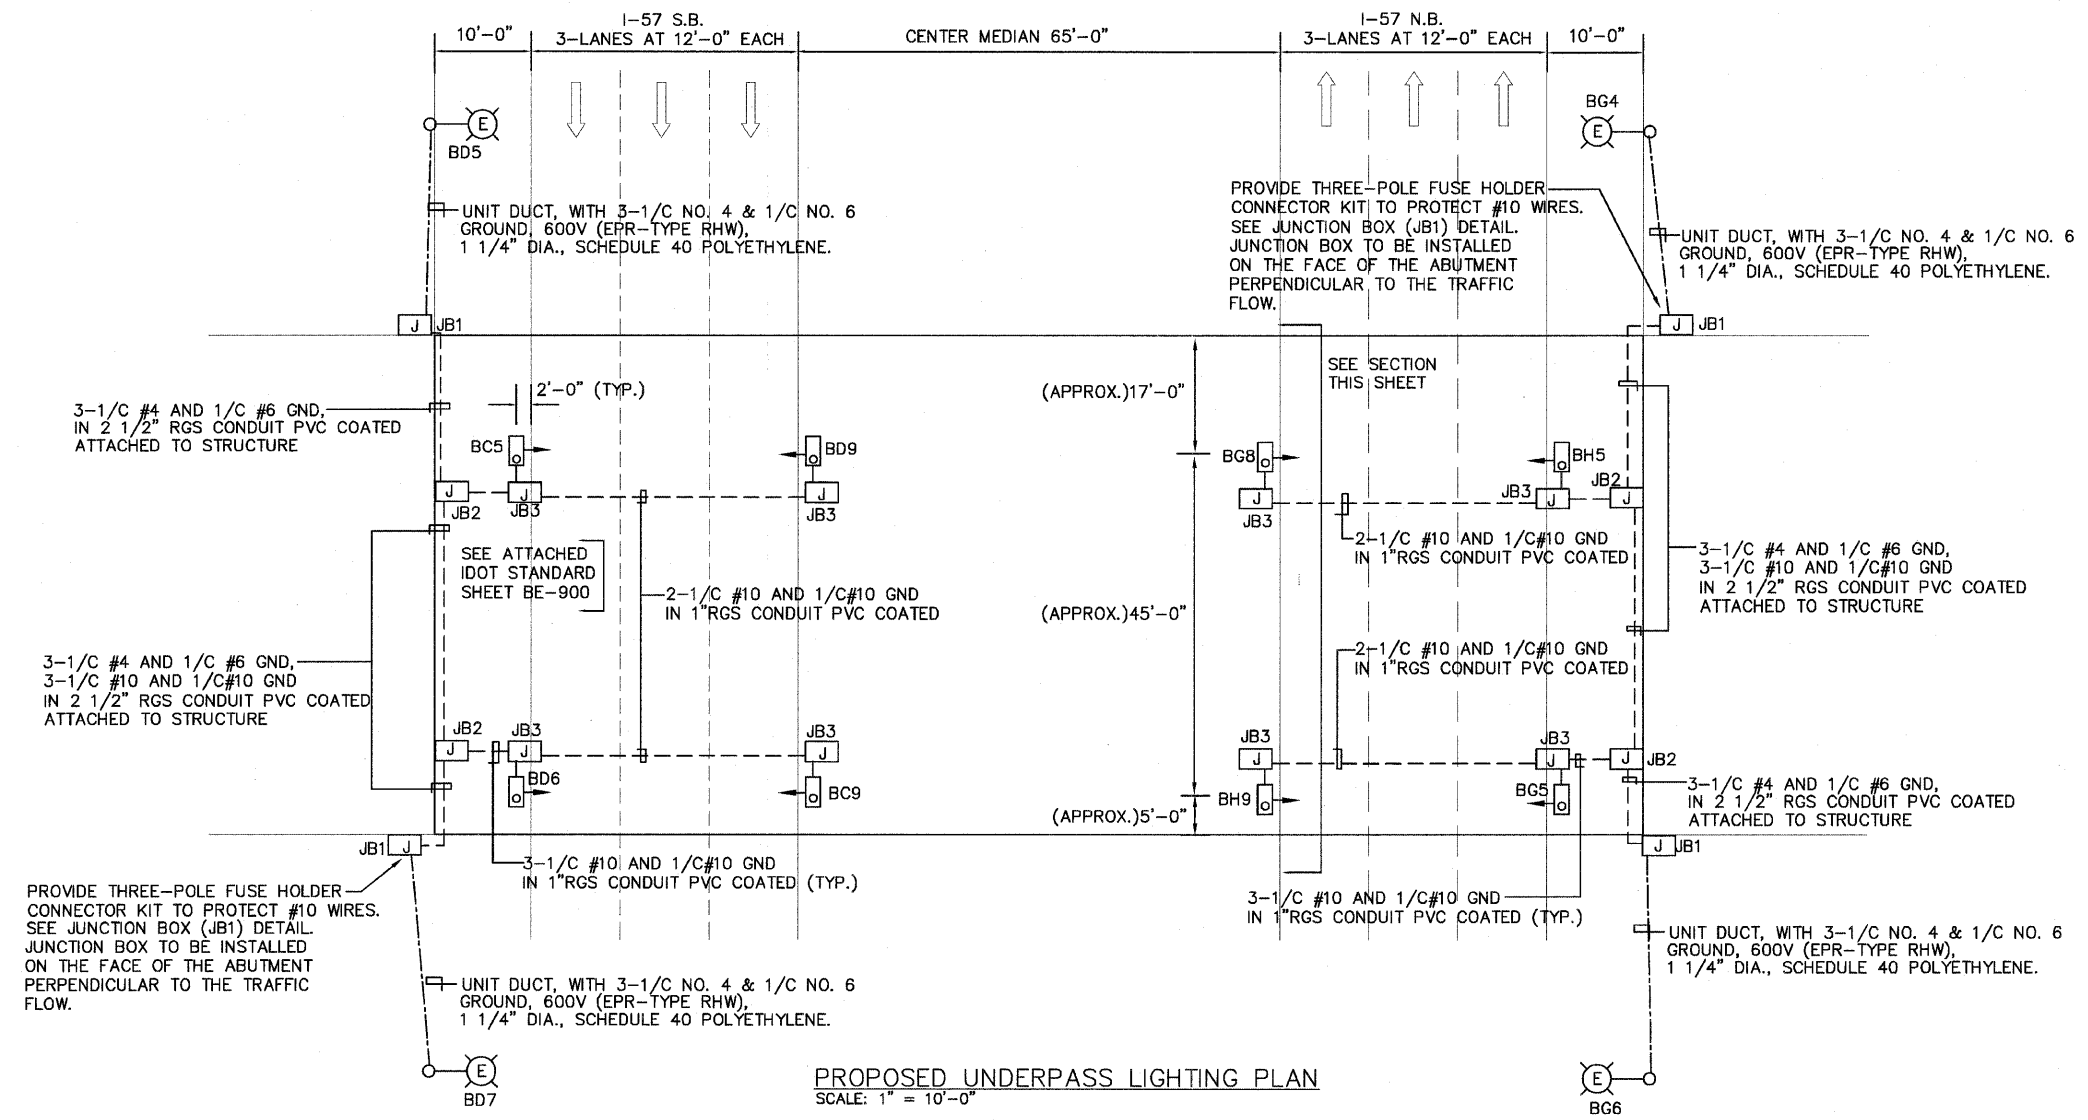


F.A.I. RTE.	SECTION	COUNTY	TOTAL SHEETS	SHEET NO.
57	2122-B	COOK	75	21
STA.	TO STA.			
FED. ROAD DIST. NO.	ILLINOIS	FED. AID PROJECT		
CONTRACT NO. 60366				

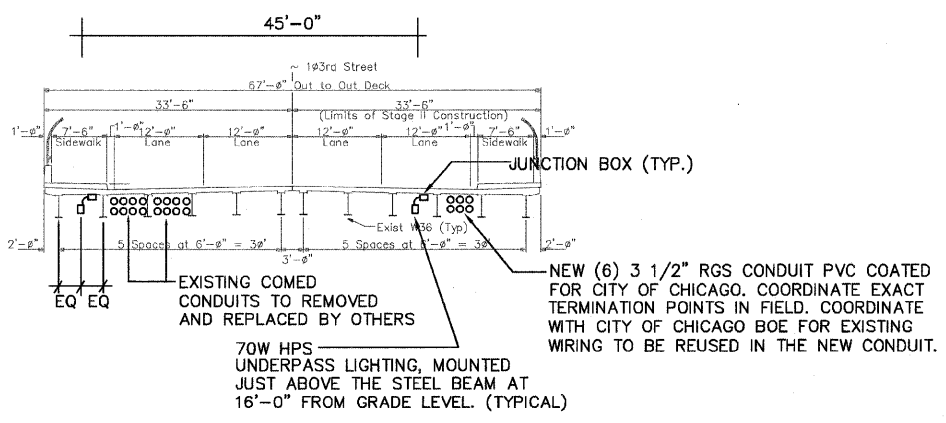

LEGEND


- RIGID GALVANIZED STEEL CONDUIT, PVC COATED
- UNIT DUCT, 3'-0" BELOW GRADE
- [J] STAINLESS STEEL JUNCTION BOX ATTACHED TO STRUCTURE
- [O] UNDERPASS LIGHTING LUMINAIRE, 70W HPS, MOUNTED AT 16'-0" FROM GRADE, CIRCUIT NUMBER AS NOTED
- [E] EXISTING LIGHTING UNIT AND POLE TO REMAIN
- LIGHTING UNIT NUMBER
- CIRCUIT NAME
- LIGHTING CONTROLLER NAME

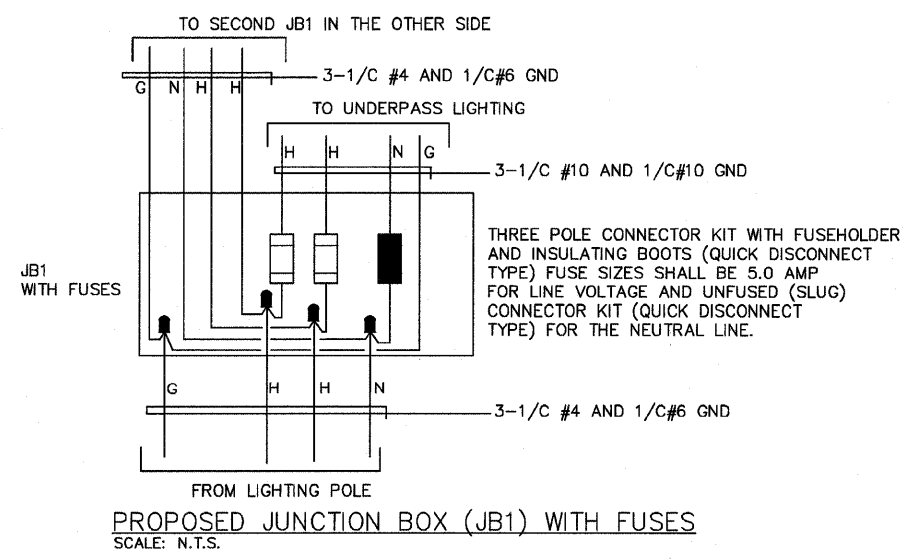

JUNCTION BOX SCHEDULE			
NO.	SIZE	DESCRIPTION	QUANTITY
JB1	16 X 14 X 6	SS JUNCTION BOX	4
JB2	12 X 10 X 6	SS JUNCTION BOX	4
JB3	6 X 6 X 4	SS JUNCTION BOX	8

Advance
Consulting Group International

 330 W. ADAMS ST.
SUITE 409
CHICAGO, IL 60606
TEL: 312-487-1940
FAX: 312-357-1945
Web Site: www.aggint.com



REVISIONS	
NAME	DATE

ILLINOIS DEPARTMENT OF TRANSPORTATION

103RD STREET
BRIDGE OVER FAI 57 (DAN RYAN)
PROPOSED UNDERPASS
LIGHTING PLAN

DATE 01-16-08

DRAWN BY EHE
CHECKED BY EE