


F.A.I. RTE.	SECTION	COUNTY	TOTAL SHEETS	SHEET NO.
90	1213B-1	COOK	94	27
STA.		TO STA.		
FED. ROAD DIST. NO. 1		ILLINOIS FED. AID PROJECT		
CONTRACT NO. 60640				

CONSTRUCTION NOTES:

1. THE EXISTING LIGHTING CONTROLLER "CABINET 1" FOR THE UNDERPASS LIGHTING IS LOCATED 366 METERS EAST OF CENTRAL AVENUE ON THE SOUTH SIDE OF THE EXPRESSWAY.

2. THE COST OF THE REMOVAL OF THE EXISTING CABLE, RGS CONDUIT AND JUNCTION BOXES SHALL BE INCLUDED IN THE "REMOVAL OF EXISTING SUPERSTRUCTURES" PAY ITEM.

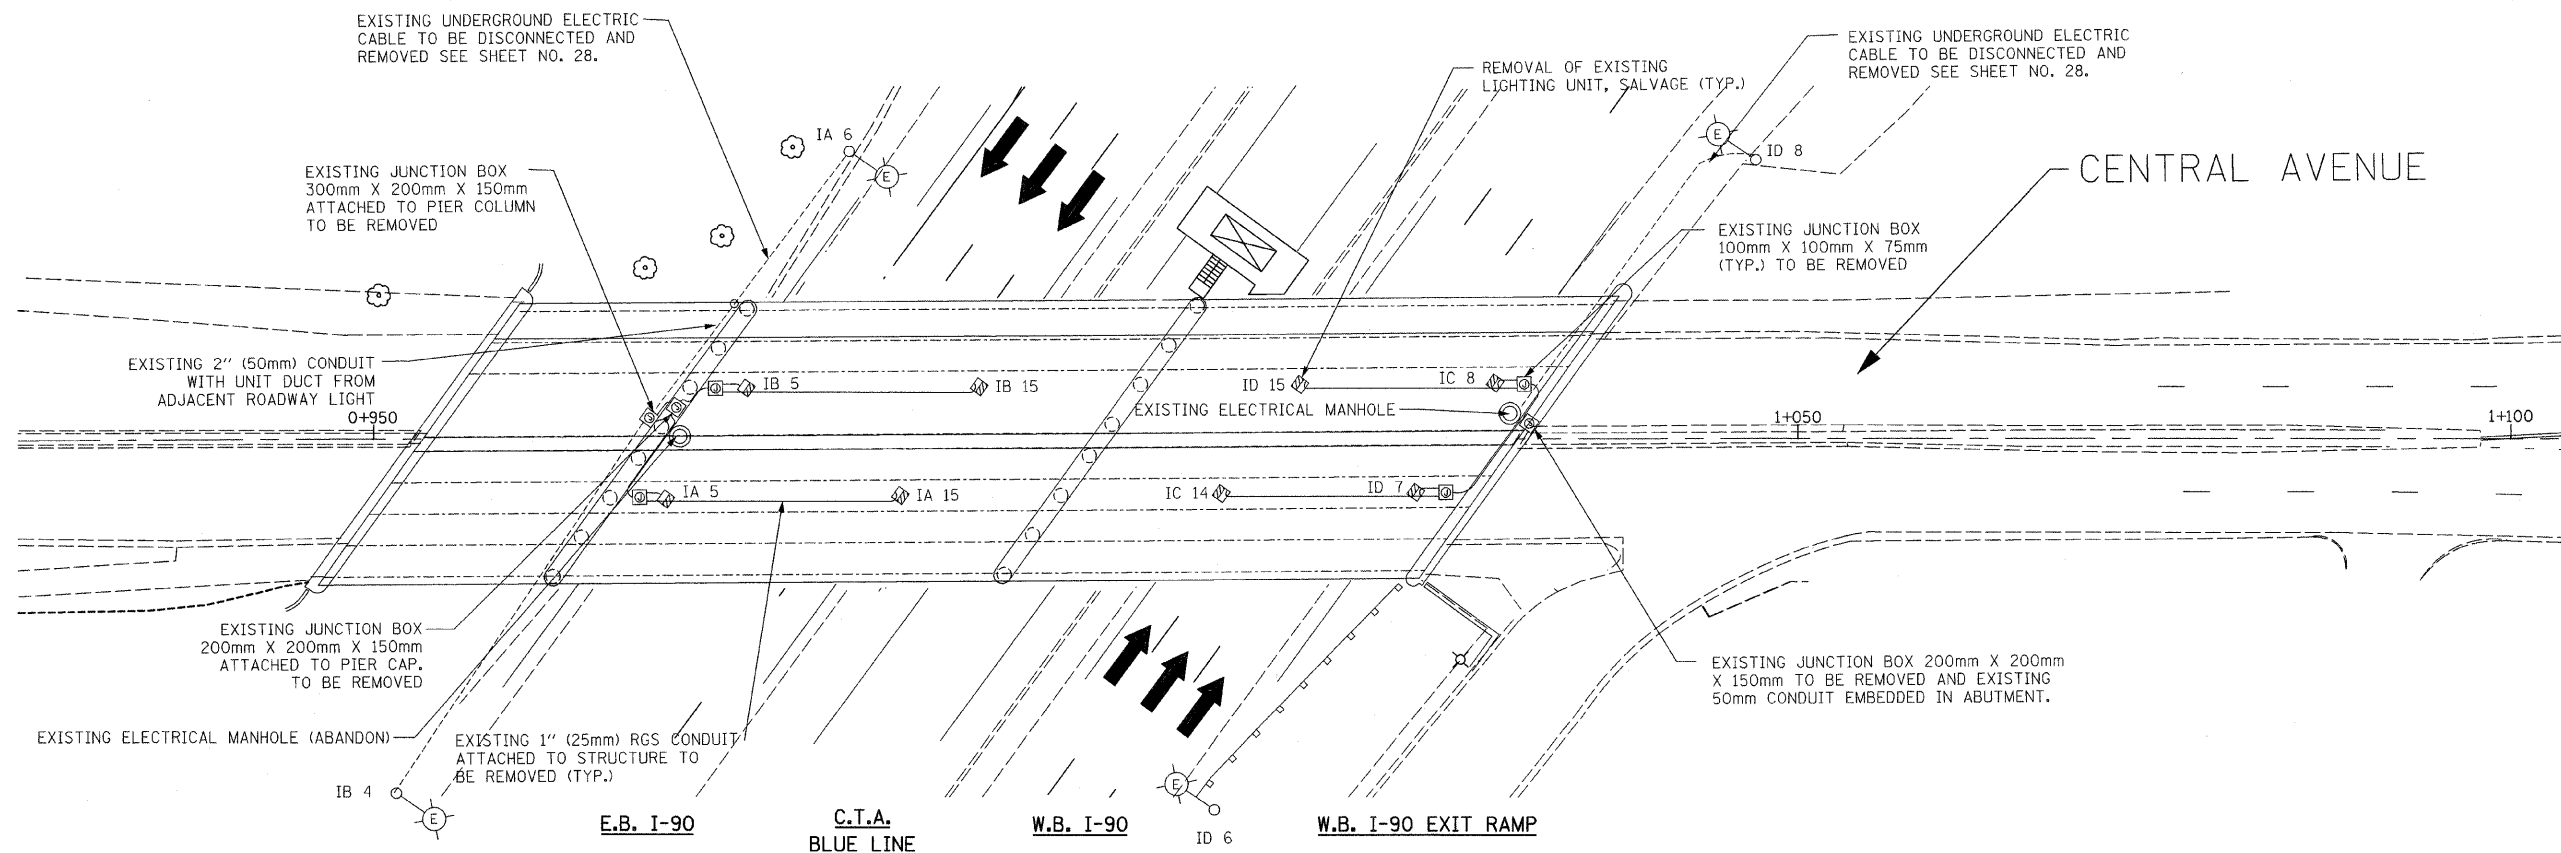

FOR LEGEND SEE SHEET NO. 26.

REVISIONS	
NAME	DATE

ILLINOIS DEPARTMENT OF TRANSPORTATION
REMOVAL PLAN
 I.D.O.T. EXISTING LIGHTING PLAN
 I-90 BRIDGE UNDERPASS
 AT CENTRAL AVENUE

SCALE: NONE
 DATE: NOVEMBER 2007
 DRAWN BY: P.J.B.
 CHECKED BY: S.J.P.

CR & A
 CHRISTIAN-ROGE & ASSOCIATES, INC.
 ENGINEERS-PLANNERS-SURVEYORS
 211 WEST WACKER DRIVE
 CHICAGO, ILLINOIS 60606
 1-312-372-2023 FAX: 1-312-372-5274