


PLAN	SURVEYED	DATE
	PLOTTED	
	NOTED	
	BY	
	NO.	
	FILE NAME	

**DRAINAGE LEGEND:**

- DRAINAGE STRUCTURE NUMBER
- STORM SEWER NUMBER
- DRAINAGE STRUCTURE ADJUSTMENT
- STORM SEWER WITH CASING PIPE
- 4" PIPE UNDERDRAIN

PROFILE	SURVEYED	DATE
	PLOTTED	
	NOTED	
	BY	
	NO.	
	FILE NAME	

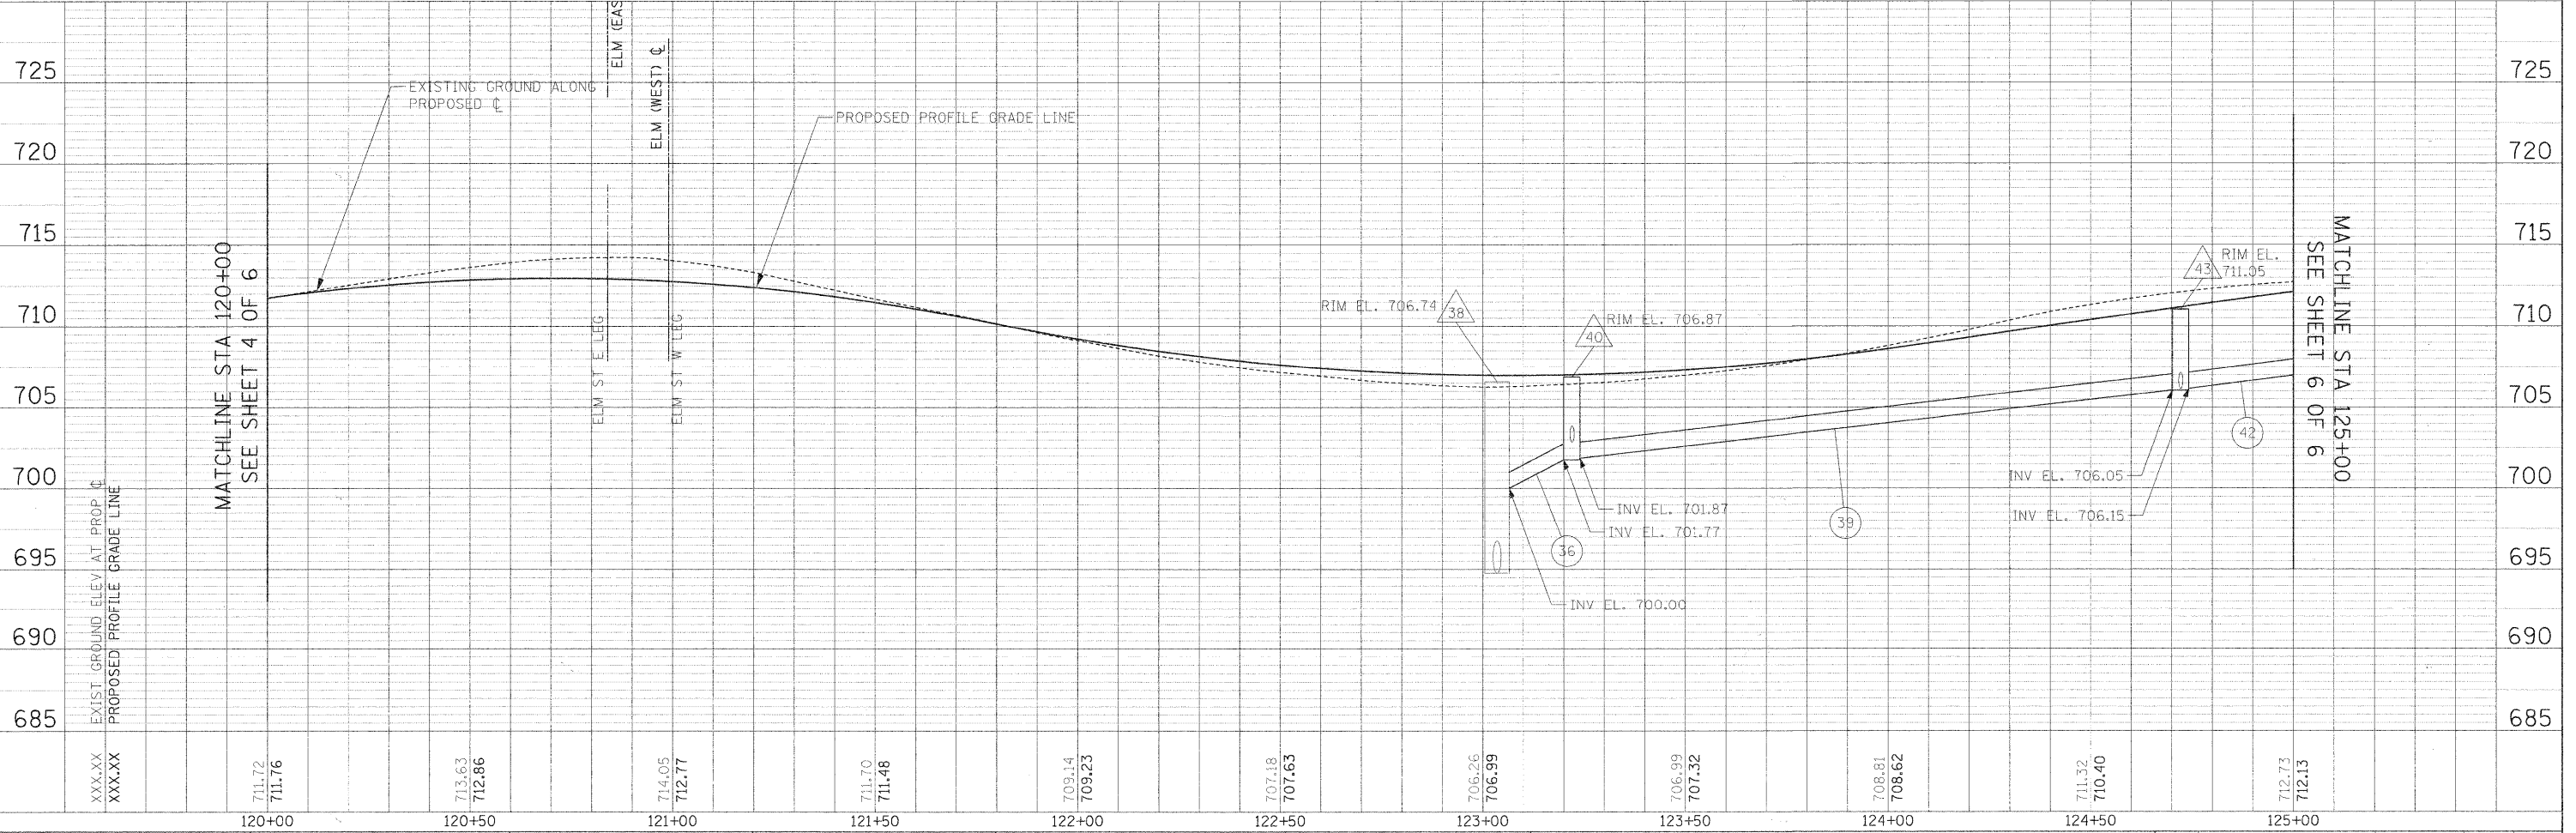

FILE NAME #	USER NAME # USER#	DESIGNED - AJB	REVISED -	<b>STATE OF ILLINOIS DEPARTMENT OF TRANSPORTATION</b>	<b>RIFORD ROAD DRAINAGE PLAN AND PROFILE</b>	F.A.U. RTEL	SECTION	COUNTY	TOTAL SHEETS	SHEET NO.	
#FILE#	PLLOT SCALE - #SCALE#	DRAWN - TMC	REVISED -			211	05-00068-00-FP	DUPAGE	141	53	
	PLLOT DATE - #DATE#	CHECKED - DEB	REVISED -			RIFORD ROAD RECONSTRUCTION		CONTRACT NO. 63092			
		DATE - 12/01/2009	REVISED -			SCALE: 1"=20'		SHEET NO. 5 OF 6 SHEETS STA. 120+00.00 TO STA. 125+00.00		FED. ROAD DIST. NO. 1 ILLINOIS FED. AID PROJECT	