
 
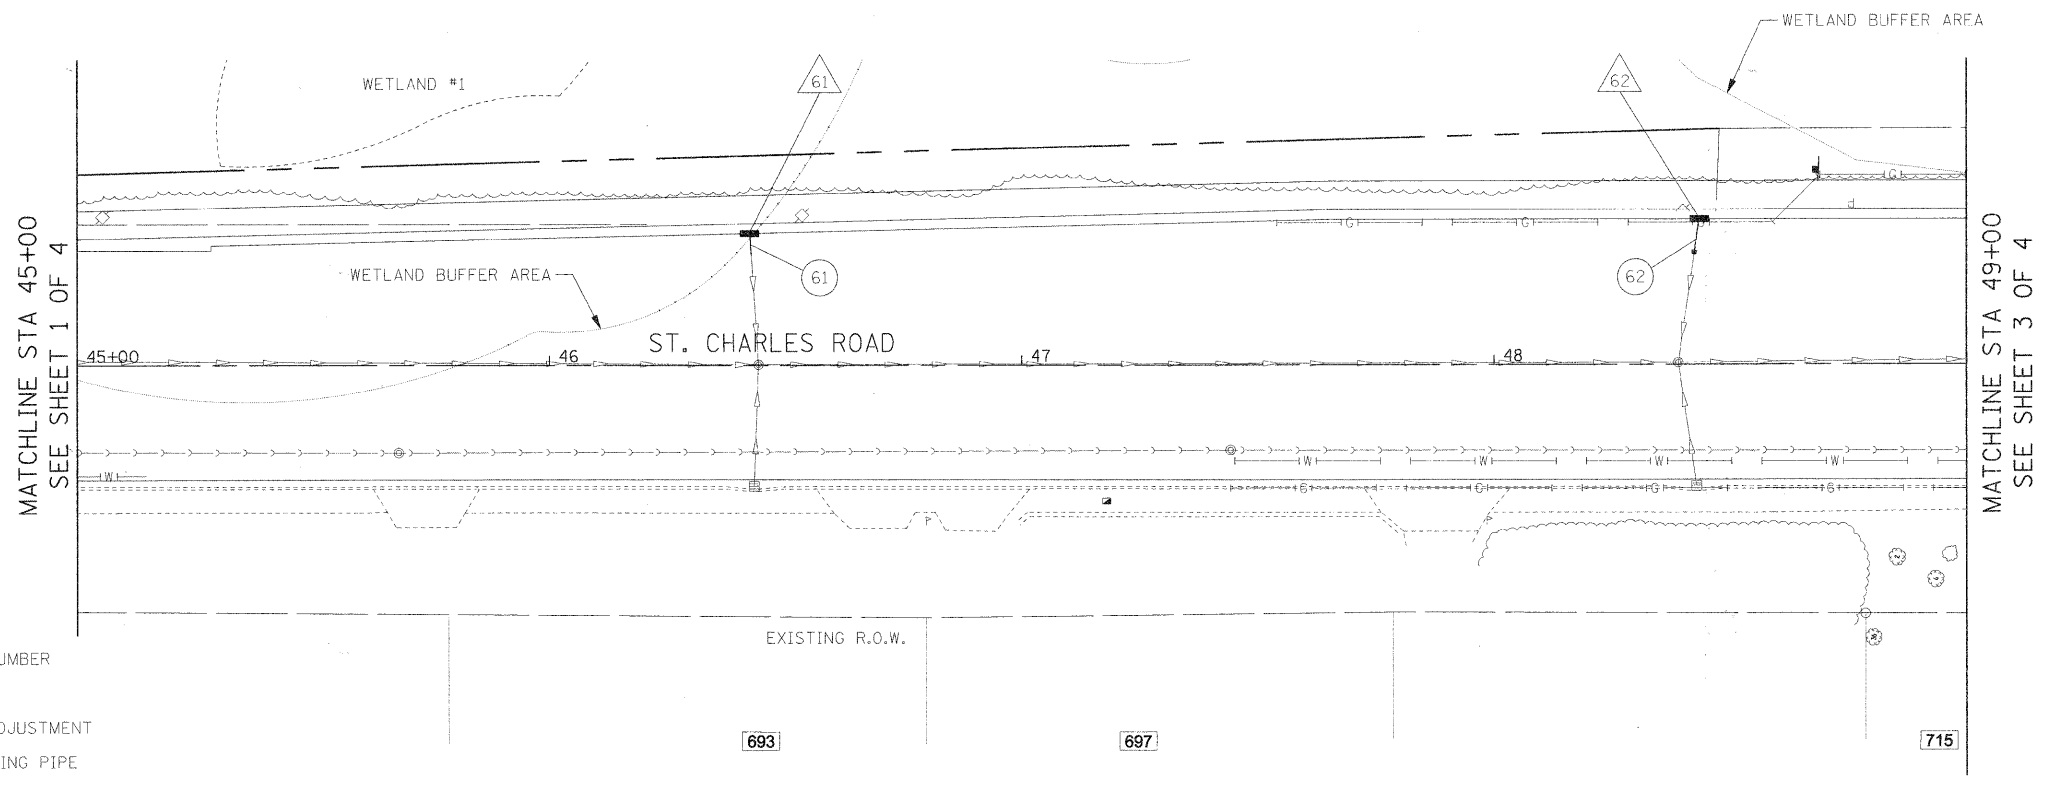


PLAN	SURVEYED	DATE
	PLOTTED	
	CHECKED	
	BY	
	NO. OF MAY CHECKED	
	CADD FILE NAME	
	NO.	

PROFILE	SURVEYED	DATE
	PLOTTED	
	CHECKED	
	BY	
	NO. OF MAY CHECKED	
	STRUCTURE NOTATIONS CPFD	
	NO.	



- DRAINAGE LEGEND:**
- DRAINAGE STRUCTURE NUMBER
  - STORM SEWER NUMBER
  - DRAINAGE STRUCTURE ADJUSTMENT
  - STORM SEWER WITH CASING PIPE
  - 4" PIPE UNDERDRAIN

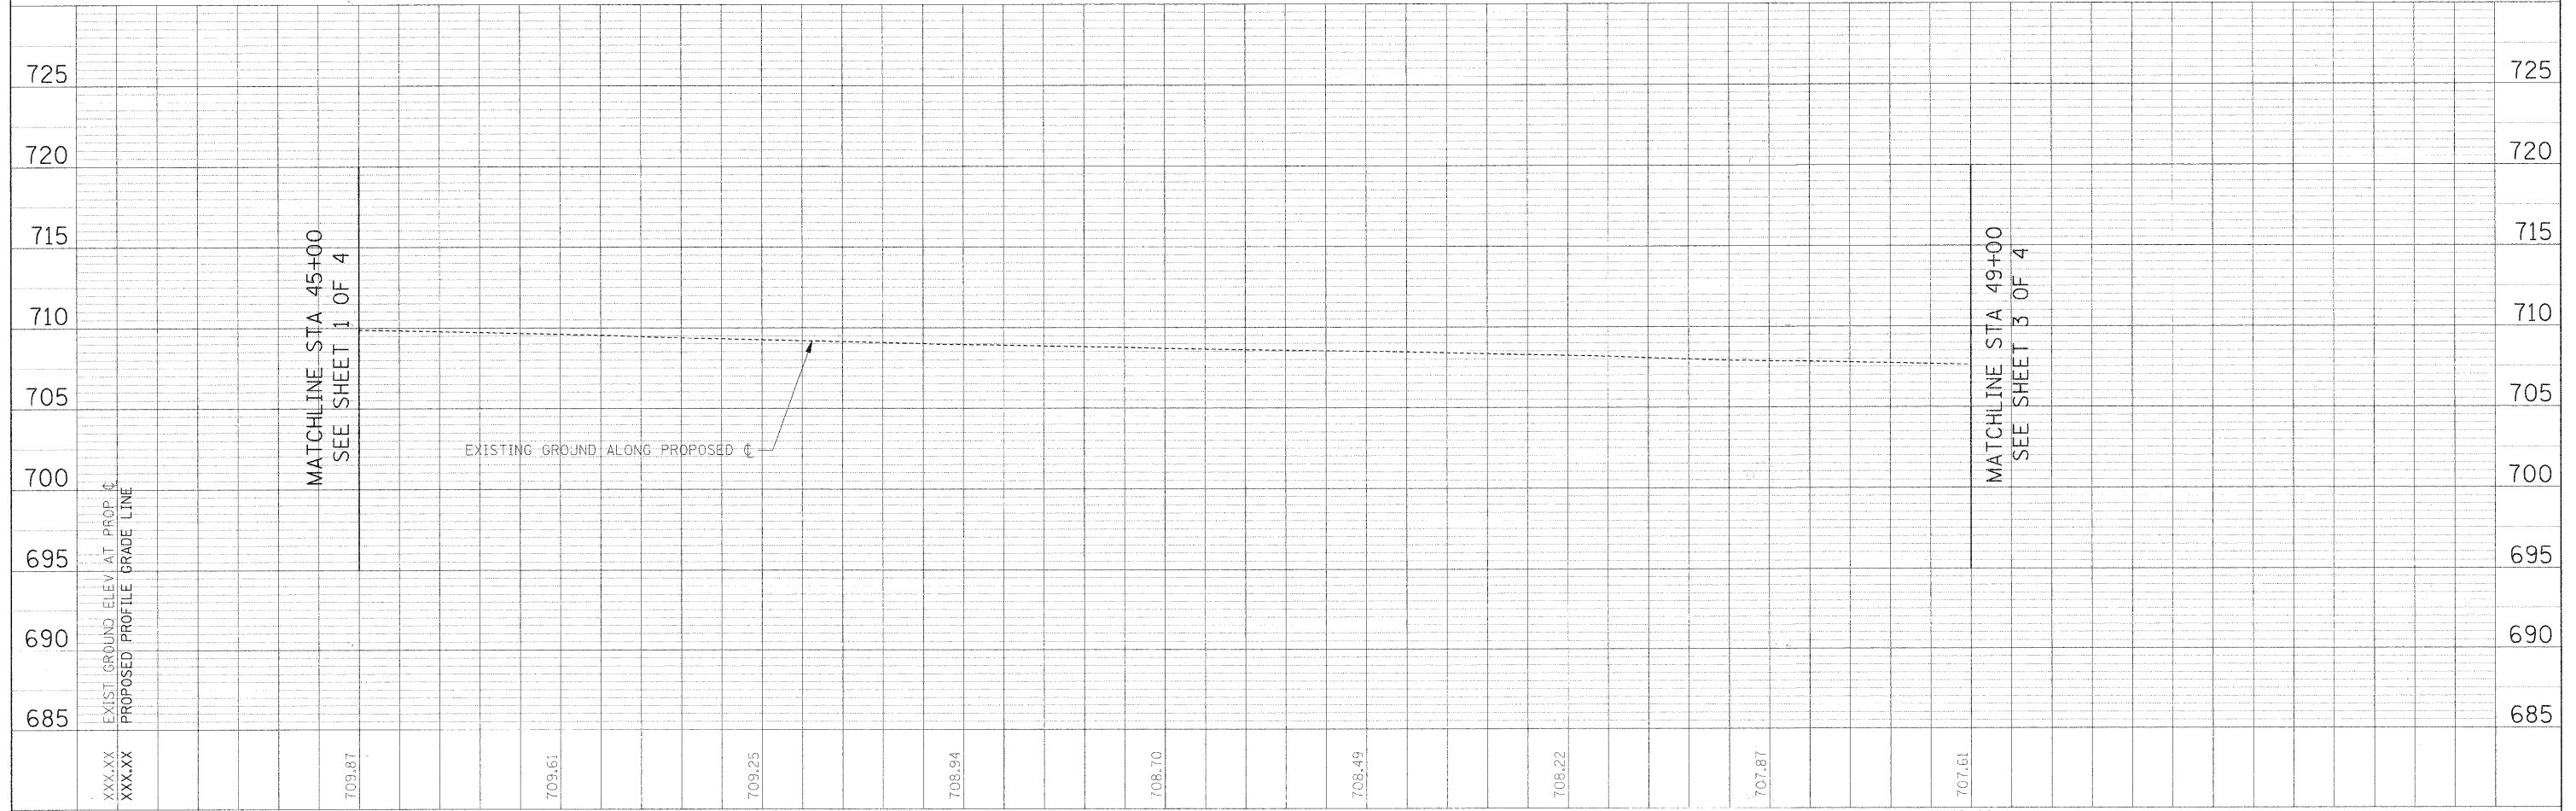

FILE NAME =	USER NAME = #USER#	DESIGNED - AJB	REVISED -	<b>STATE OF ILLINOIS DEPARTMENT OF TRANSPORTATION</b>	<b>ST. CHARLES ROAD DRAINAGE PLAN AND PROFILE</b>	F.A.U. RTE. 2199	SECTION 05-00068-00-FP	COUNTY DUPAGE	TOTAL SHEETS 141	SHEET NO. 56	
#FILE#	PLOT SCALE = #SCALE#	DRAWN - MAP	REVISED -			SCALE: 1"=20'	SHEET NO. 2 OF 4 SHEETS	STA. 45+00.00 TO STA. 49+00.00	CONTRACT NO. 63092		
	PLOT DATE = #DATE#	CHECKED - DEB	REVISED -			RIFORD ROAD RECONSTRUCTION					
		DATE - 12/01/2009	REVISED -			FED. ROAD DIST. NO. 1 ILLINOIS FED. AID PROJECT					