
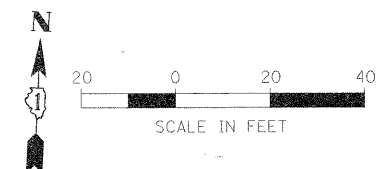



PLAN	SURVEYED	BY	DATE
	ALIGNED		
	NOTED		
	NO.		

PROFILE	SURVEYED	BY	DATE
	PLOTTED		
	CHECKED		
	NO.		

MATCHLINE STA 54+00
SEE SHEET 3 OF 4

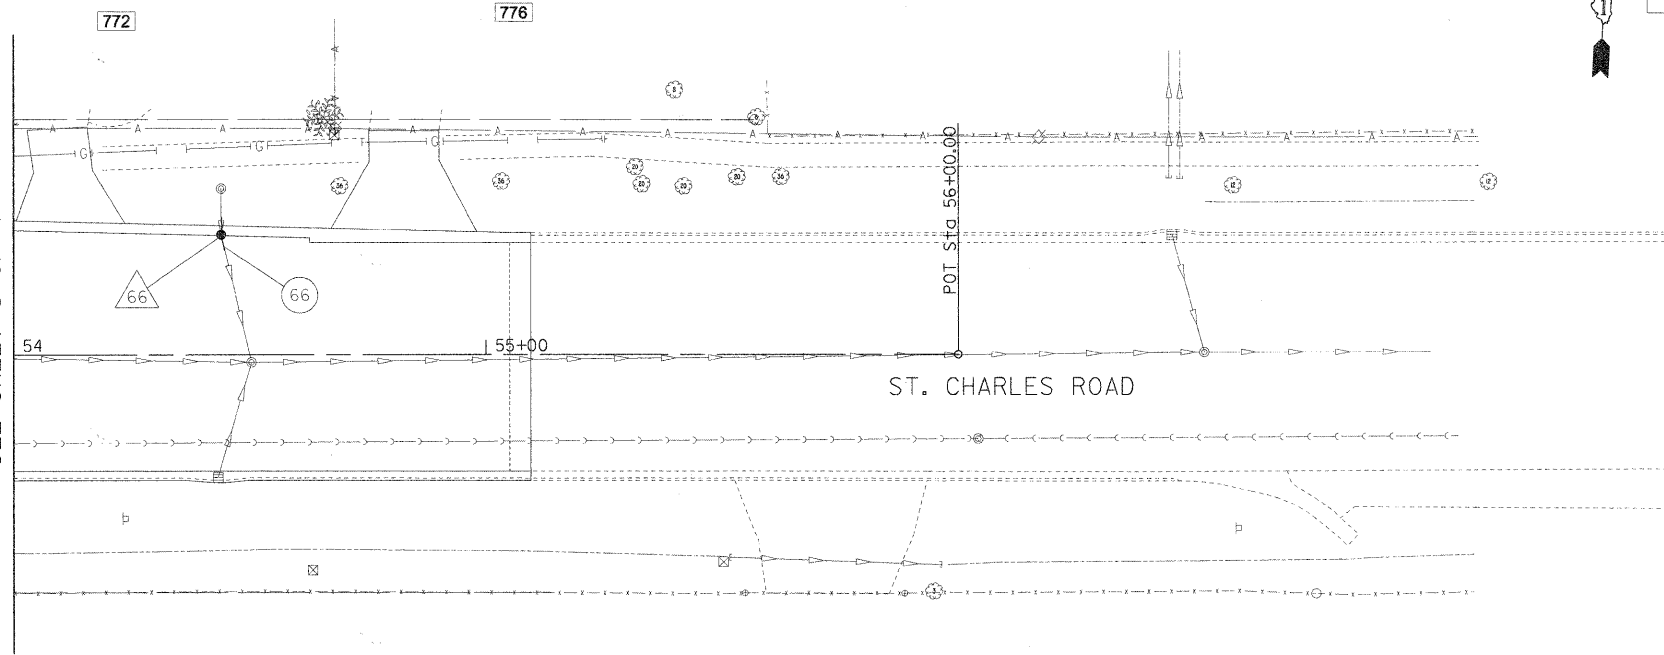

- DRAINAGE LEGEND:
- DRAINAGE STRUCTURE NUMBER
 - STORM SEWER NUMBER
 - DRAINAGE STRUCTURE ADJUSTMENT
 - STORM SEWER WITH CASING PIPE
 - 4" PIPE UNDERDRAIN

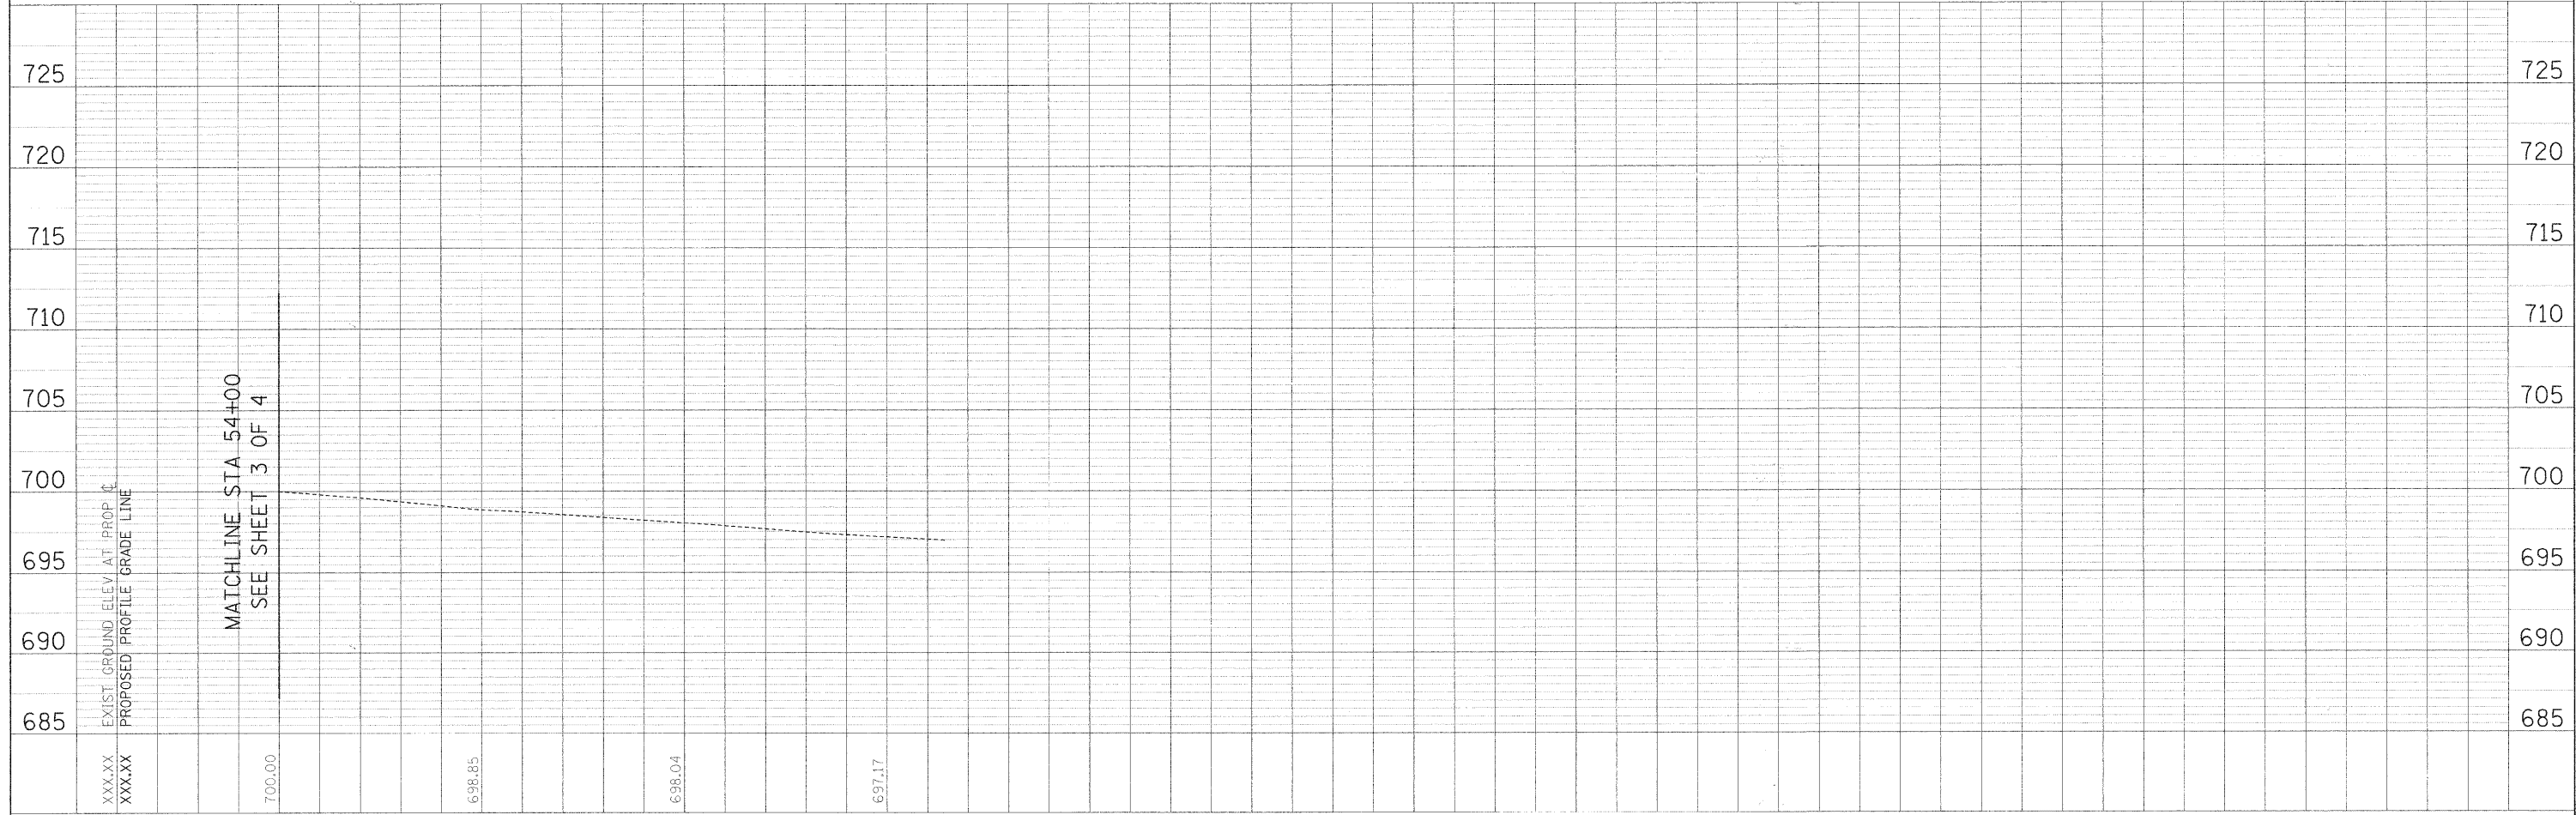

FILE NAME =	USER NAME = #USER#	DESIGNED -	REVISED - AJB	STATE OF ILLINOIS DEPARTMENT OF TRANSPORTATION	ST. CHARLES ROAD DRAINAGE PLAN AND PROFILE	F.A.U. SECTION	COUNTY	TOTAL SHEETS	SHEET NO.
#FILE#		DRAWN -	REVISED - MAP			05-00068-00-FP	DUPAGE	141	58
		CHECKED -	REVISED - DEB			RIFORD ROAD RECONSTRUCTION CONTRACT NO. 63092			
		DATE - 12/01/2009	REVISED -			FED. ROAD DIST. NO. 1 ILLINOIS FED. AID PROJECT			