


CONTRACT No. 63353

PLAN	DESIGNED	DATE
	PLOTTED	
	ALIGNED	
	CHECKED	
	NOTE BOOK	
	NO.	

PROFILE	DESIGNED	DATE
	PLOTTED	
	GRADES	
	CHECKED	
	STRUCTURE	
	NOTATIONS	
	CHKD	
	NO.	

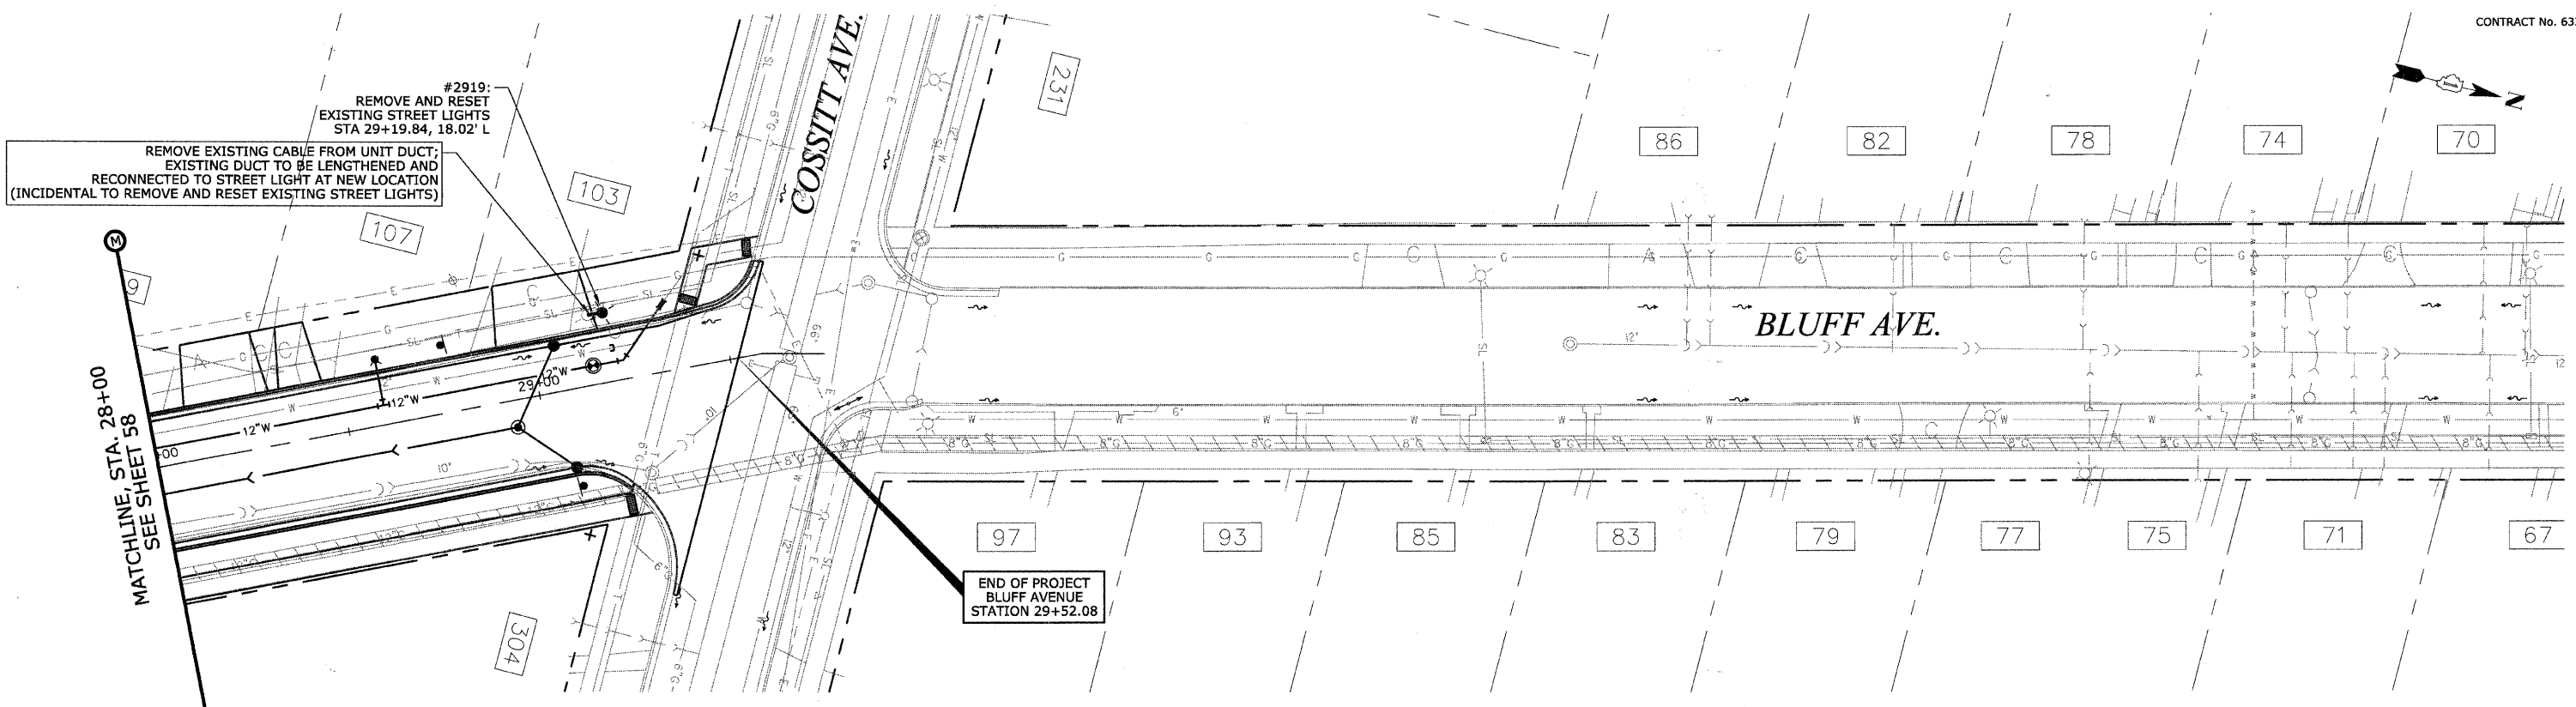

REVISIONS	
NAME	DATE

ILLINOIS DEPARTMENT OF TRANSPORTATION
**BLUFF AVENUE IMPROVEMENTS
 STAGE 3**

ELECTRICAL/STREETLIGHTING PLAN

SCALE: 1" = 20' H (Full Size)
 1" = 44' H (Tabloid)

DATE 11/30/2009

DRAWN BY H&A
 CHECKED BY JRH