


HEUER AND ASSOCIATES
 Consulting Engineers
 2315 Enterprise Drive - Suite 102 Westchester, IL 60154-5811 708-492-1000

| F.A.U. RTE. | SECTION | COUNTY | TOTAL SHEETS | SHEET No. |
|--------------------------------|----------------|--------|------------------|-----------|
| 1004 | 08-00079-03-FP | COOK | 94 | 60 |
| STA. 61+50 | TO STA. 66+00 | | | |
| FED. ROAD DIST. NO. 1 ILLINOIS | | | FED. AID PROJECT | |

CONTRACT No. 63353

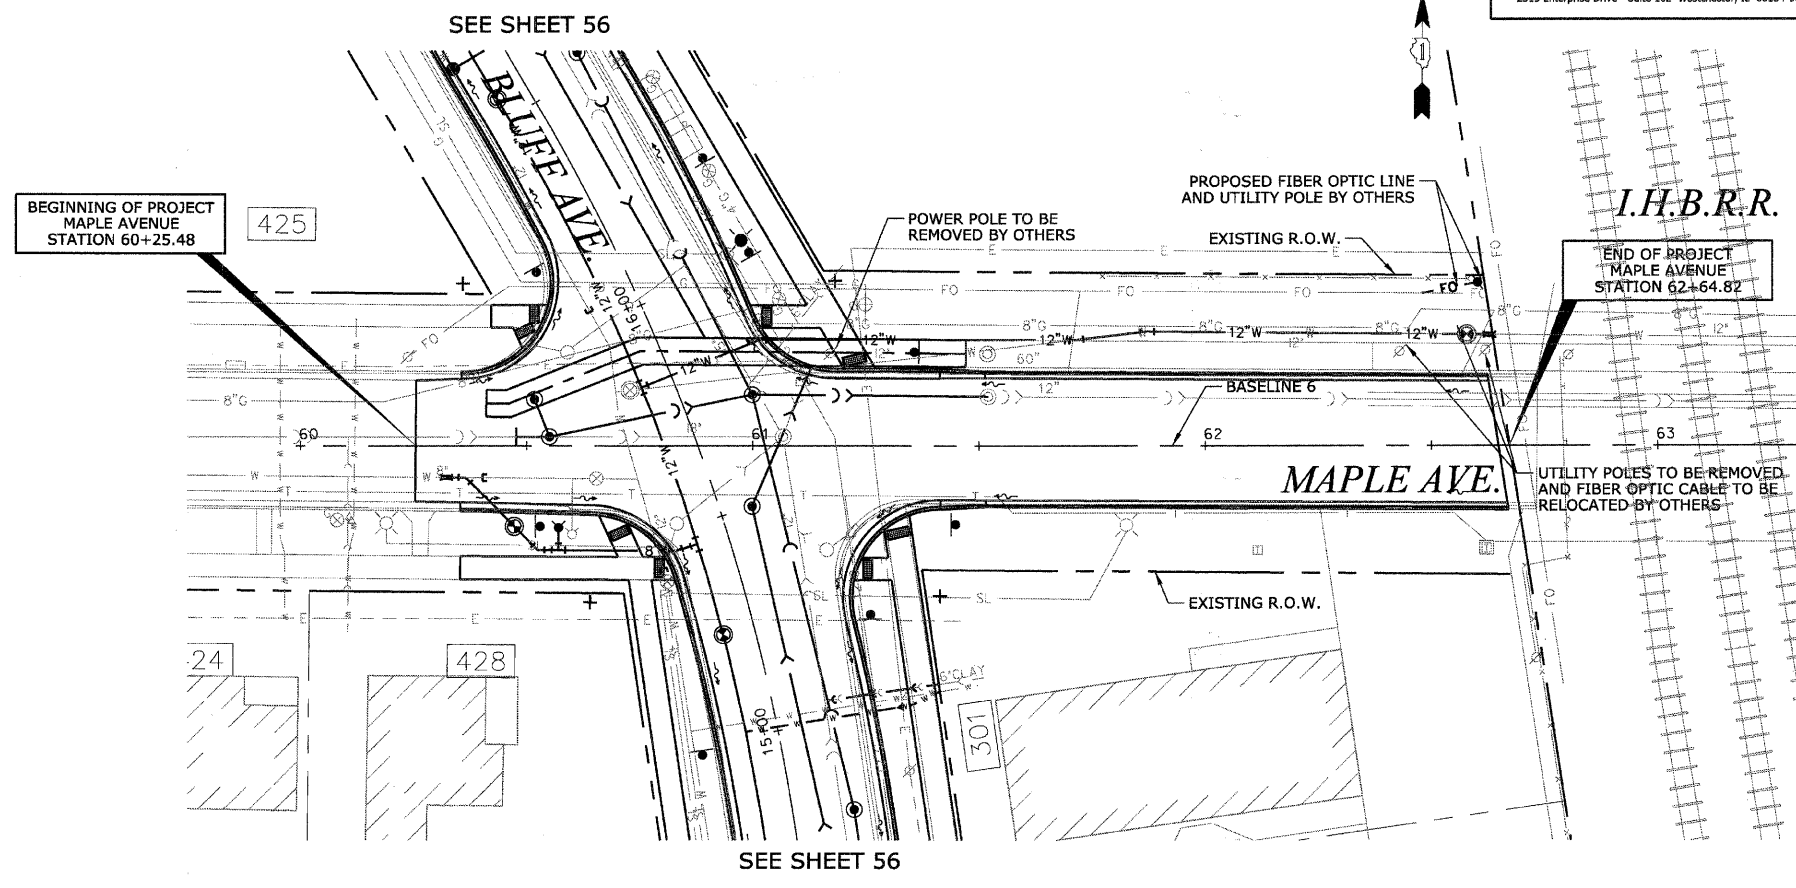

SEE PLANS FOR:
 MAPLE AVENUE RELIEF SEWER
 PROJECT STAGE 2
 SECTION 08-00079-02-FP
 PROJECT NO. M-9003 (168)
 COOK COUNTY: C-91-203-09

NOTE:
 1. NO SCHEDULED ELECTRICAL WORK FOR THIS SECTION OF BLUFF AVENUE IMPROVEMENT PROJECT; THIS SHEET IS INCLUDED FOR CONTINUITY ONLY.

| | |
|-----------|------|
| PLAN | DATE |
| BY | |
| REVISIONS | |
| PLOTTED | |
| CHECKED | |
| DATE | |
| NO. | |

| | |
|-----------|------|
| PROFILE | DATE |
| BY | |
| REVISIONS | |
| PLOTTED | |
| CHECKED | |
| DATE | |
| NO. | |

| REVISIONS | |
|-----------|------|
| NAME | DATE |
| | |
| | |
ILLINOIS DEPARTMENT OF TRANSPORTATION
**BLUFF AVENUE IMPROVEMENTS
 STAGE 3**
ELECTRICAL/STREETLIGHTING PLAN
 SCALE: 1" = 20' H (Full Size)
 1" = 44' H (Tabloid)
 DATE 11/30/2009
 DRAWN BY H&A
 CHECKED BY JRH