


F.A.U. RTE.	SECTION	COUNTY	TOTAL SHEETS	SHEET NO.
FAT 80	50 - 8HBR	LASALLE	142	54
STA.	TO STA.			
FED. ROAD DIST. NO. 3		ILL. NOIS	FED. AID PROJECT	

NOTES:

1. THE EXISTING LIGHTING CONTROLLER SHALL BE REMOVED ONLY AFTER THE PROPOSED LIGHTING SYSTEM HAS BEEN INSTALLED AND MADE FULLY OPERATIONAL. THE EXISTING LIGHTING CONTROLLER SHALL THEN BE SALVAGED AND DELIVERED TO THE STATE MAINTENANCE FACILITY AS DIRECTED BY THE ENGINEER. THIS WORK WILL BE PAID FOR UNDER PAY ITEM "REMOVE EXISTING LIGHTING CONTROLLER AND SALVAGE".
2. THE CONTRACTOR SHALL PROVIDE AND INSTALL 30' WOOD POLES IN THE LOCATIONS SPECIFIED TO SUPPORT THE PROPOSED TEMPORARY AERIAL CABLES.
3. THE CONTRACTOR SHALL PROTECT ALL LIGHTING EQUIPMENT IN THE CONSTRUCTION ZONE. THIS PROTECTION SHALL APPLY TO ALL LIGHT POLES; EXISTING, TEMPORARY, AND PROPOSED.

UNIT DUCT FOR TEMPORARY
USE ONLY AND SHALL BE ATTACHED
TO THE WOOD POLE PER TEMPORARY
ROADWAY LIGHTING DETAIL AND SPLICED
TO THE AERIAL CABLE.

GENERAL NOTE:
ALL LIGHTING WORK SHOWN ON THIS PLAN SHALL BE INSTALLED
AND MADE OPERATIONAL PRIOR TO COMMENCEMENT OF STAGE 2
CONSTRUCTION.

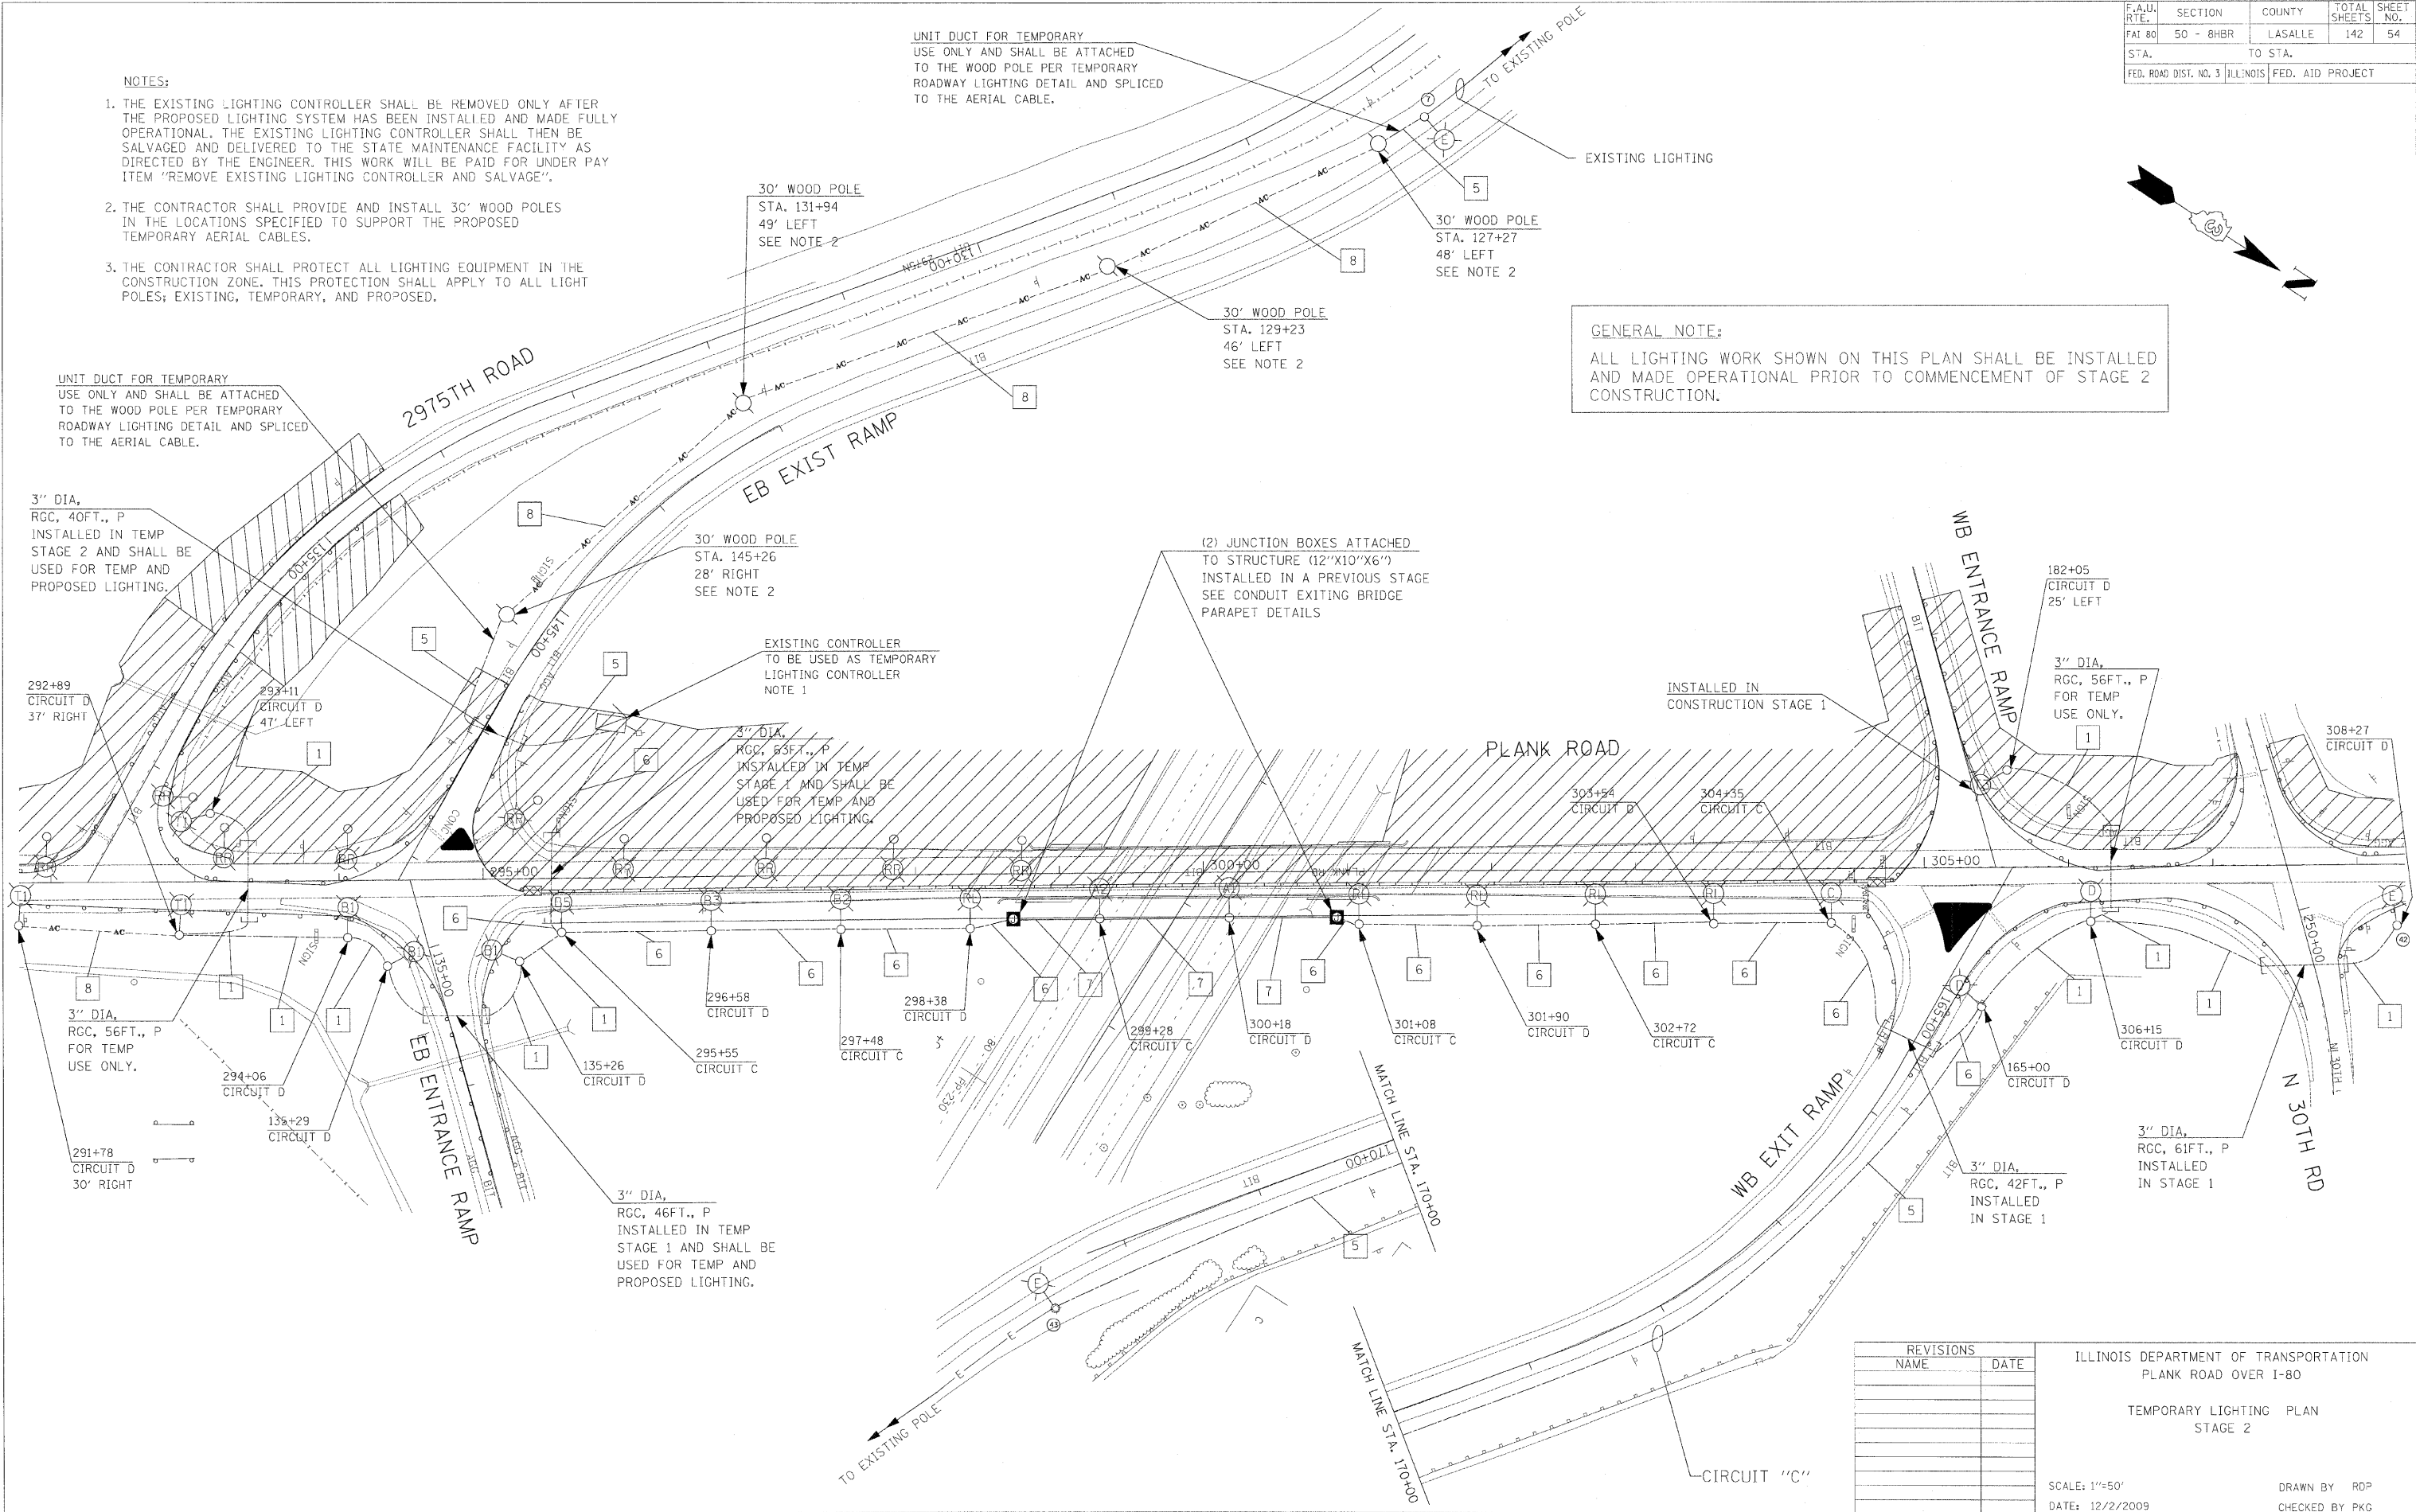

UNIT DUCT FOR TEMPORARY
USE ONLY AND SHALL BE ATTACHED
TO THE WOOD POLE PER TEMPORARY
ROADWAY LIGHTING DETAIL AND SPLICED
TO THE AERIAL CABLE.

3" DIA,
RCC, 40FT., P
INSTALLED IN TEMP
STAGE 2 AND SHALL BE
USED FOR TEMP AND
PROPOSED LIGHTING.

3" DIA,
RCC, 63FT., P
INSTALLED IN TEMP
STAGE 1 AND SHALL BE
USED FOR TEMP AND
PROPOSED LIGHTING.

3" DIA,
RCC, 56FT., P
FOR TEMP
USE ONLY.

3" DIA,
RCC, 46FT., P
INSTALLED IN TEMP
STAGE 1 AND SHALL BE
USED FOR TEMP AND
PROPOSED LIGHTING.

3" DIA,
RCC, 56FT., P
FOR TEMP
USE ONLY.

3" DIA,
RCC, 61FT., P
INSTALLED
IN STAGE 1

REVISIONS	
NAME	DATE

ILLINOIS DEPARTMENT OF TRANSPORTATION
PLANK ROAD OVER I-80
TEMPORARY LIGHTING PLAN
STAGE 2

SCALE: 1"=50'
DATE: 12/2/2009
DRAWN BY ROP
CHECKED BY PKG

PLOT DATE = 2/2/2009
FILE NAME = #FILES#
PLOT SCALE = #SCALE#
PLOT TIME = 11:24:33 AM