
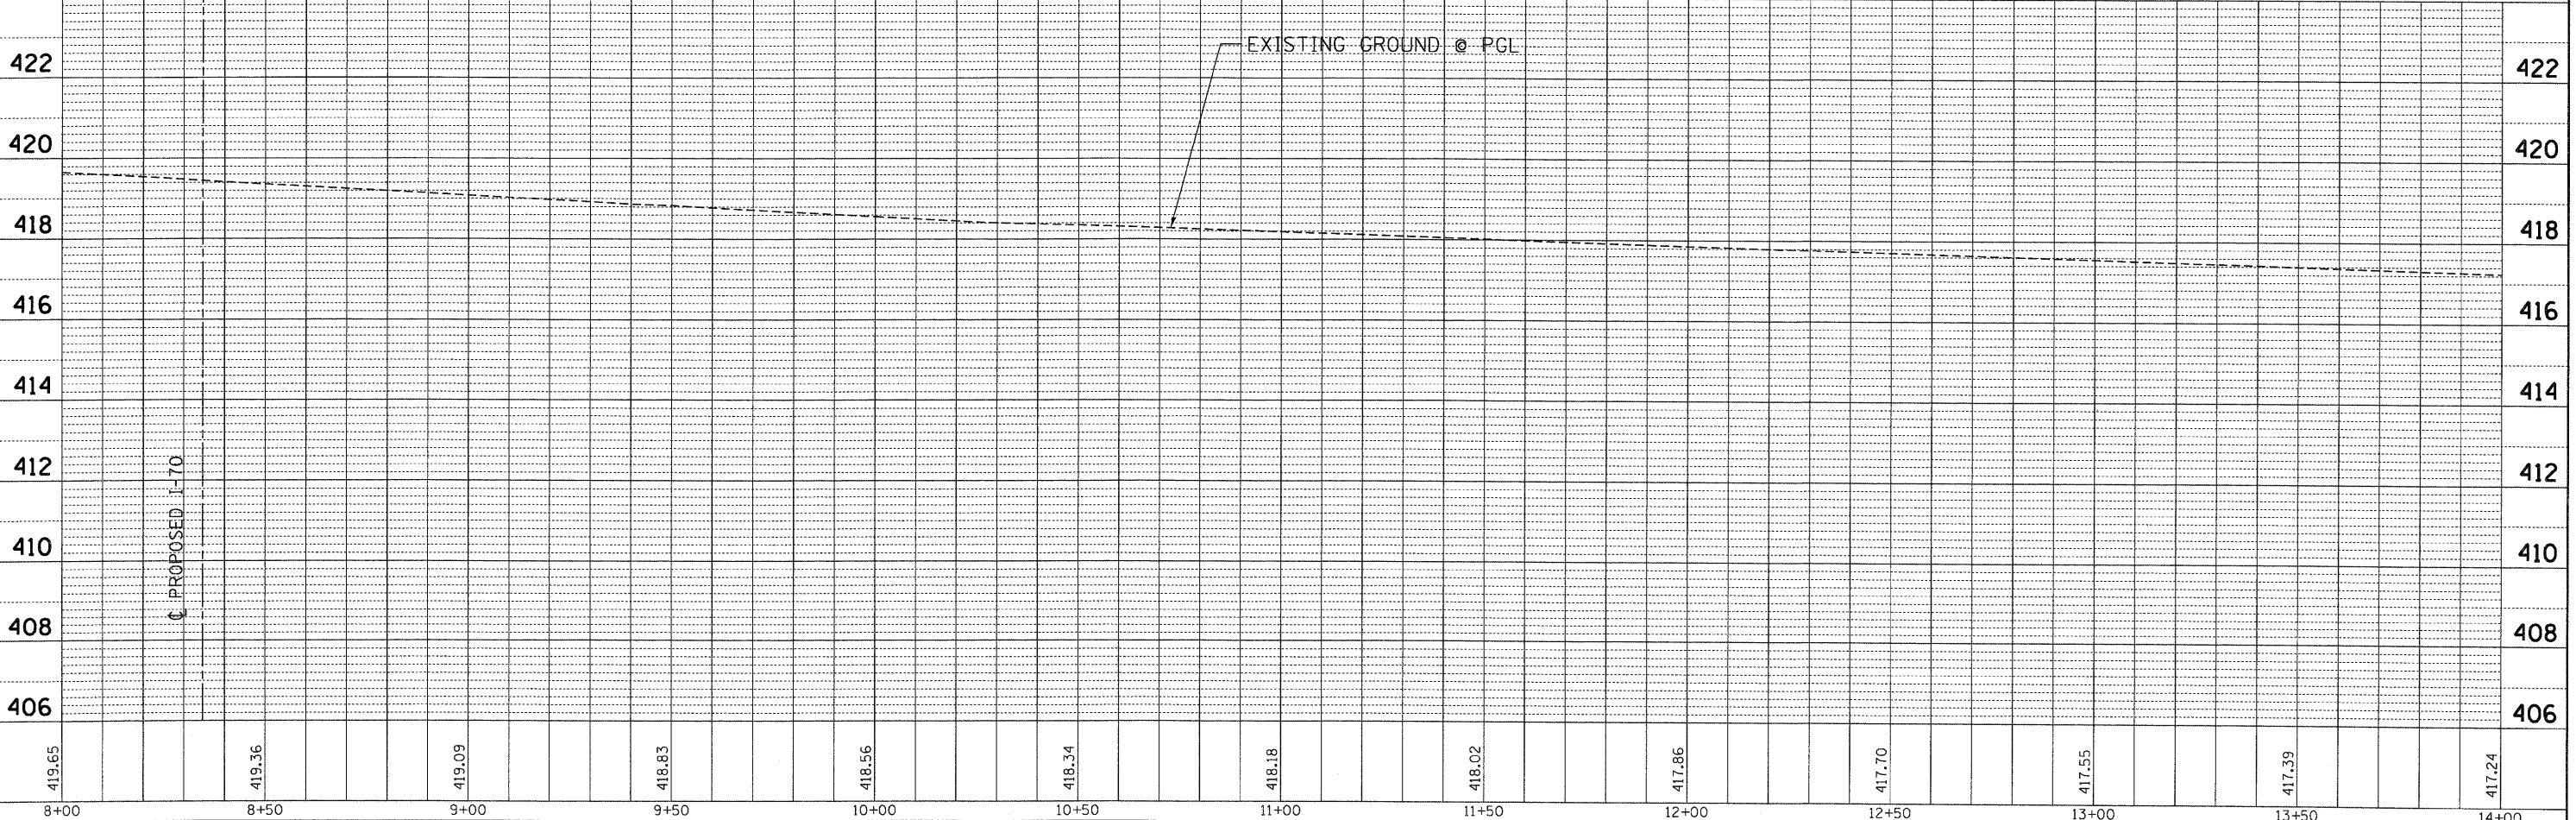


PLAN	SURVEYED	DATE
NOTE BOOK NO.	PLOTTED	
	CHECKED	
	BY	
	DATE	

PROFILE	SURVEYED	DATE
NOTE BOOK NO.	PLOTTED	
	CHECKED	
	BY	
	DATE	

10-14-2009 16:18:47 BONDHUIJD  
 C:\C:\WORKSPACE\BONDHUIJD\NFS-0044.D\TRANS.07\2282\28869-001\CIVIL\CAO\99 ALL CONTRACTS\CONNSHEETS CONTRACT 03\DRNUTLL-1106.DGN

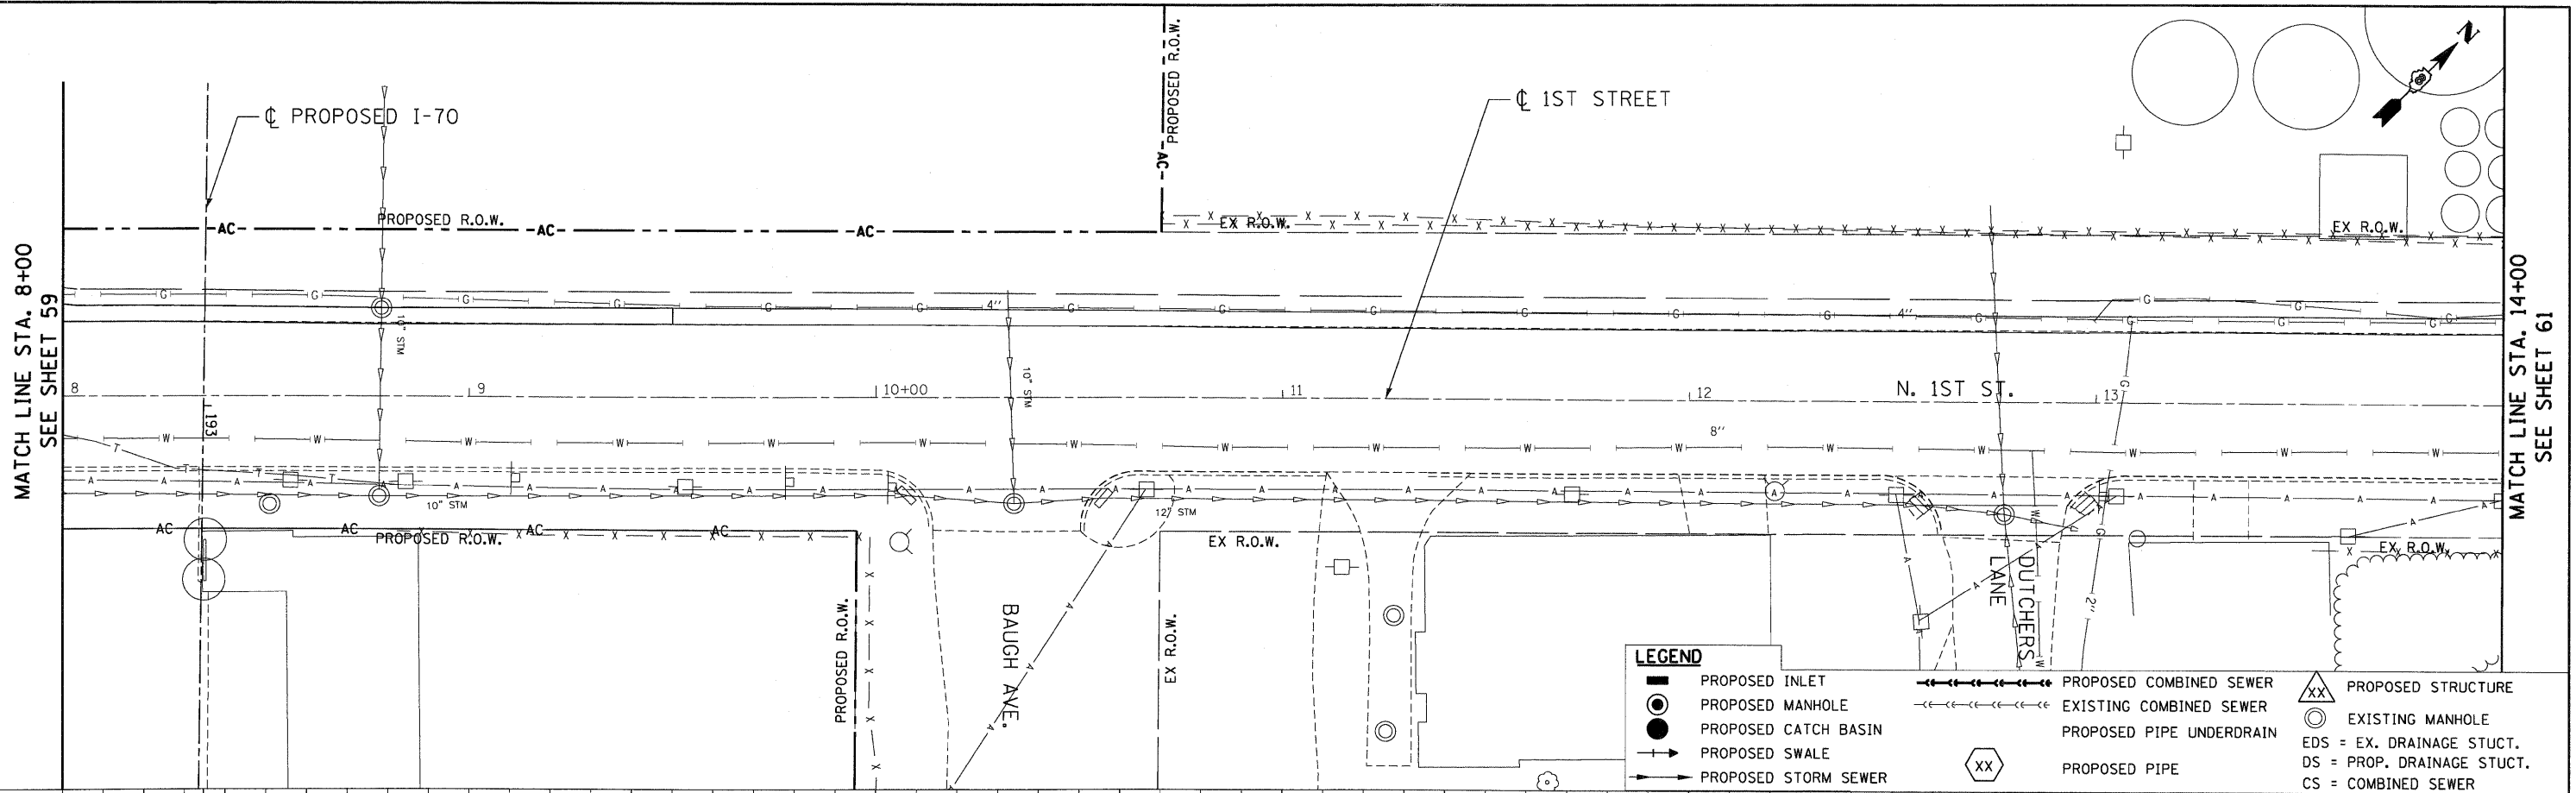

LEGEND	
	PROPOSED INLET
	PROPOSED MANHOLE
	PROPOSED CATCH BASIN
	PROPOSED SWALE
	PROPOSED STORM SEWER
	PROPOSED COMBINED SEWER
	EXISTING COMBINED SEWER
	PROPOSED PIPE UNDERDRAIN
	EXISTING MANHOLE
	EDS = EX. DRAINAGE STUCT.
	DS = PROP. DRAINAGE STUCT.
	CS = COMBINED SEWER
	PROPOSED STRUCTURE
	EXISTING MANHOLE
	PROPOSED PIPE

FILE NAME =	USER NAME = #USER#	DESIGNED - JB	REVISED -	<b>STATE OF ILLINOIS</b> <b>DEPARTMENT OF TRANSPORTATION</b> I-70 CONNECTION	<b>PROPOSED DRAINAGE PLAN &amp; PROFILE</b> <b>1ST STREET</b> <b>STA. 8 + 00.00 TO STA. 14 + 00.00</b>	F.A.P. RTE.	SECTION	COUNTY	TOTAL SHEETS	SHEET NO.	
#FILEL#		DRAWN - JB	REVISED -			9153	82-1K	ST. CLAIR	107	60	
PLOT SCALE = #SCALE#		CHECKED - ACL	REVISED -			CONTRACT NO. 76C40					
PLOT DATE = #DATE#		DATE - 10/09/09	REVISED -			FED. ROAD DIST. NO. ILLINOIS FED. AID PROJECT					



SCALE: HORIZ. 1"=20' VERT. 1"=2' STA. TO STA.