
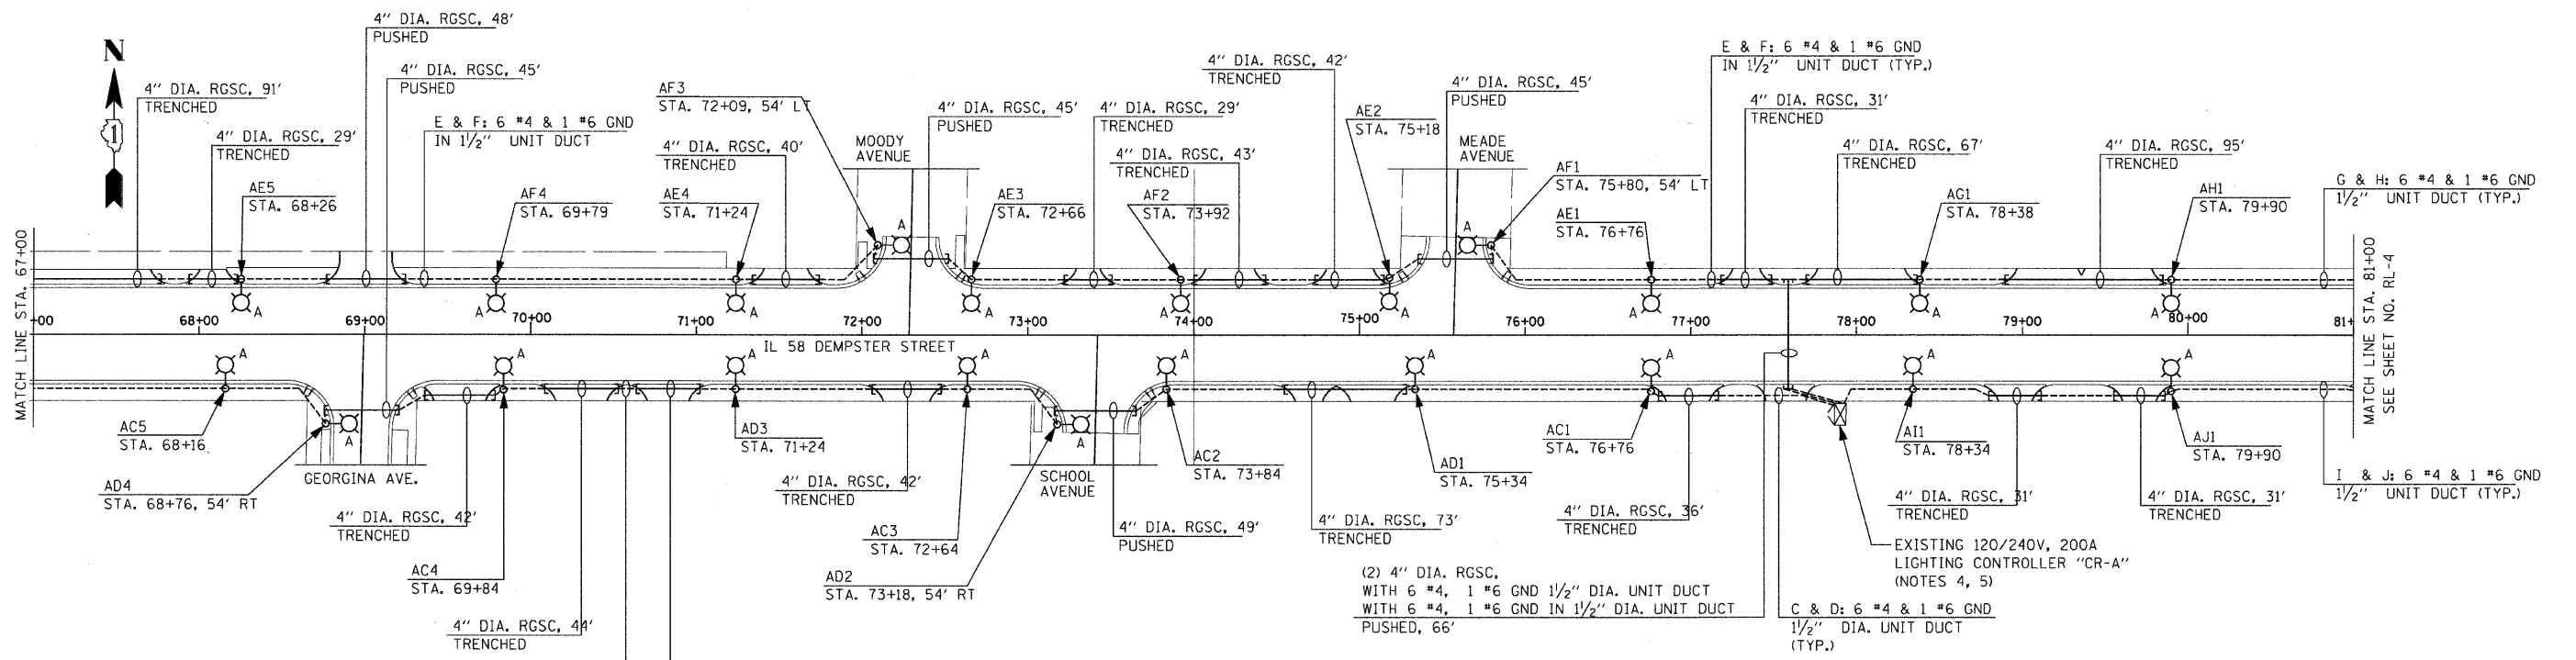


E.A.U. RTE.	SECTION	COUNTY	TOTAL SHEETS	SHEET NO.
1324	03-00097-01-PV	COOK	82	64
STA.	TO STA.			
FED. ROAD DIST. NO.	ILLINOIS	FED. AID PROJECT		

CONTRACT # 83971

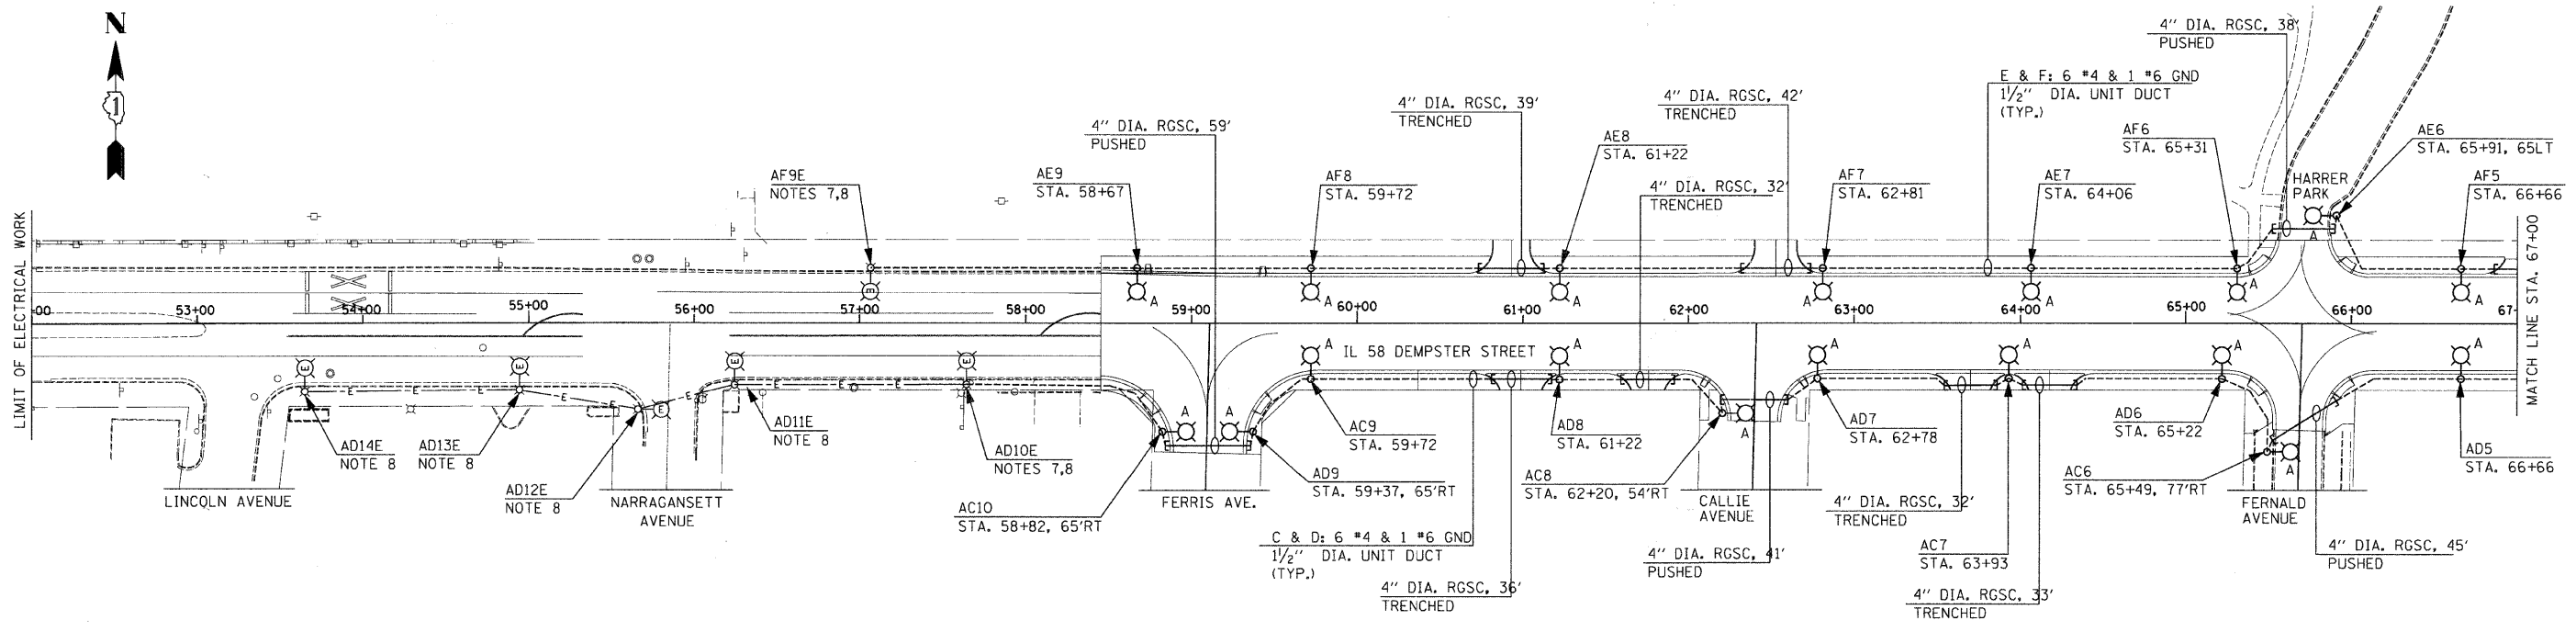

7. DISCONNECT AND ABANDON EXISTING CONDUIT 3'-0" BELOW GRADE AND CONNECT NEW UNIT DUCT TO EXISTING CIRCUIT. CONTRACTOR SHALL EXCAVATE AT EXISTING LIGHT POLE FOUNDATION, PULL EXISTING WIRING FROM EXISTING ELBOW AND INSTALL NEW WIRING IN EXISTING ELBOW AND SPLICE TO EXISTING CIRCUIT IN LIGHT POLE HANDHOLE. CHANGE OVER SHALL BE DONE DURING DAYLIGHT HOURS AFTER ALL OTHER WORK IS DONE. MAINTAIN EXISTING LIGHTING DURING HOURS OF DARKNESS. ALL MATERIAL AND LABOR FOR CONNECTING UNIT DUCT TO EXISTING LIGHT POLE SHALL BE INCLUDED IN THE "UNIT DUCT" PAY ITEM. NO SEPARATE PAYMENT WILL BE MADE.
8. REMOVE EXISTING LIGHT POLE IDENTIFICATION DECAL AND PROVIDE NEW DECAL TO INDICATE THE REVISED LIGHTING UNIT DESIGNATION. THE COST OF THIS WORK SHALL BE INCLUDED IN THE COST OF "LIGHT POLE, ALUMINUM, 47/2" M.H., 15' MAST ARM" PAY ITEM. NO SEPARATE PAYMENT WILL BE MADE.

NOTES:

- REFER TO DRAWING RL-1 FOR LIGHTING CONSTRUCTION PHASING NOTES.
- REFER TO DRAWING ED-1 FOR TYPE "A" LIGHT POLE AND FOUNDATION DETAILS.
- ALL LIGHT POLES SHALL BE LOCATED 2'-0" FROM THE BACK OF BARRIER CURB TO THE FACE OF LIGHT POLES.
- REFER TO DRAWING ED-4 FOR EXISTING LIGHTING CONTROLLER "CR-A" ONE LINE DIAGRAM.
- REFER TO DRAWING ED-2 FOR EXISTING LIGHTING CONTROLLER "CR-A" DETAILS.
- REFER TO DRAWING ED-5 FOR LIGHT POLE BASE WIRING DETAILS.

REVISIONS	
NAME	DATE

ILLINOIS DEPARTMENT OF TRANSPORTATION
IL RTE 58 (DEMPSTER ST) IMPROVEMENTS

PROPOSED ROADWAY LIGHTING PLAN

SCALE: 1" = 50'
DATE: 10-16-09

DRAWN BY:
CHECKED BY:

McDonough Associates Inc.
Engineers / Architects