



LEFT PROFILE

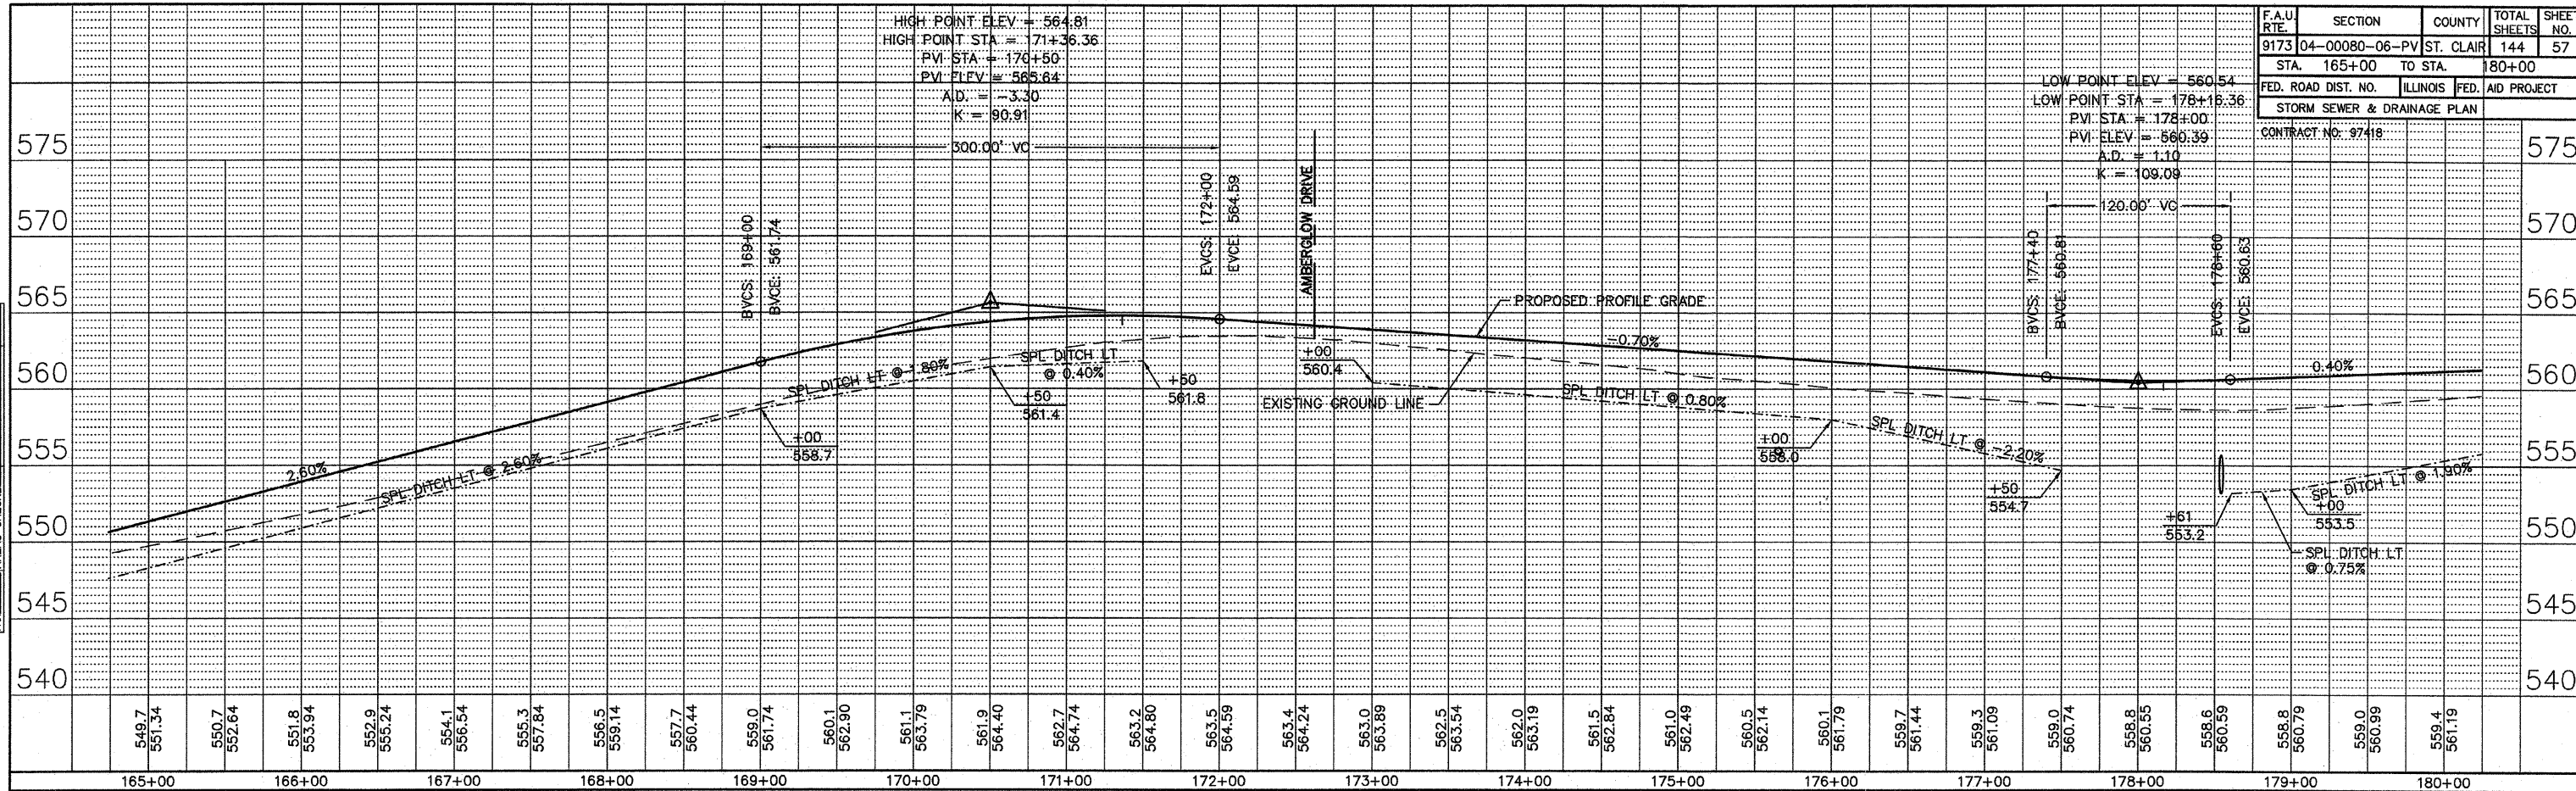

F.A.U. RTE.	SECTION	COUNTY	TOTAL SHEETS	SHEET NO.
9173	04-00080-06-PV	ST. CLAIR	144	57
STA. 165+00 TO STA. 180+00		FED. ROAD DIST. NO. ILLINOIS FED. AID PROJECT		
STORM SEWER & DRAINAGE PLAN				
CONTRACT NO. 97418				

BY	DATE
FINAL SURVEY PLOTTED	
NOTE BOOK	
AREAS CHECKED	
NO.	

RIGHT PROFILE

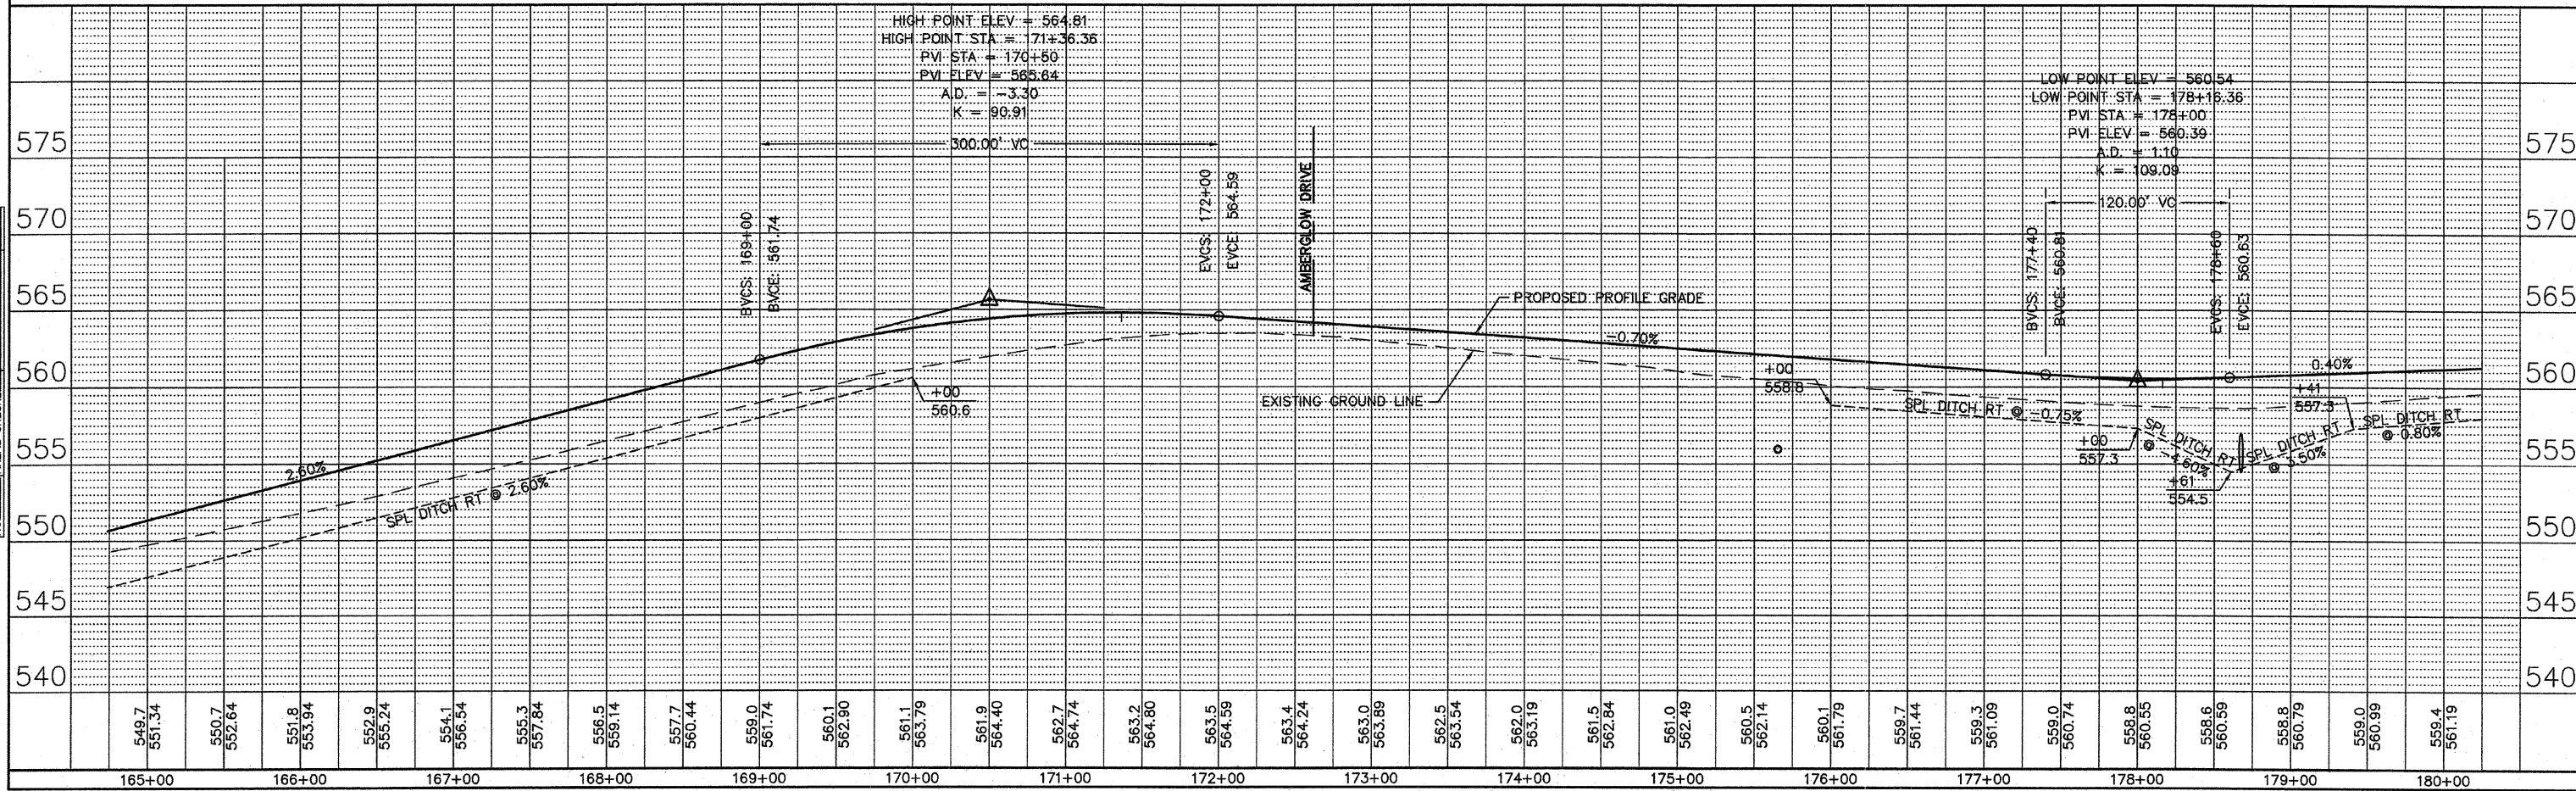

BY	DATE
ORIGINAL SURVEY PLOTTED	
NOTE BOOK	
AREAS CHECKED	
NO.	