



LEFT PROFILE

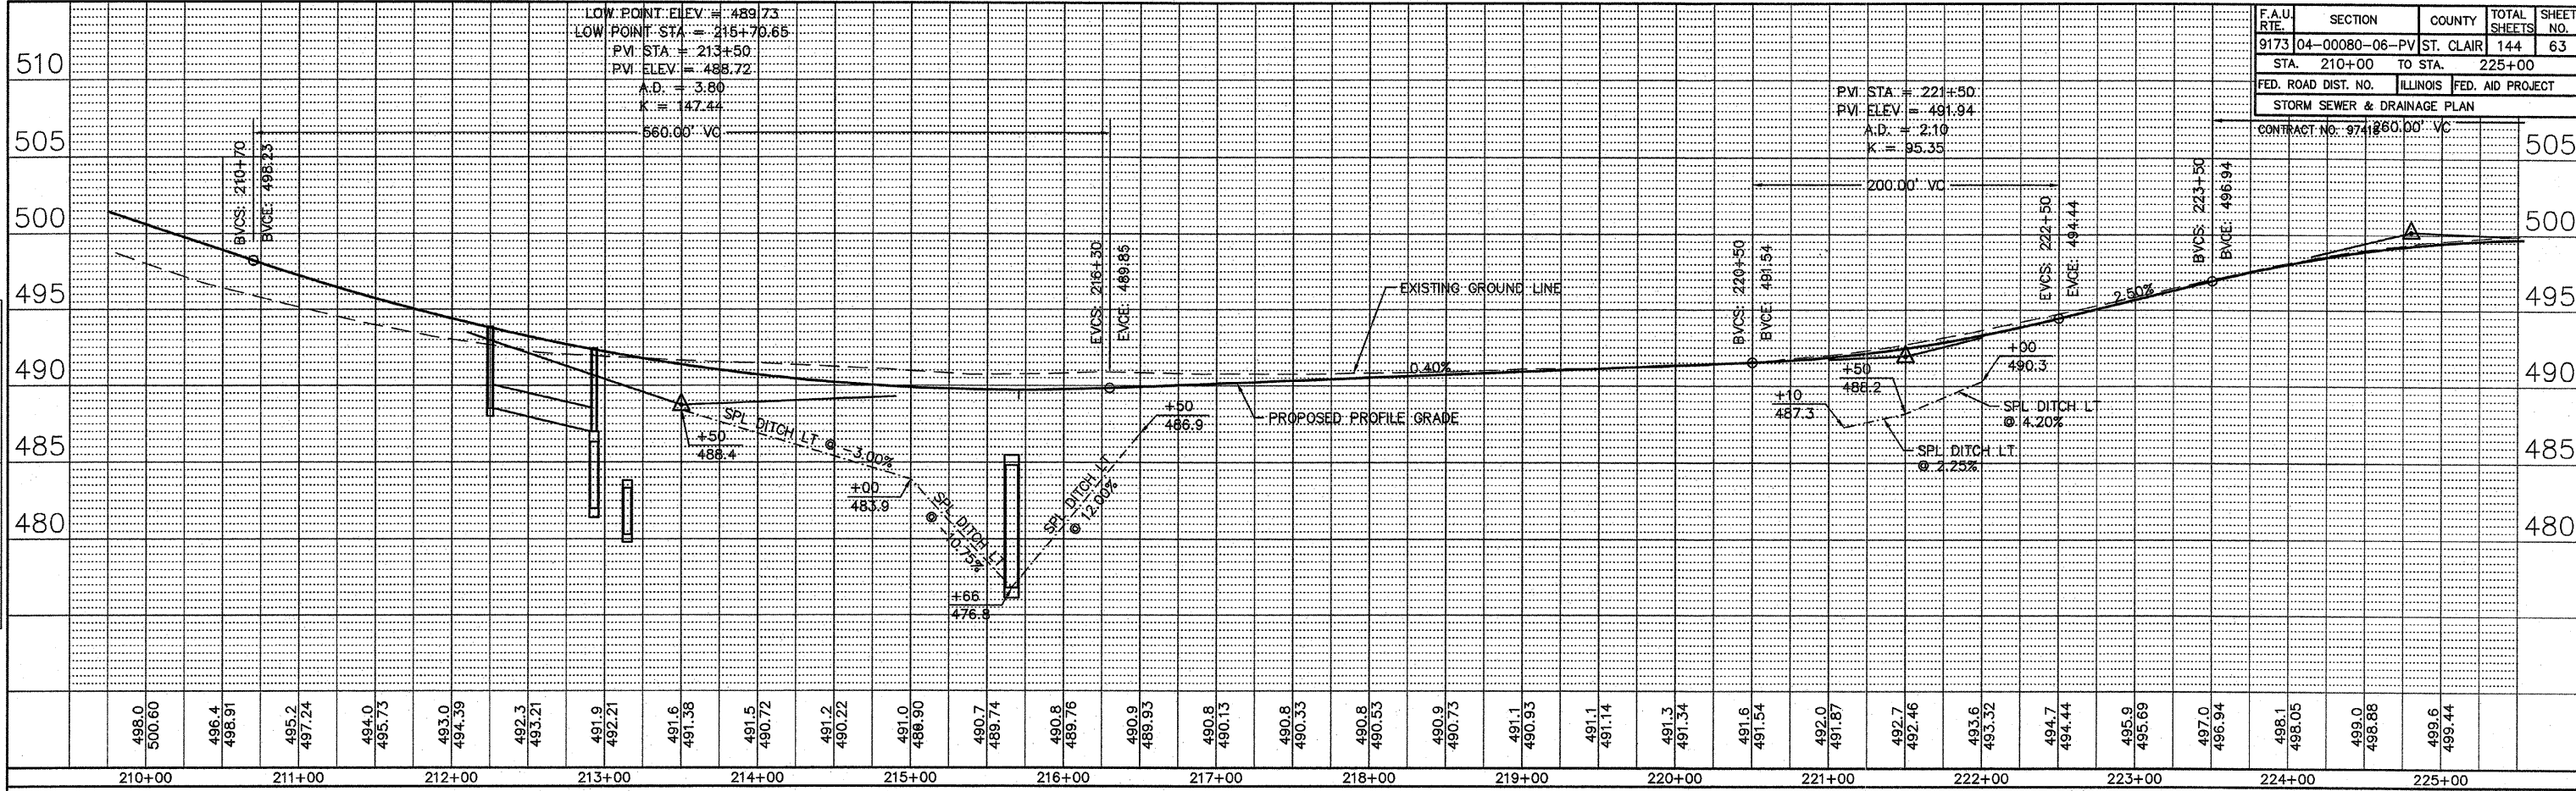

F.A.U. RTE.	SECTION	COUNTY	TOTAL SHEETS	SHEET NO.
9173	04-0080-06-PV	ST. CLAIR	144	63
STA. 210+00 TO STA. 225+00				
FED. ROAD DIST. NO. ILLINOIS FED. AID PROJECT				
STORM SEWER & DRAINAGE PLAN				
CONTRACT NO. 974860.00' VC				

BY	DATE

RIGHT PROFILE

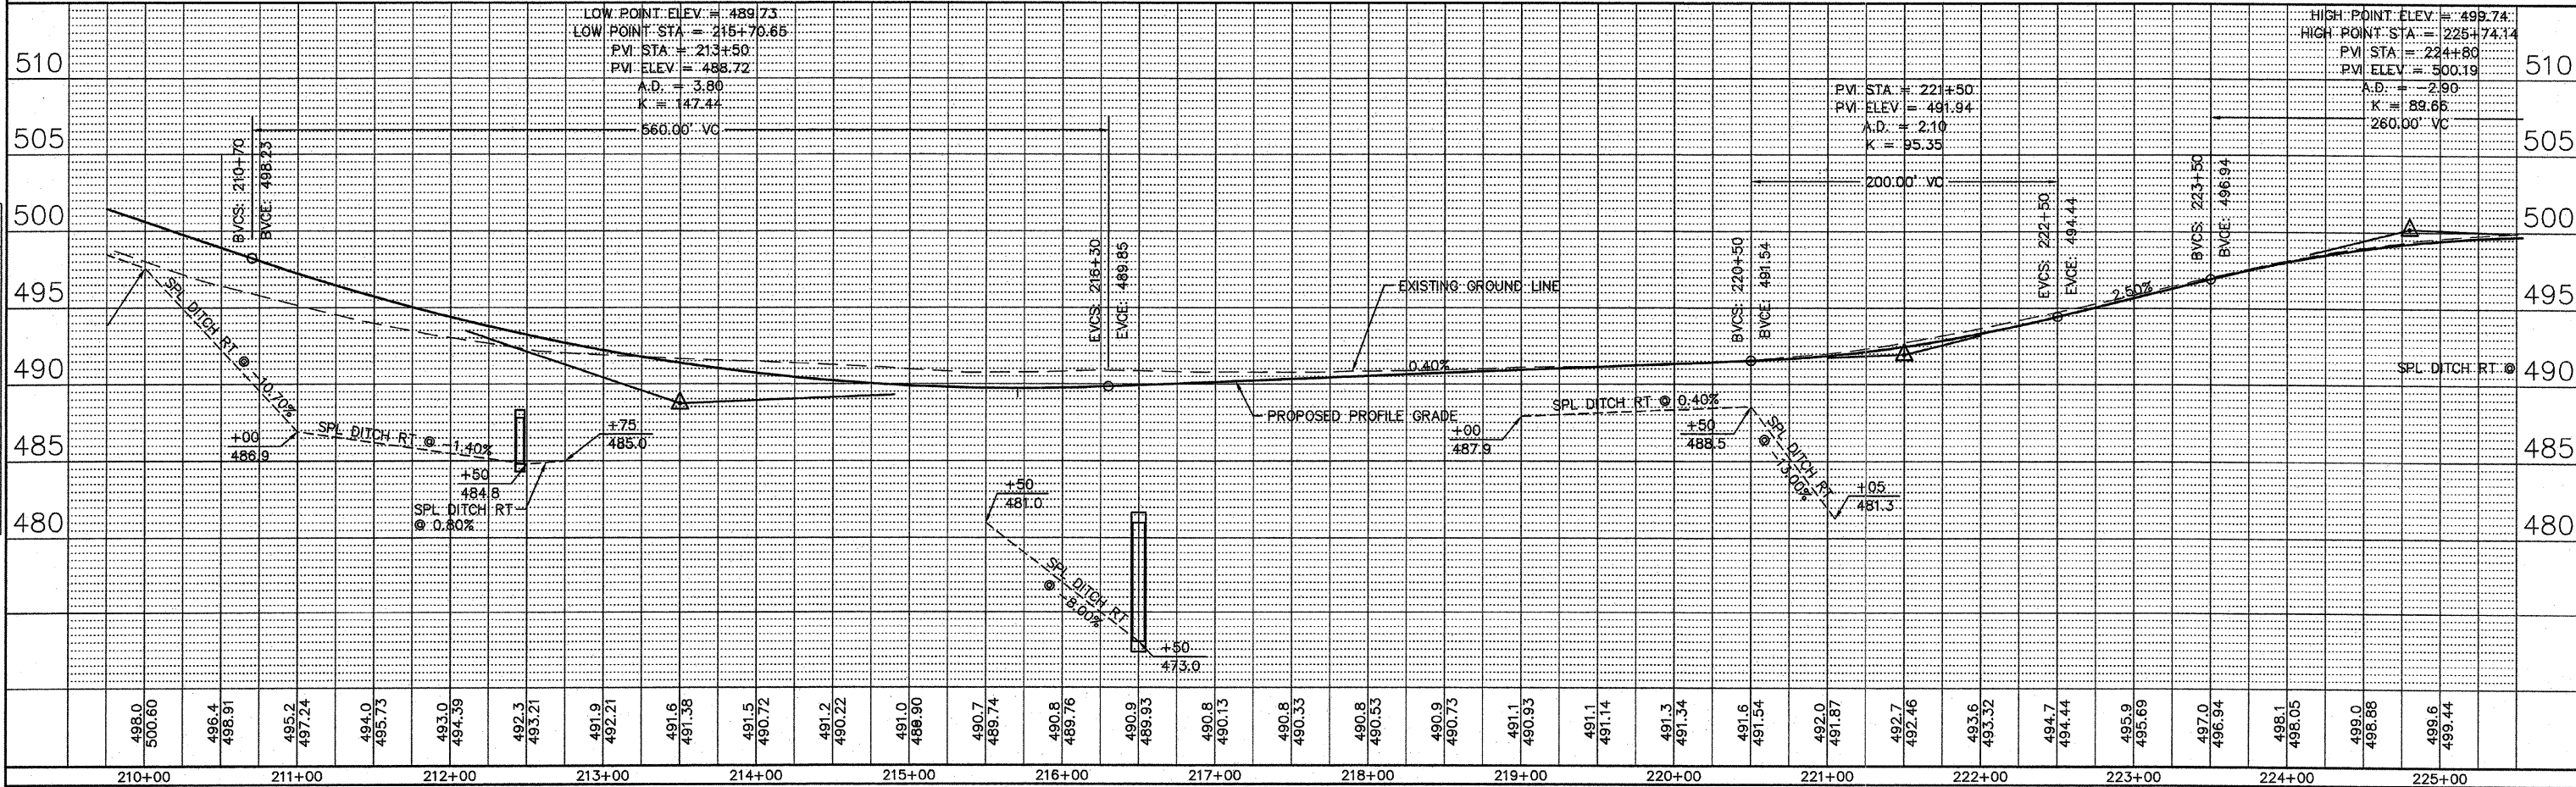

BY	DATE