


F.A. RTE.	SECTION	COUNTY	TOTAL SHEETS	SHEET NO.
9173	04-00080-06-PV	ST. CLAIR	144	66
STA. 120+00		TO STA. 135+00		
FED. ROAD DIST. NO.	ILLINOIS	FED. AID PROJECT		
STORM SEWER & DRAINAGE PLAN				
CONTRACT NO: 97418				

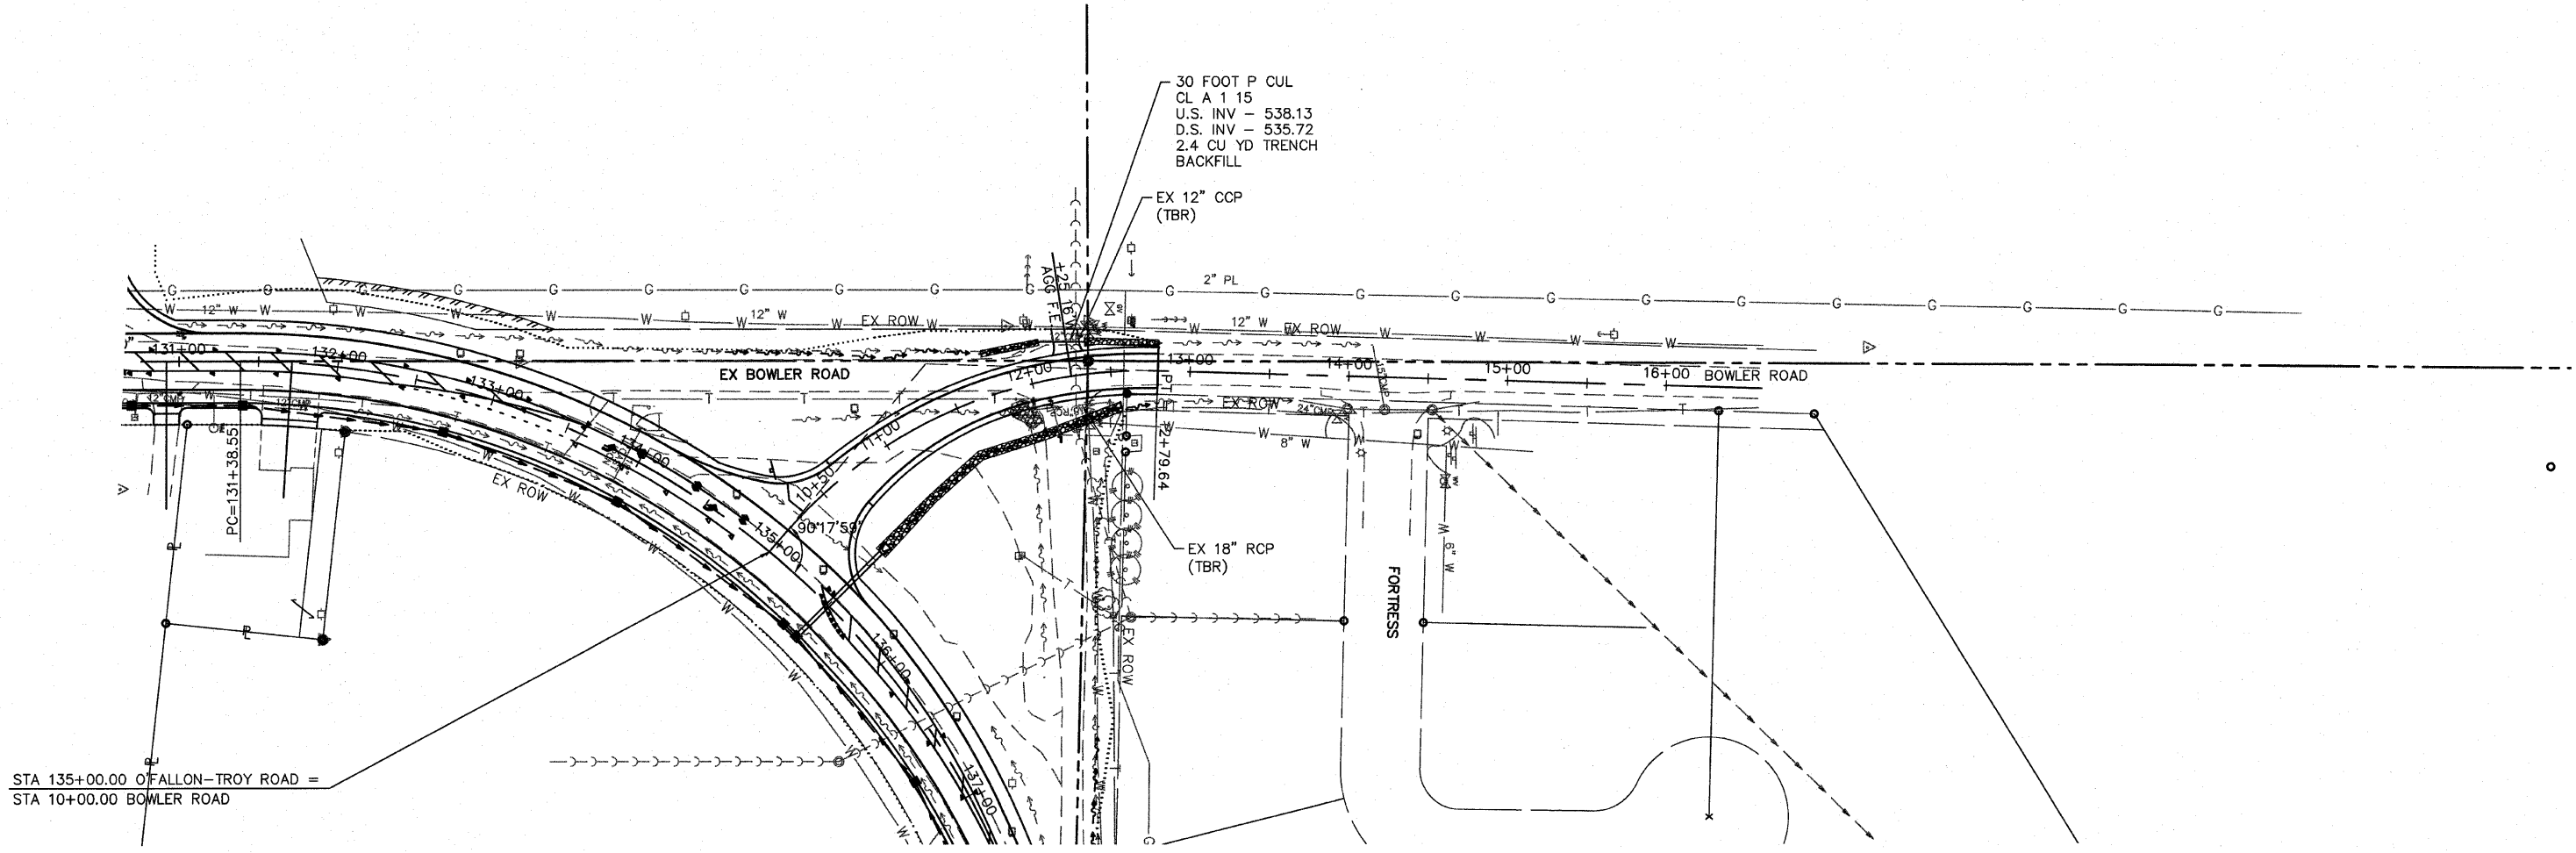

STA 135+00.00 OF FALLON-TROY ROAD =
STA 10+00.00 BOWLER ROAD

