
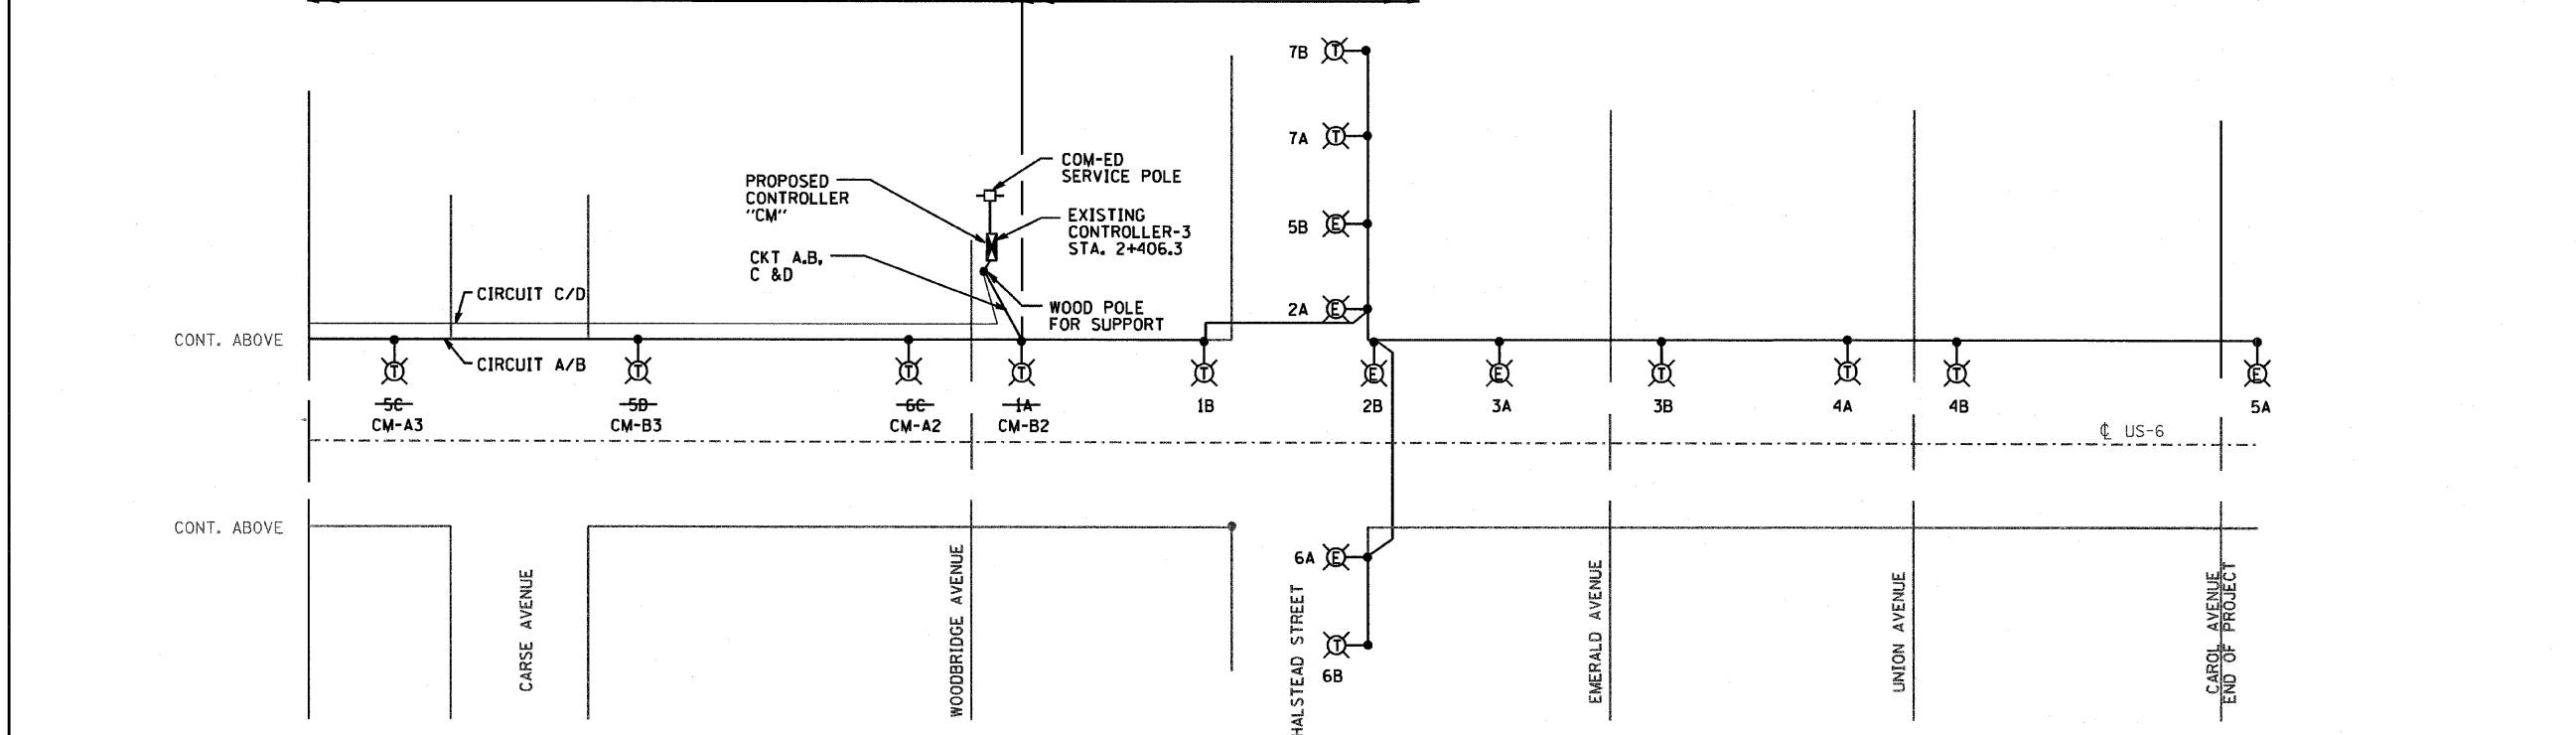


F.A. RTE.	SECTION	COUNTY	TOTAL SHEETS	SHEET NO.
351	3277R	COOK	541	357
STA.		TO STA.		
FED. ROAD DIST. NO.		ILLINOIS FED. AID PROJECT		

CONTRACT NO. 60774

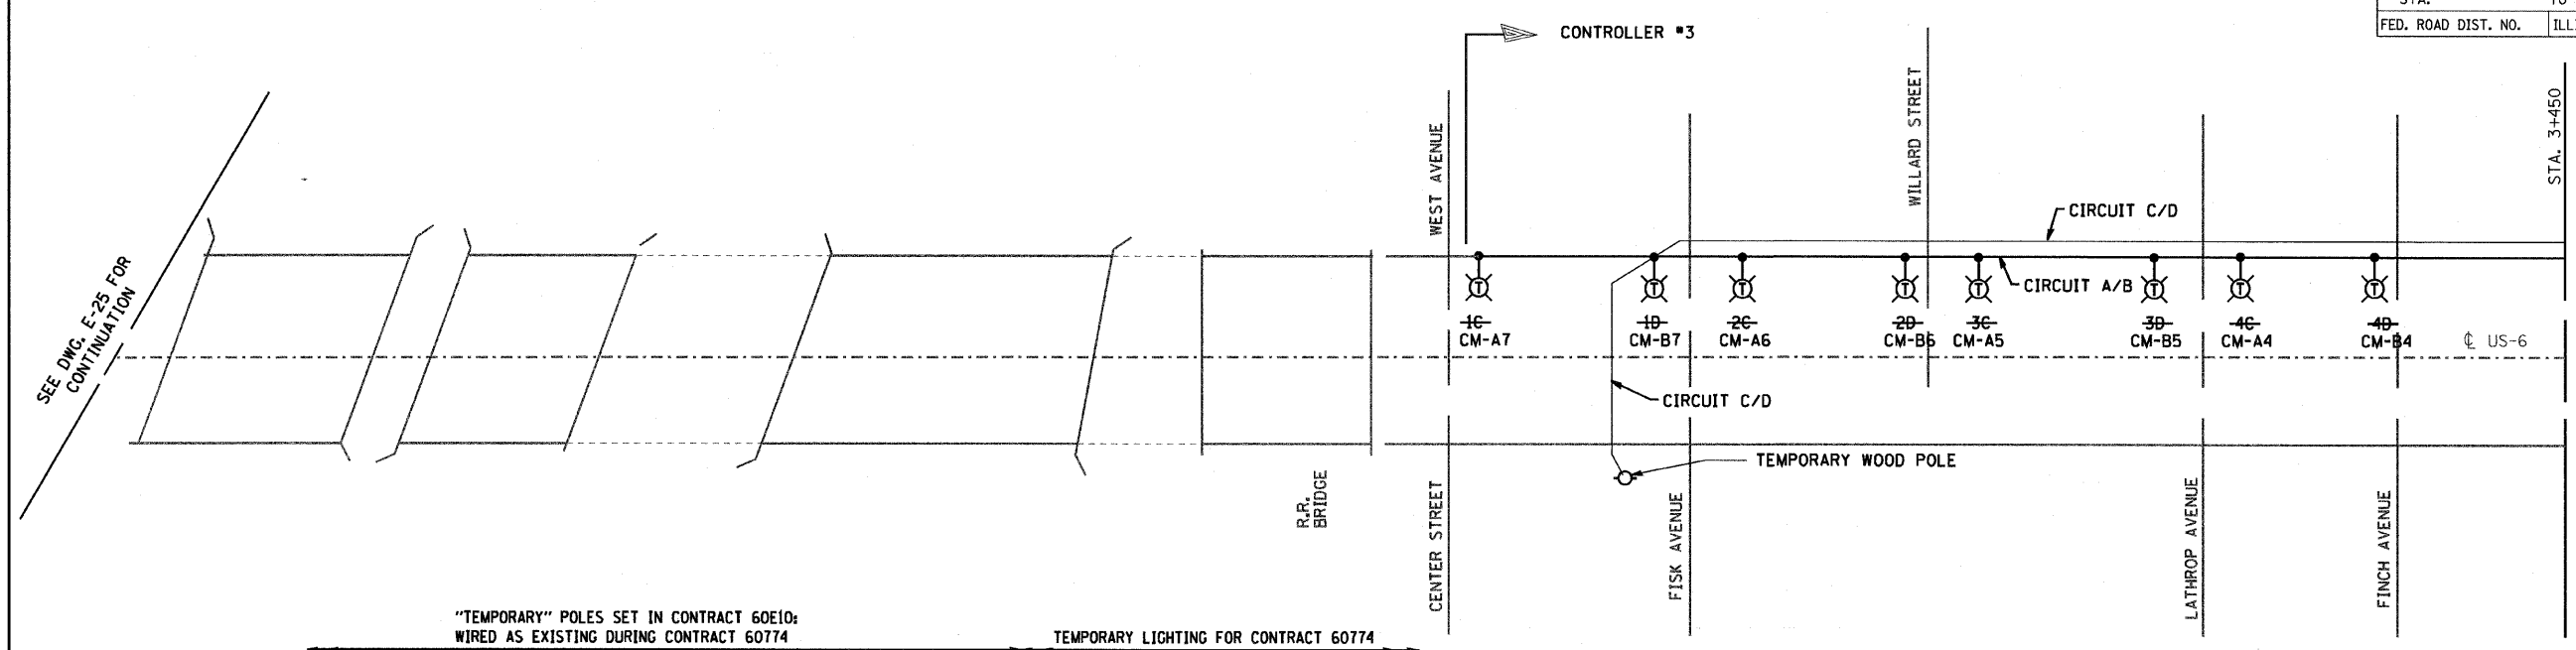

LOAD TABLE

CONTROLLER 3		
CIRCUIT NO.	LOAD	CURRENT
A	2410W	10.75A
B	3105W	9.89A
C	2500W	10.04A
D	2375W	12.43A

- LEGEND:
- LIGHT POLE, WOOD, WITH 14.5M MAST ARM
  - EXISTING LIGHT POLE
  - EXISTING LIGHTING CONTROLLER
  - ComEd SERVICE POLE
  - LIGHT POLE, WOOD, FOR SUPPORT
  - TEMPORARY WOOD POLE TO BE REMOVED

REVISIONS	
NAME	DATE

DRAWING No. E-28

ILLINOIS DEPARTMENT OF TRANSPORTATION

US RTE 6 FROM I-294 TO IL RTE 1

SINGLE LINE DIAGRAM  
TEMPORARY LIGHTING  
SHEET '2' OF '2'

DRAWN BY S.S./W.S.  
CHECKED BY C.K./H.S.

DATE 01/28/09