



F.A.U. RTE.	SECTION	COUNTY	TOTAL SHEETS	SHEET NO.
351	3277R	COOK	541	366
STA.		TO STA.		
FED. ROAD DIST. NO.		ILLINOIS FED. AID PROJECT		

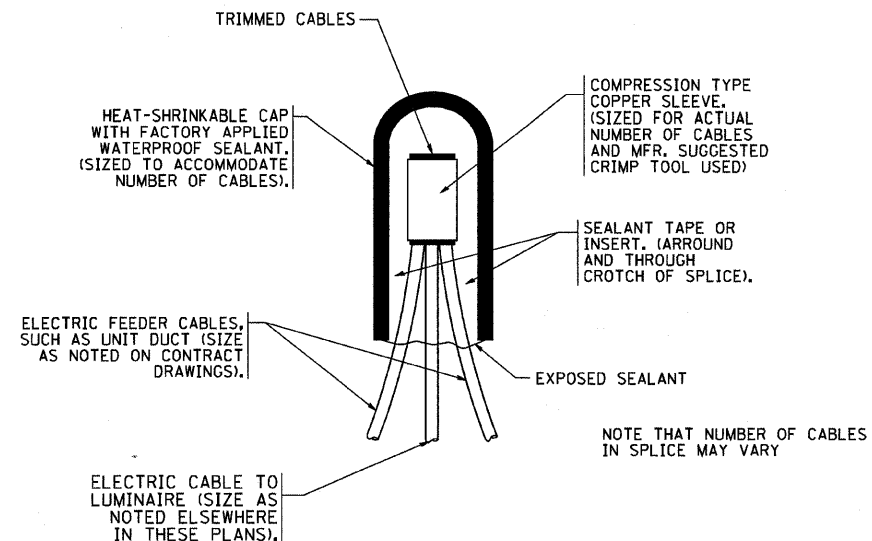


TYPICAL SPLICE DETAIL

N.T.S.

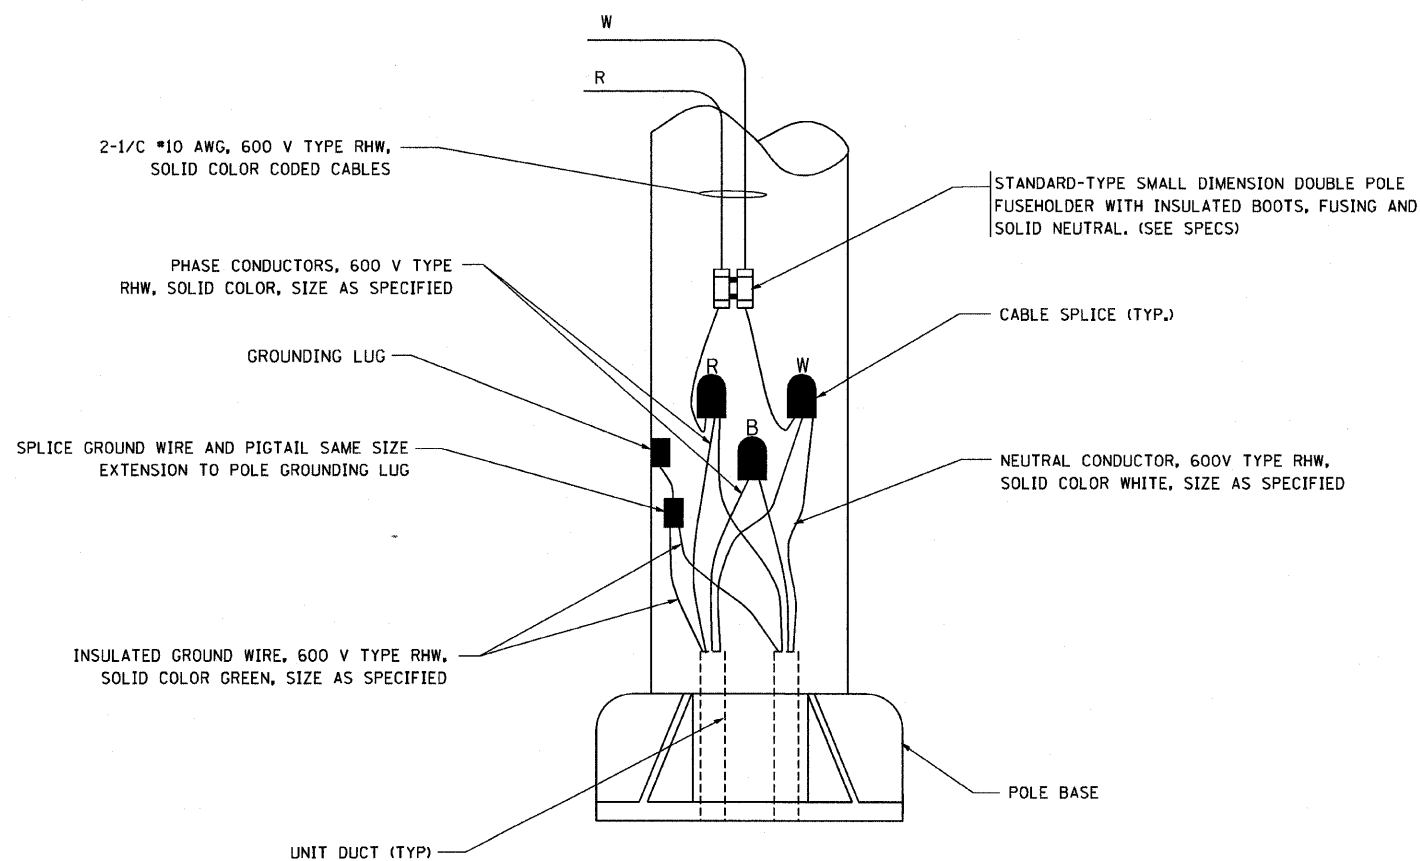

POLE WIRING DETAIL

N.T.S.

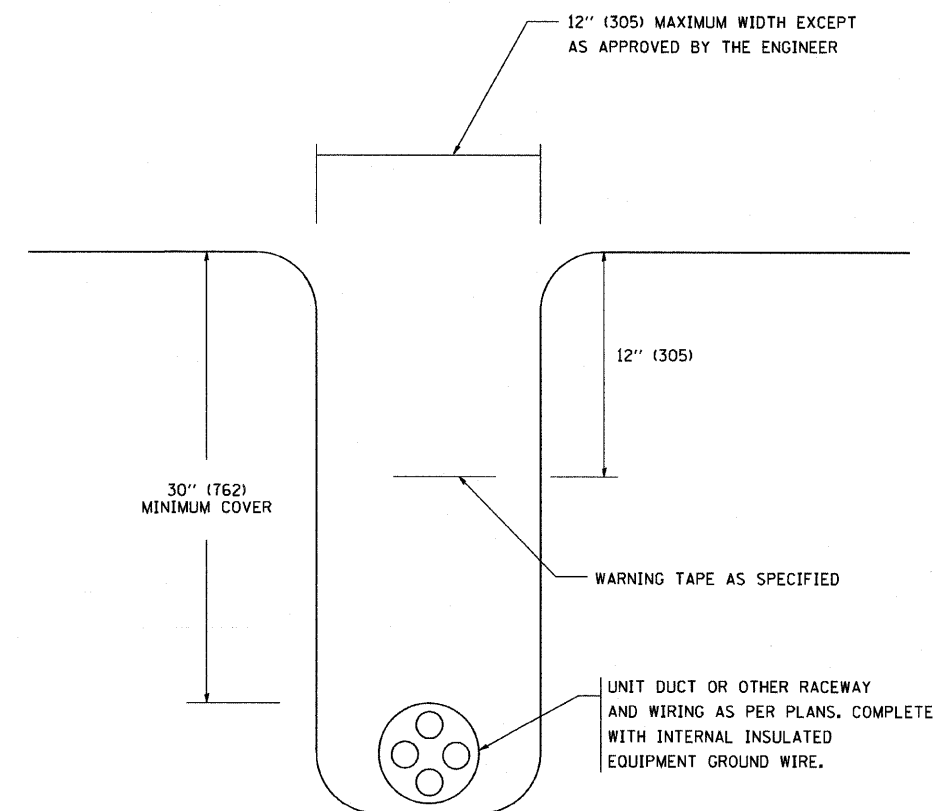

TYPICAL WIRING IN TRENCH DETAIL

N.T.S.

PLOT DATE = 4/18/2007  
 FILE NAME = K:\projects\104702.dgn  
 PLOT SCALE = 0.500000  
 USER NAME = bboard01

REVISIONS	
NAME	DATE
	08/08/03

ILLINOIS DEPARTMENT OF TRANSPORTATION

MISC. ELECTRICAL DETAILS  
 SHEET A

SCALE: VERT. NONE  
 HORIZ.

DRAWN BY  
 CHECKED BY  
 BE-702