
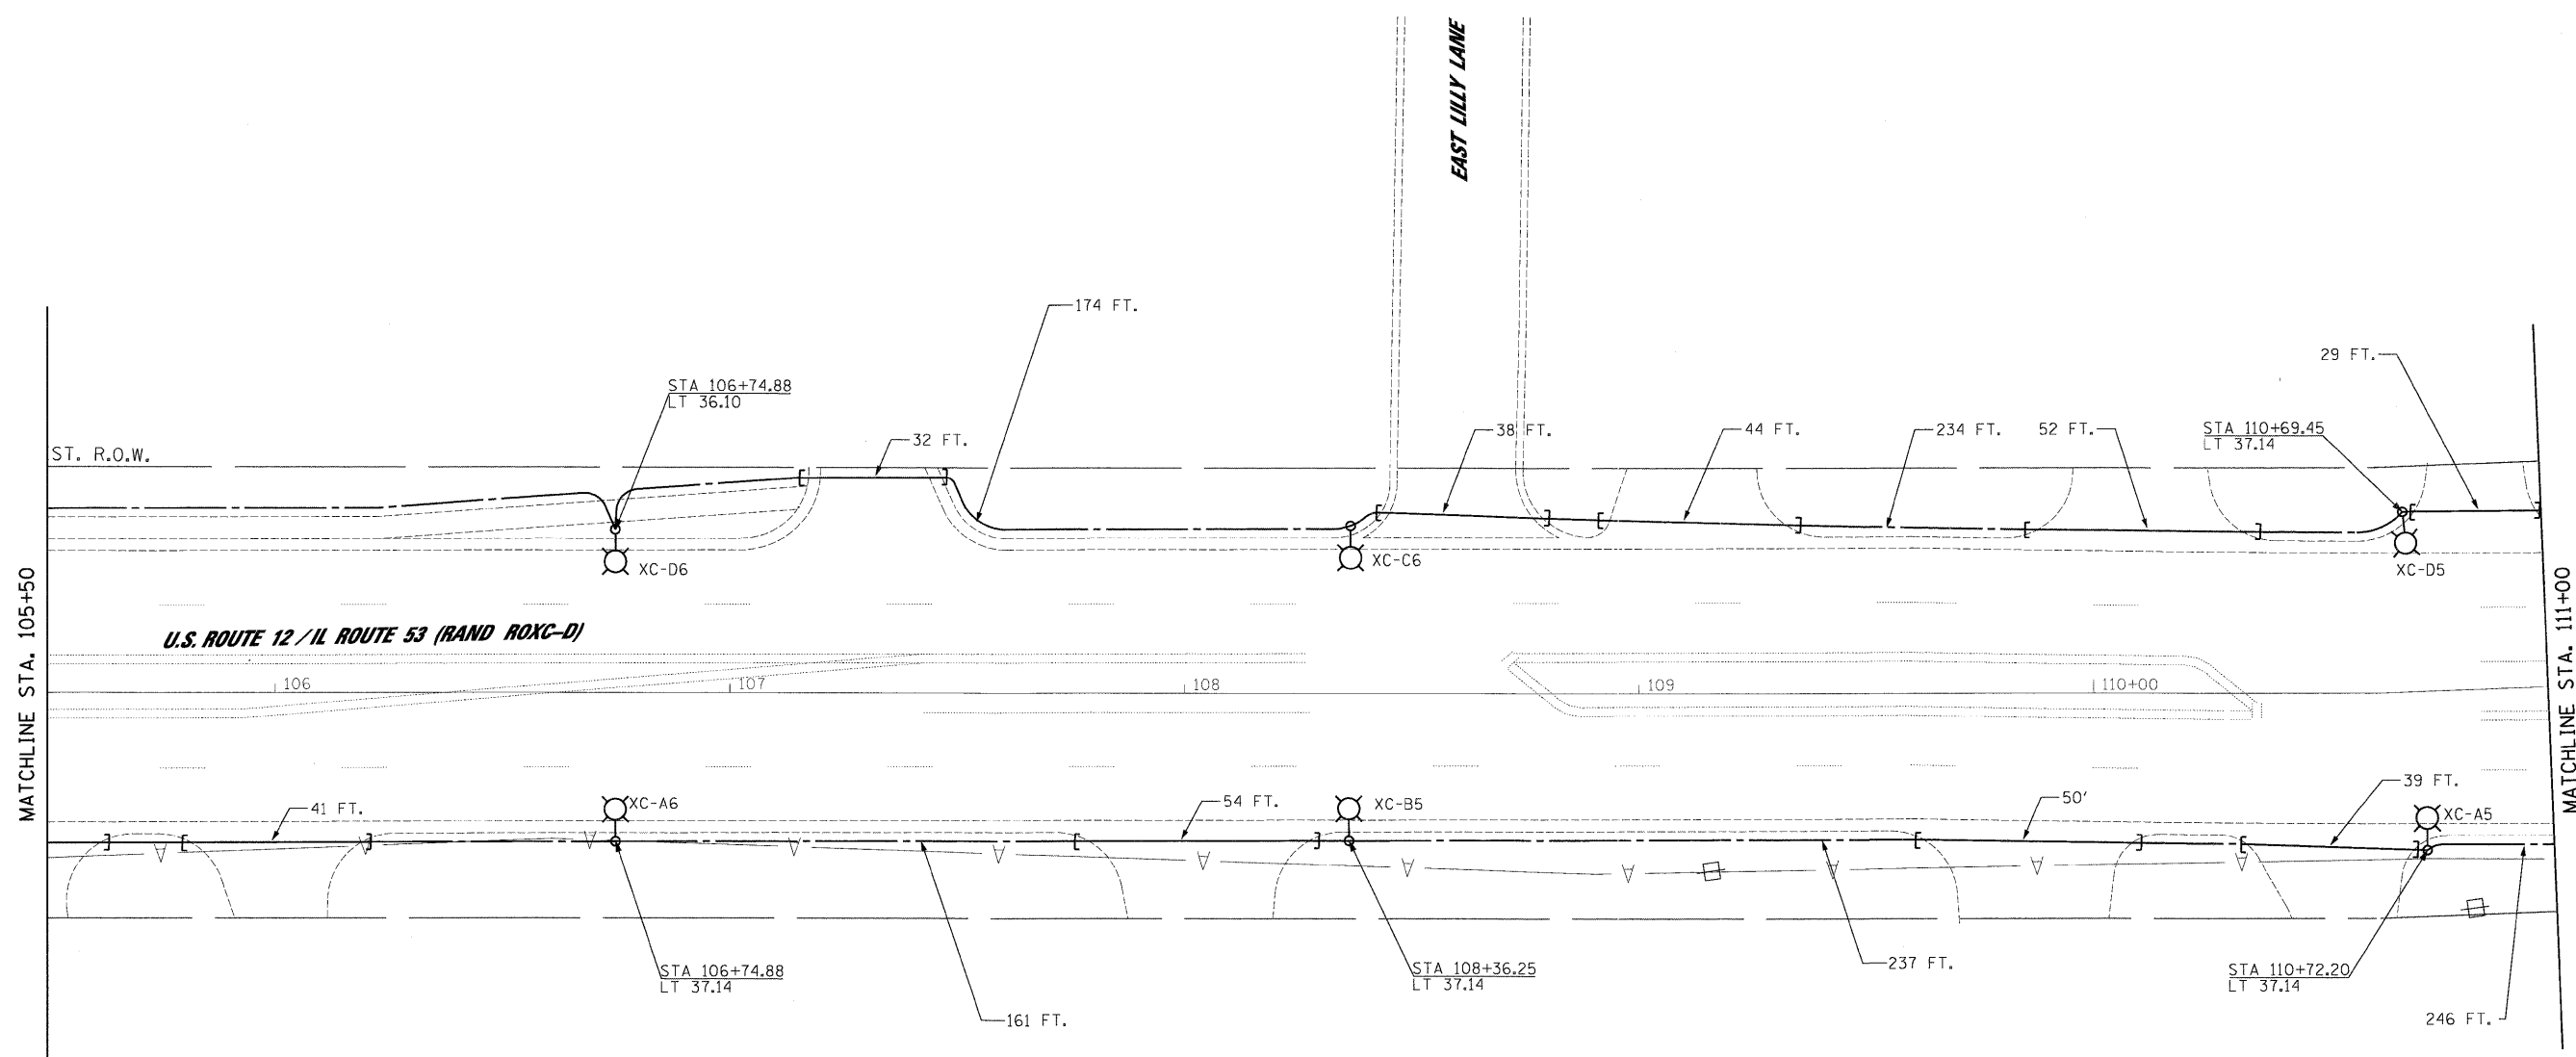


1/27/2009

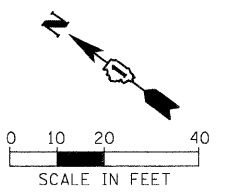

Pl...2009\09\03\208\000\Sheets\Lighting Plan_03.Rand 2.dgn

FILE NAME = Lighting Plan_03.Rand 2.dgn	USER NAME = #USER#	DESIGNED - HS	REVISED -
		DRAWN - MJO	REVISED -
	PLOT SCALE = #SCALE#	CHECKED - CDS	REVISED -
	PLOT DATE = 1/27/2009	DATE - 1/22/2009	REVISED -

**STATE OF ILLINOIS
DEPARTMENT OF TRANSPORTATION**

PROPOSED LIGHTING PLAN			
SCALE: 1"=20'	SHEET NO.	OF	SHEETS
	STA. 105+50	TO	STA. 111+00

JACOBS		ONE NORTH FRANKLIN CHICAGO IL, 60606 312-251-3000		
F.A.P. RTE. 334	SECTION 2008-08-3I	COUNTY COOK	TOTAL SHEETS 80	SHEET NO. 47
FED. ROAD DIST. NO.		ILLINOIS FED. AID PROJECT		
CONTRACT NO. 60F87				