
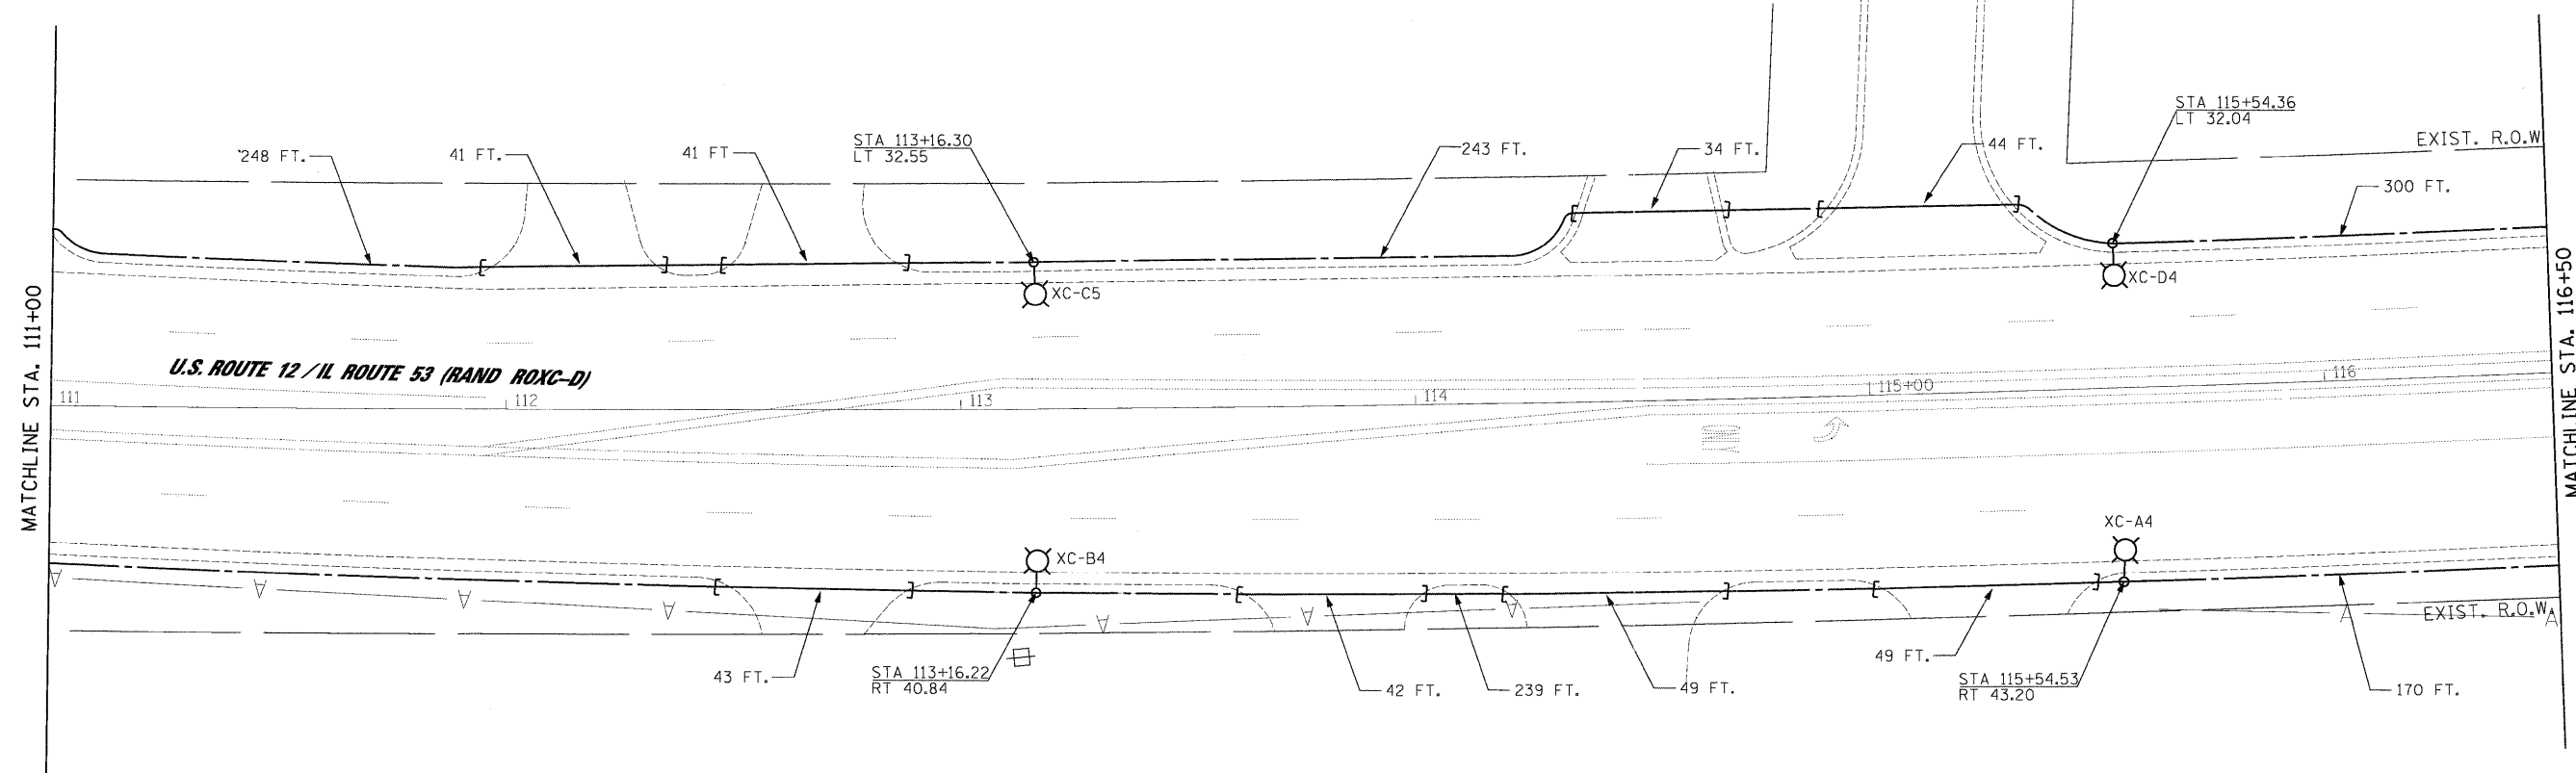


1/27/2009

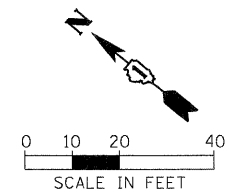

P:\2009\C905700\CADD\Sheets\Lighting Plan_04_Rand 3.dgn

FILE NAME =
Lighting Plan_04_Rand 3.dgn

USER NAME = #USER#
PLOT SCALE = #SCALE#
PLOT DATE = 1/27/2009

DESIGNED - HS
DRAWN - MJO
CHECKED - CDS
DATE - 1/22/2009

REVISED -
REVISED -
REVISED -
REVISED -

**STATE OF ILLINOIS
DEPARTMENT OF TRANSPORTATION**

PROPOSED LIGHTING PLAN
SCALE: 1"=20' SHEET NO. OF SHEETS STA. 111+00 TO STA. 116+50

JACOBS		ONE NORTH FRANKLIN CHICAGO IL, 60606 312-251-3000	
F.A.P. RTE.	SECTION	COUNTY	TOTAL SHEETS
334	2008-08-3I	COOK	80
		SHEET NO. 48	
		CONTRACT NO. 60F87	
FED. ROAD DIST. NO.		ILLINOIS FED. AID PROJECT	