
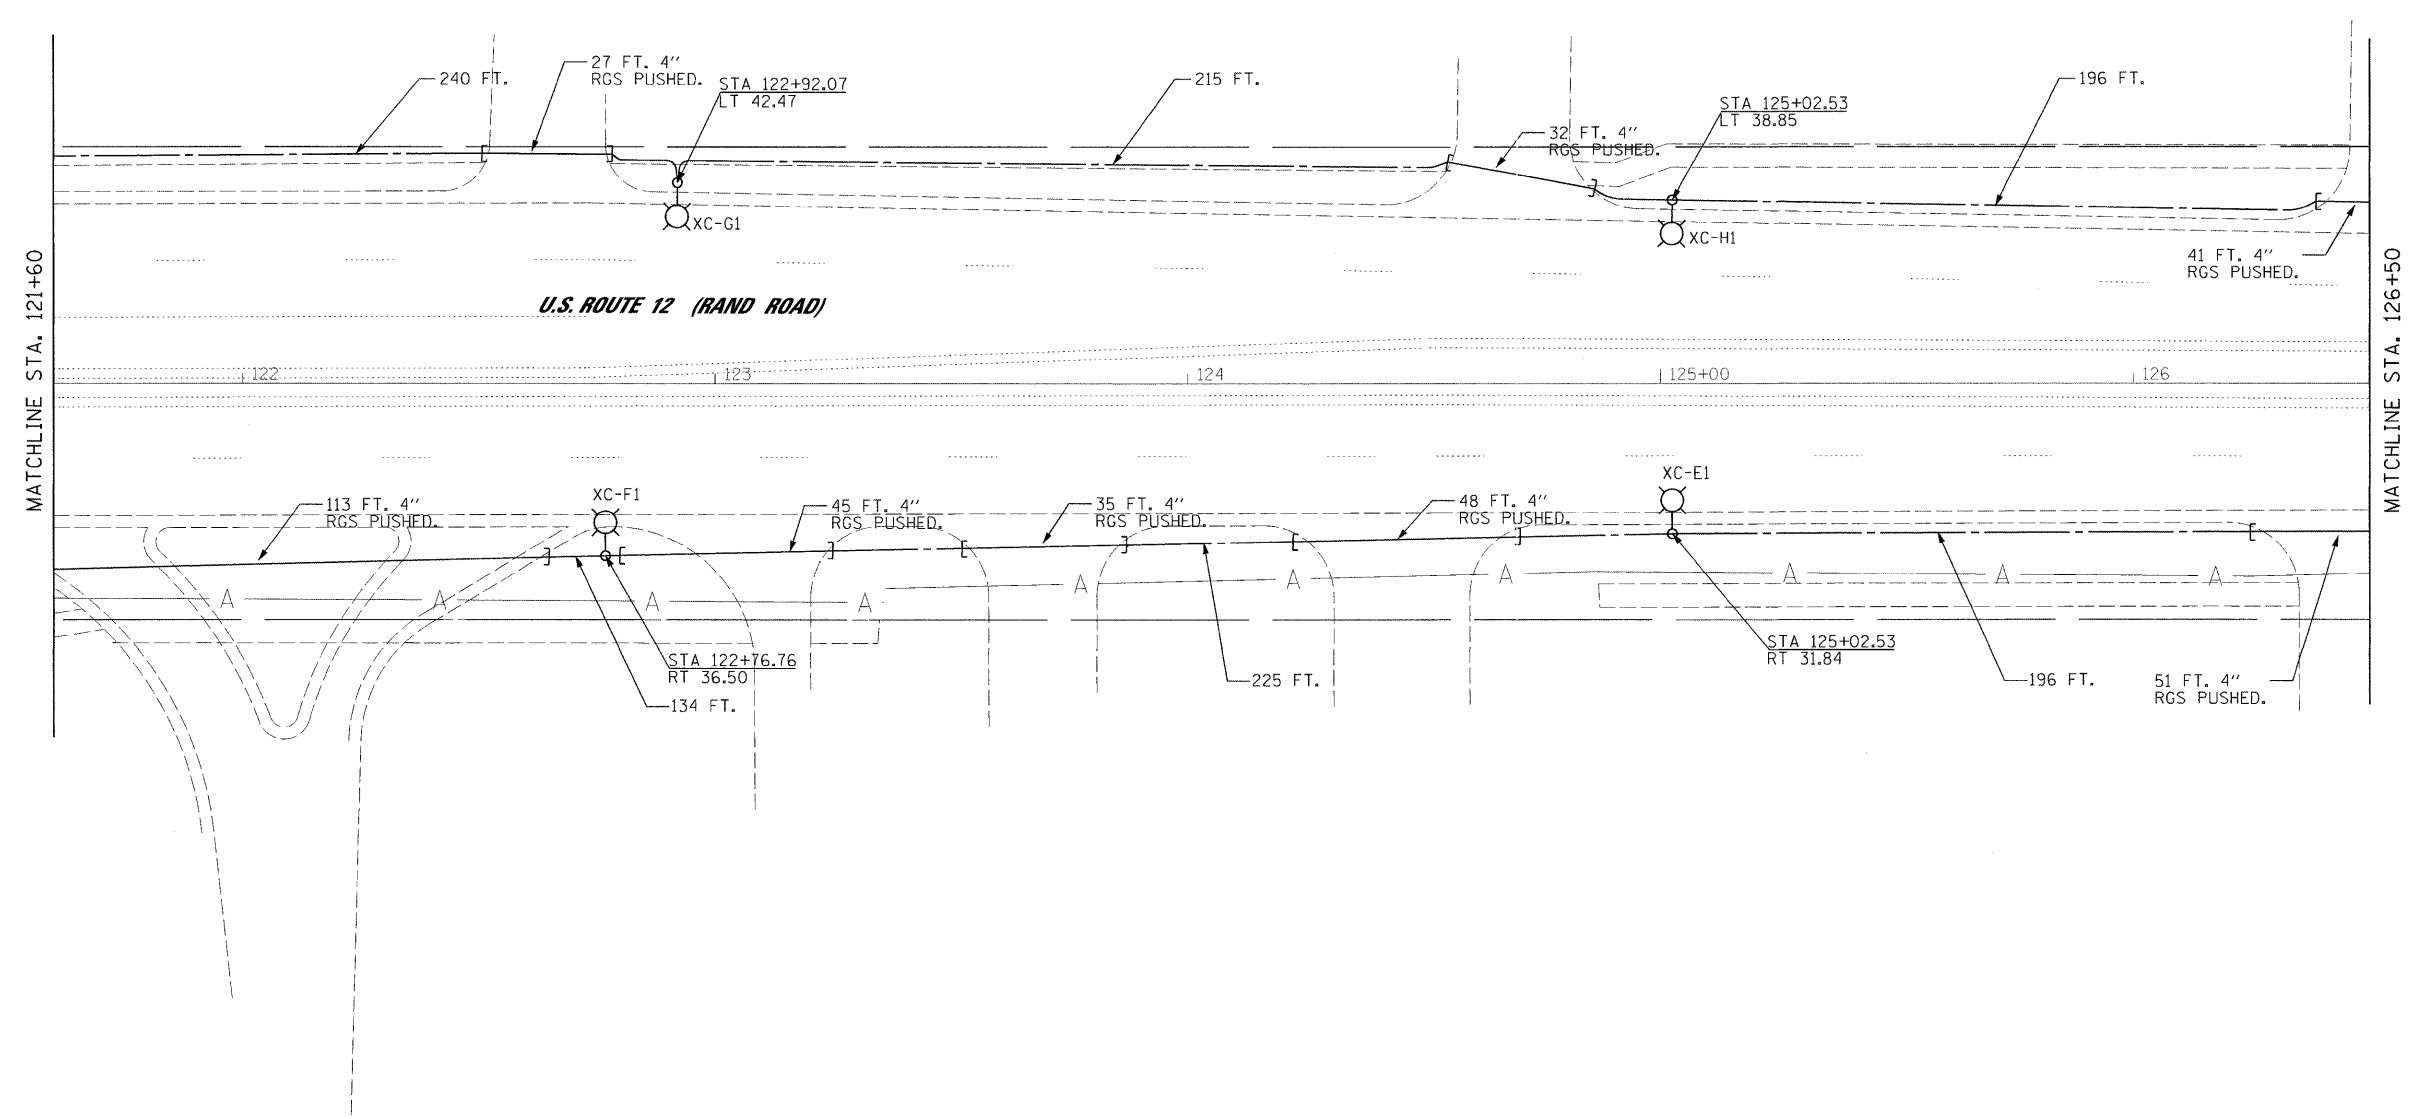


3/4/2009

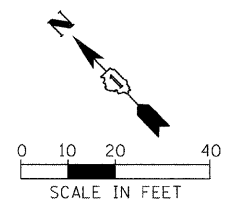

pa\2009\c\93700\cadd\sheet\Lighting Plan-06-Rand 5.dgn

FILE NAME = Lighting Plan-06-Rand 5.dgn
--

USER NAME = #USER#
PLOT SCALE = #SCALE#
PLOT DATE = 3/4/2009

DESIGNED - HS
DRAWN - MJO
CHECKED - CDS
DATE - 1/22/2009

REVISED -
REVISED -
REVISED -
REVISED -

**STATE OF ILLINOIS
DEPARTMENT OF TRANSPORTATION**

PROPOSED LIGHTING PLAN			
SCALE: 1"=20'	SHEET NO.	OF SHEETS	STA. 121+60 TO STA. 126+50

JACOBS				ONE NORTH FRANKLIN CHICAGO IL. 60606 312-251-3000	
F.A.P. RTE. 334	SECTION 2008-08-31	COUNTY COOK	TOTAL SHEETS 81	SHEET NO. 50	CONTRACT NO. 60F87
FED. ROAD DIST. NO.		ILLINOIS FED. AID PROJECT			