
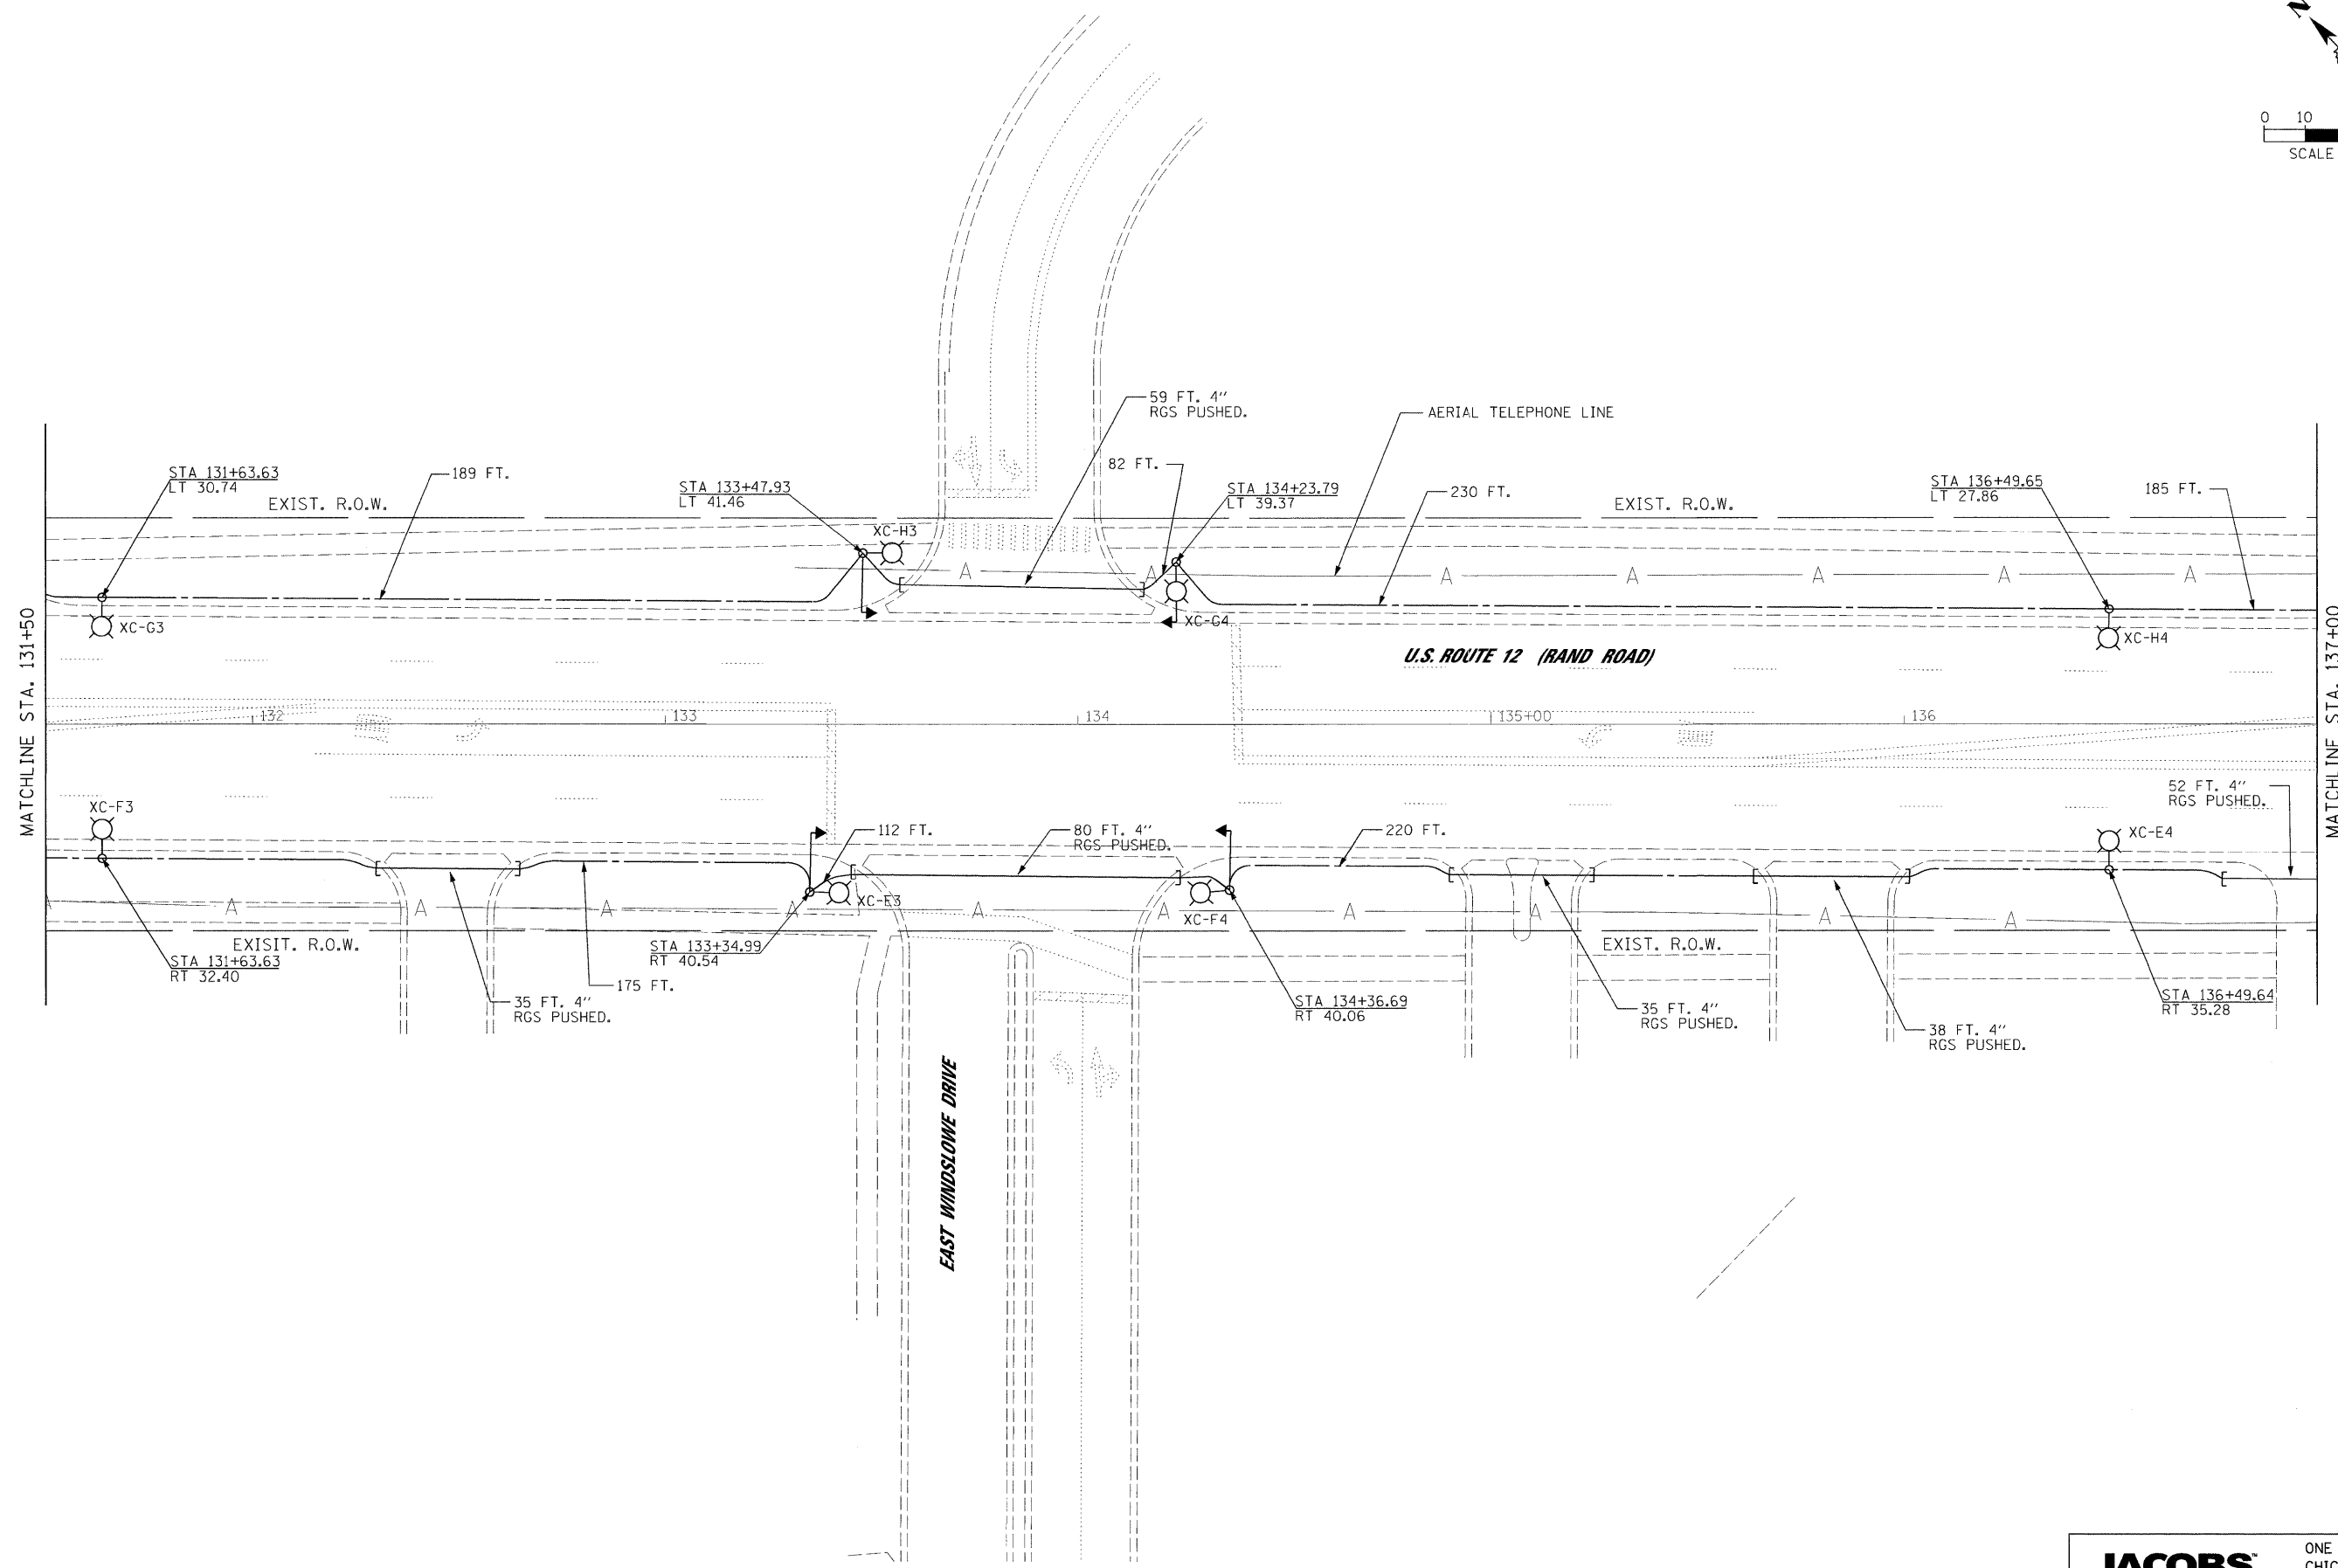


3/4/2009

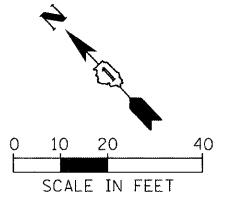

p:\2008\93720\93720\add\sheet\Lighting Plan_08_Rand 7.dgn

FILE NAME =
Lighting Plan_08_Rand 7.dgn

USER NAME = #USER#
DESIGNED - HS
DRAWN - MJO
CHECKED - CDS
DATE - 1/22/2009

REVISI...
REVISI...
REVISI...
REVISI...

STATE OF ILLINOIS
DEPARTMENT OF TRANSPORTATION

PROPOSED LIGHTING PLAN

SCALE: 1"=20'
SHEET NO. OF SHEETS STA. 131+50 TO STA. 137+00

JACOBS		ONE NORTH FRANKLIN CHICAGO IL, 60606 312-251-3000		
F.A.P. RTE. 334	SECTION 2008-08-31	COUNTY COOK	TOTAL SHEETS 81	SHEET NO. 52
FED. ROAD DIST. NO.		ILLINOIS FED. AID PROJECT		
CONTRACT NO. 60F87				