


NOTES:

- COORDINATE WITH TRAFFIC SIGNAL MODERNIZATION PLANS FOR SIDEWALK REMOVAL AND PC CONC SIDEWALK 5 INCH.

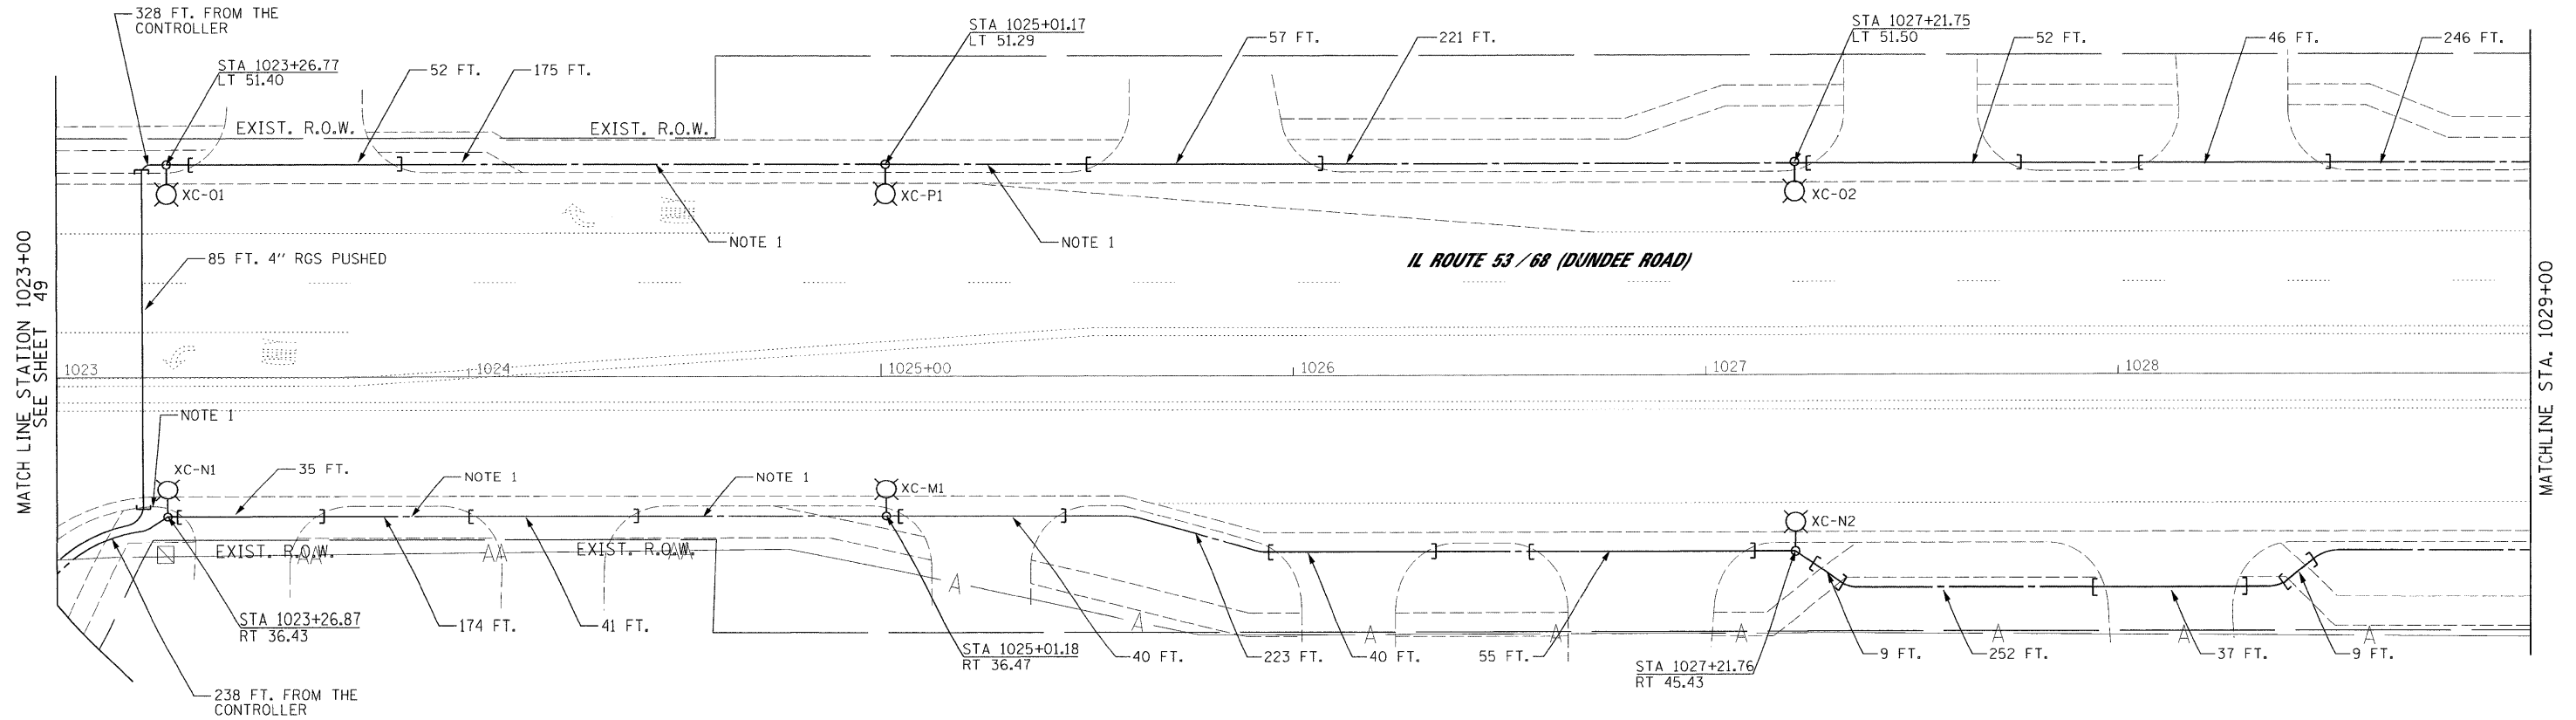

MATCH LINE STATION 1023+00
SEE SHEET 49

MATCHLINE STA. 1029+00

IL ROUTE 53 / 68 (DUNDEE ROAD)

FILE NAME = Lighting Plan_18_Dundee 5.dgn
--

USER NAME = \$USER\$
PLOT SCALE = \$SCALE\$
PLOT DATE = 3/4/2009

DESIGNED - HS
DRAWN - MJO
CHECKED - CDS
DATE - 1/22/2009

REVISED -
REVISED -
REVISED -
REVISED -

**STATE OF ILLINOIS
DEPARTMENT OF TRANSPORTATION**

PROPOSED LIGHTING PLAN

SCALE: 1"=20' SHEET NO. OF SHEETS STA. 1025+00 TO STA. 1030+00

JACOBS		ONE NORTH FRANKLIN CHICAGO IL, 60606 312-251-3000	
F.A.P. RTE. 334	SECTION 2008-08-31	COUNTY COOK	TOTAL SHEETS 81
SHEET NO. 62		CONTRACT NO. 60F87	
FED. ROAD DIST. NO. ILLINOIS FED. AID PROJECT			