
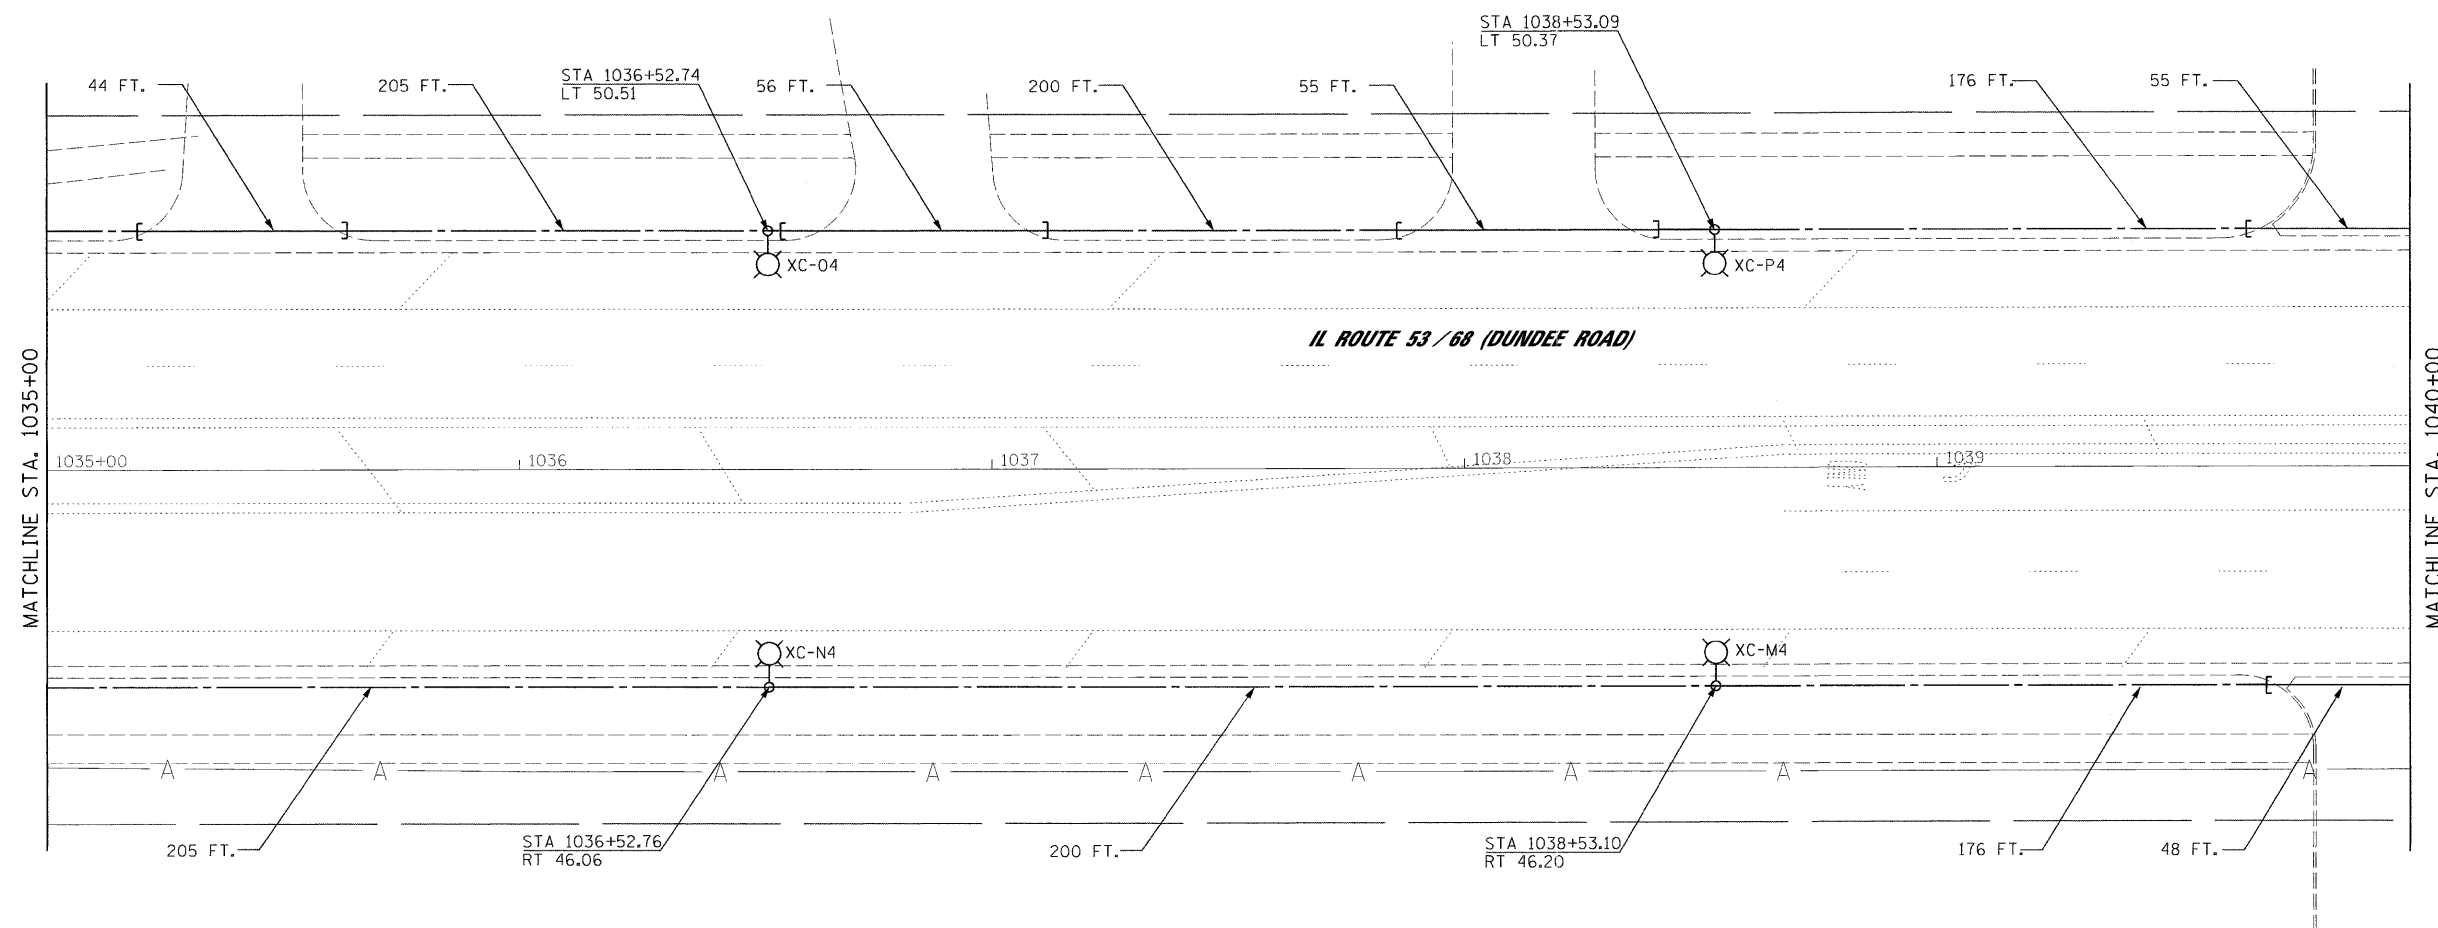


3/4/2009

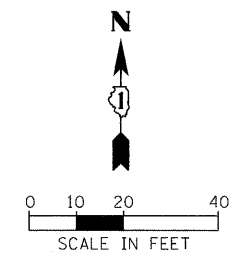

p:\2008\09\03700\Cadd\Sheets\Lighting Plan_20_Dundee 7.dgn

FILE NAME = Lighting Plan_20_Dundee 7.dgn
--

USER NAME = #USER#
PLOT SCALE = \$SCALE\$
PLOT DATE = 3/4/2009

DESIGNED - HS
DRAWN - MJO
CHECKED - CDS
DATE - 1/22/2009

REVISED -
REVISED -
REVISED -
REVISED -

**STATE OF ILLINOIS
DEPARTMENT OF TRANSPORTATION**

PROPOSED LIGHTING PLAN			
SCALE: 1"=20'	SHEET NO.	OF SHEETS	STA. 1035+00 TO STA. 1040+00

JACOBS				ONE NORTH FRANKLIN CHICAGO IL, 60606 312-251-3000	
F.A.P. RTE. 334	SECTION 2008-08-31	COUNTY COOK	TOTAL SHEETS 81	SHEET NO. 64	CONTRACT NO. 60F87
FED. ROAD DIST. NO. ILLINOIS FED. AID PROJECT					