
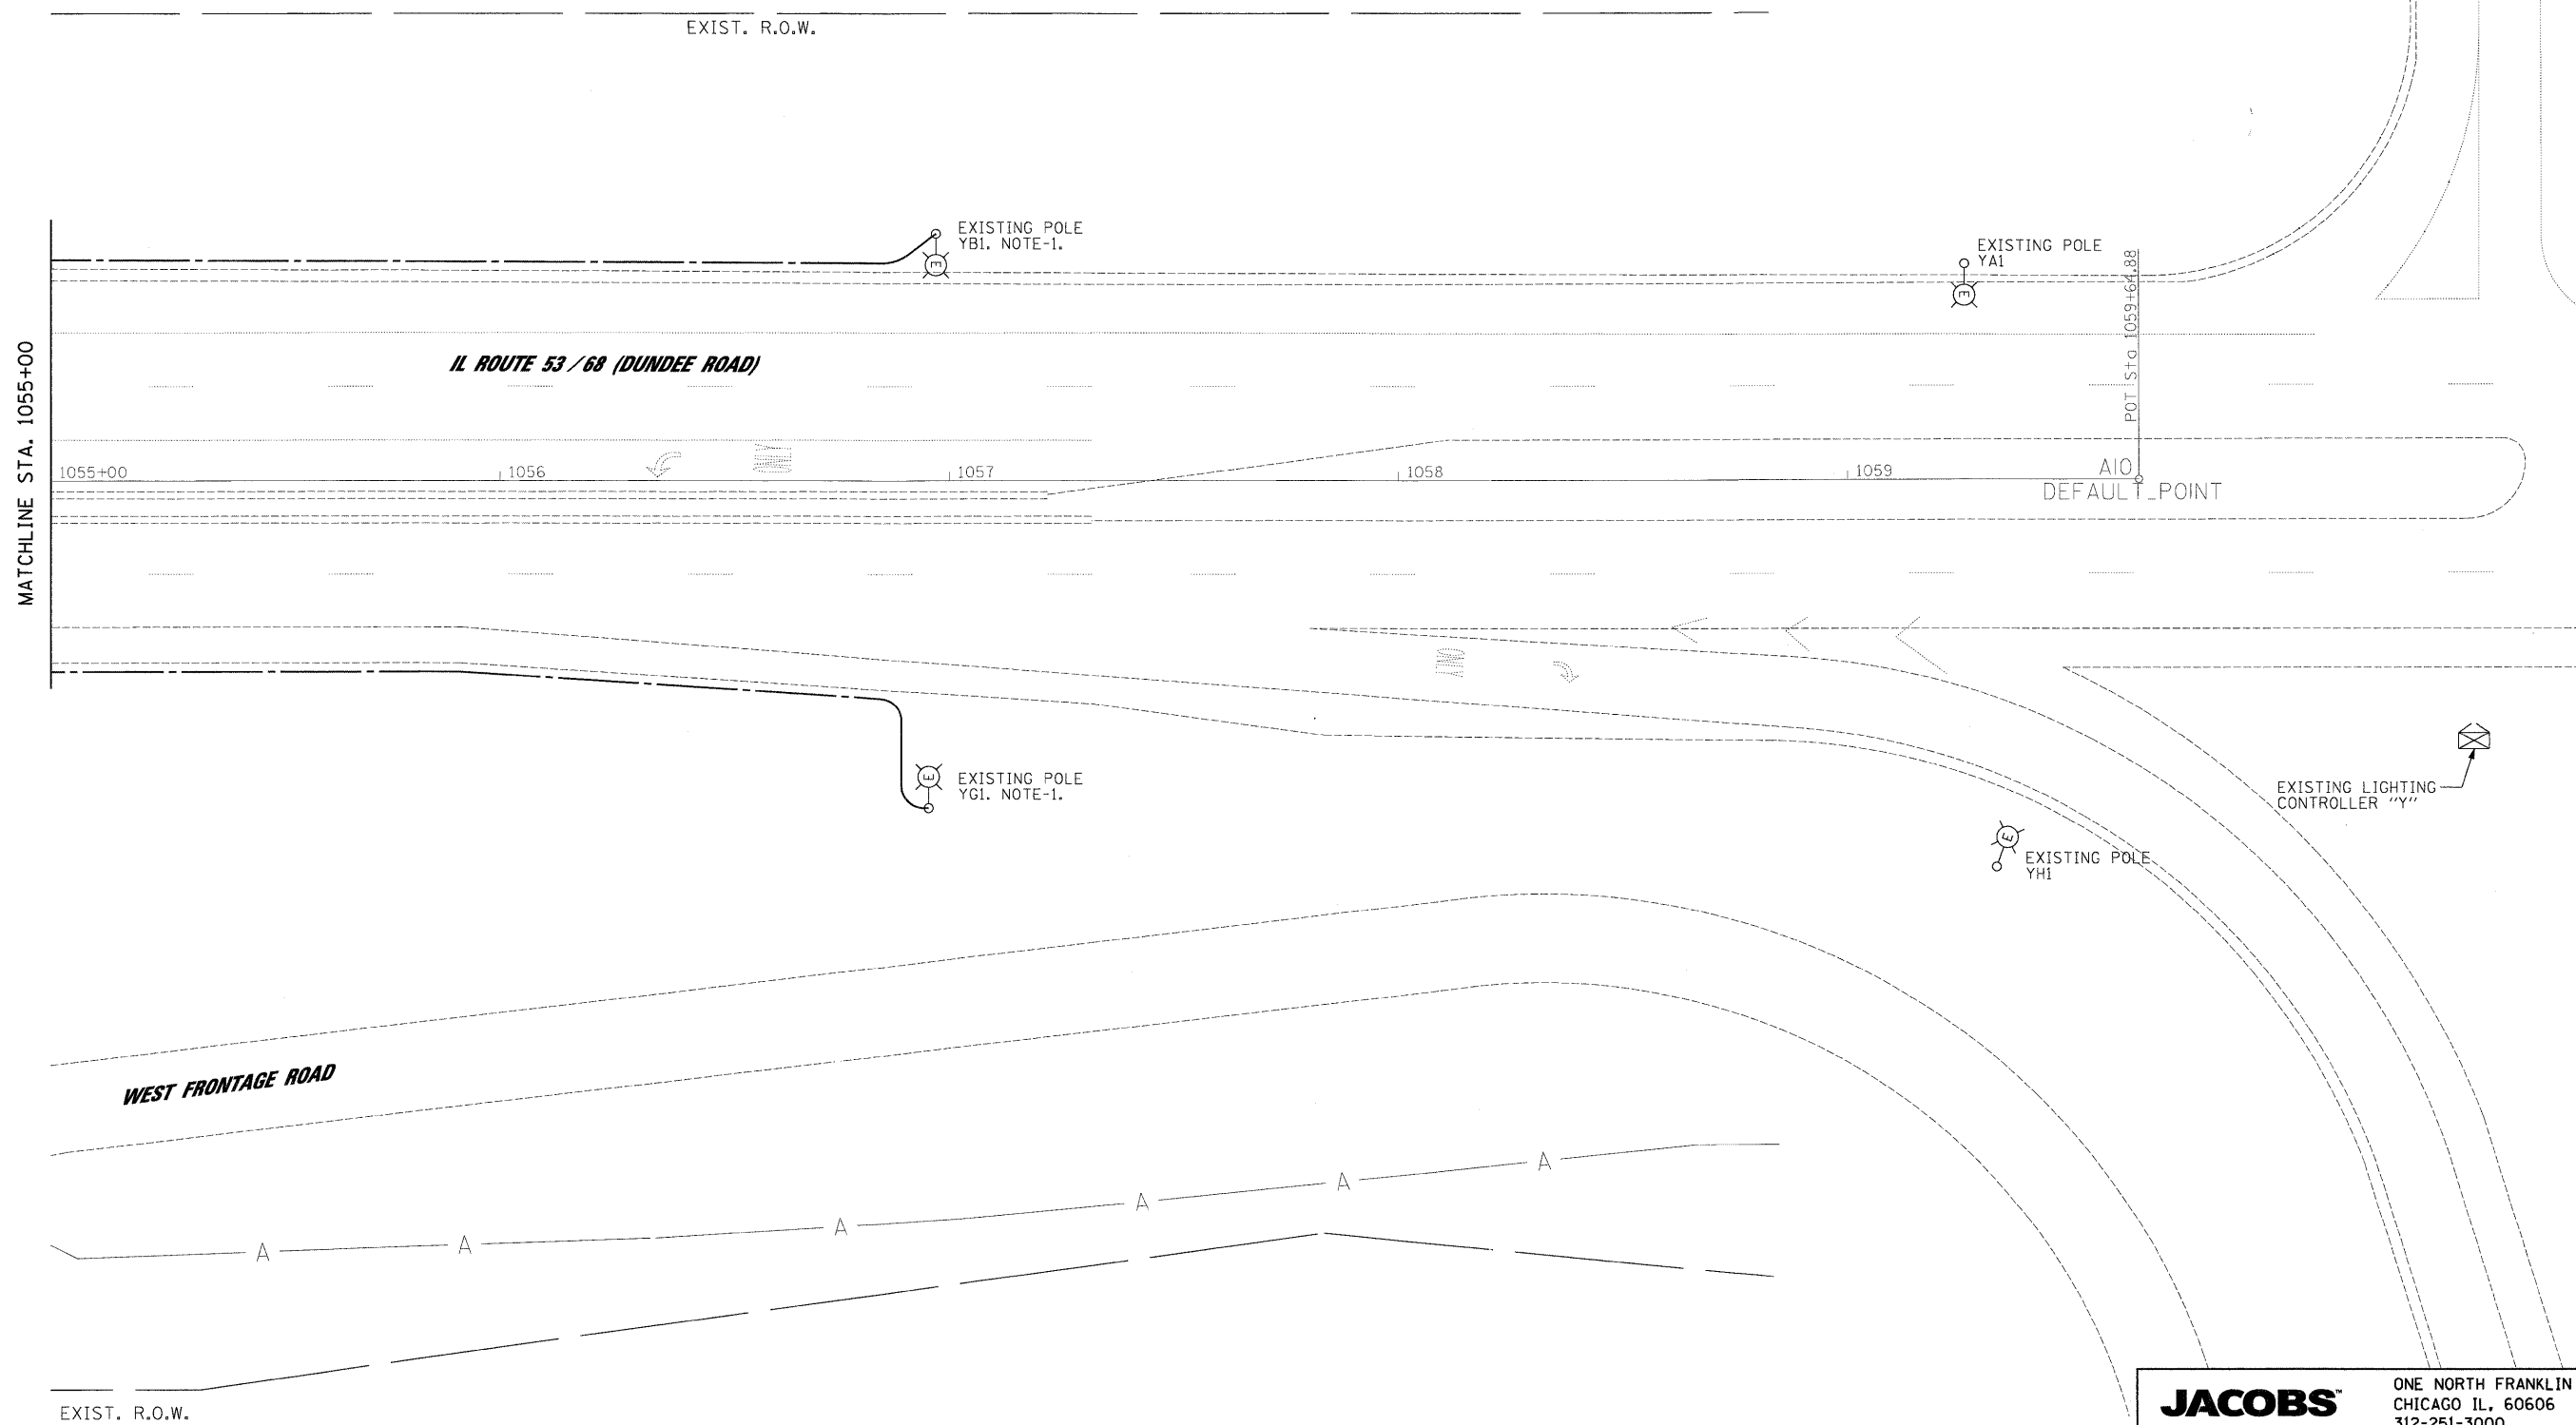


1/27/2009

**NOTES:**

- 1. INTERCEPT EXISTING CIRCUITS WITHIN LIGHT POLE HAND HOLE AND EXTEND WEST ON DUNDEE ROAD TO NEW PROPOSED STREET LIGHTING.

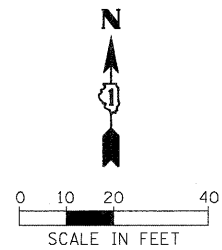

FILE NAME =  
Lighting Plan\_24\_Dundee 11.dgn

USER NAME = #USER#  
DESIGNED - HS  
DRAWN - MJO  
CHECKED - CDS  
DATE - 1/22/2009

REVISED -  
REVISED -  
REVISED -  
REVISED -

**STATE OF ILLINOIS  
DEPARTMENT OF TRANSPORTATION**

**PROPOSED LIGHTING PLAN**

SCALE: 1"=20' SHEET NO. OF SHEETS STA. 1055+00 TO STA. 1060+00

**JACOBS** ONE NORTH FRANKLIN  
CHICAGO IL, 60606  
312-251-3000

F.A.P. RTE.	SECTION	COUNTY	TOTAL SHEETS	SHEET NO.
334	2008-08-3I	COOK	80	68
CONTRACT NO. 60F87				
FED. ROAD DIST. NO. ILLINOIS FED. AID PROJECT				

P:\2009\09\01\0700\CADD\Sheets\Lighting Plan\_24\_Dundee 11.dgn