




F.A.P. RTE.	SECTION	COUNTY	TOTAL SHEETS	SHEET NO.
334	2008-08-31	COOK	80	79
STA.		TO STA.		
FED. ROAD DIST. NO.	ILLINOIS	FED. AID PROJECT		

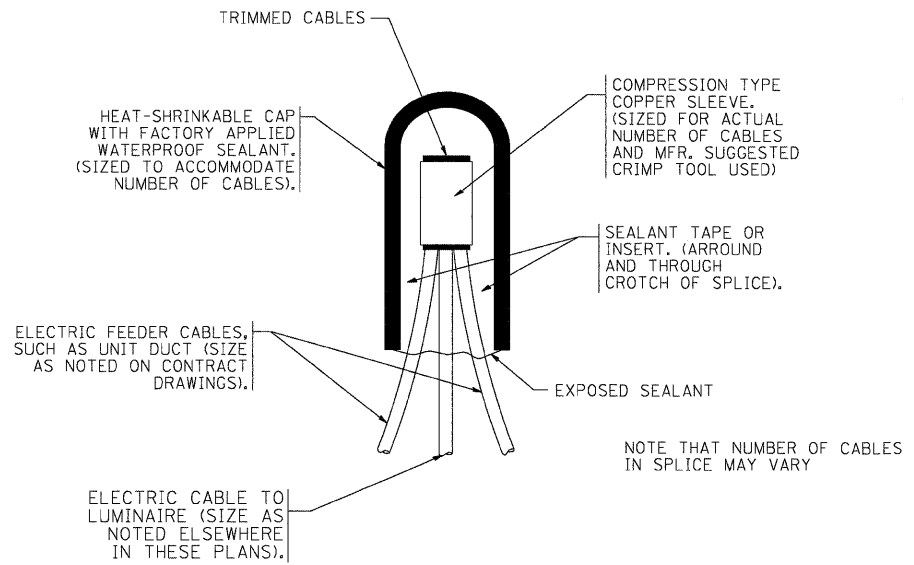

TYPICAL SPLICE DETAIL
N.T.S.

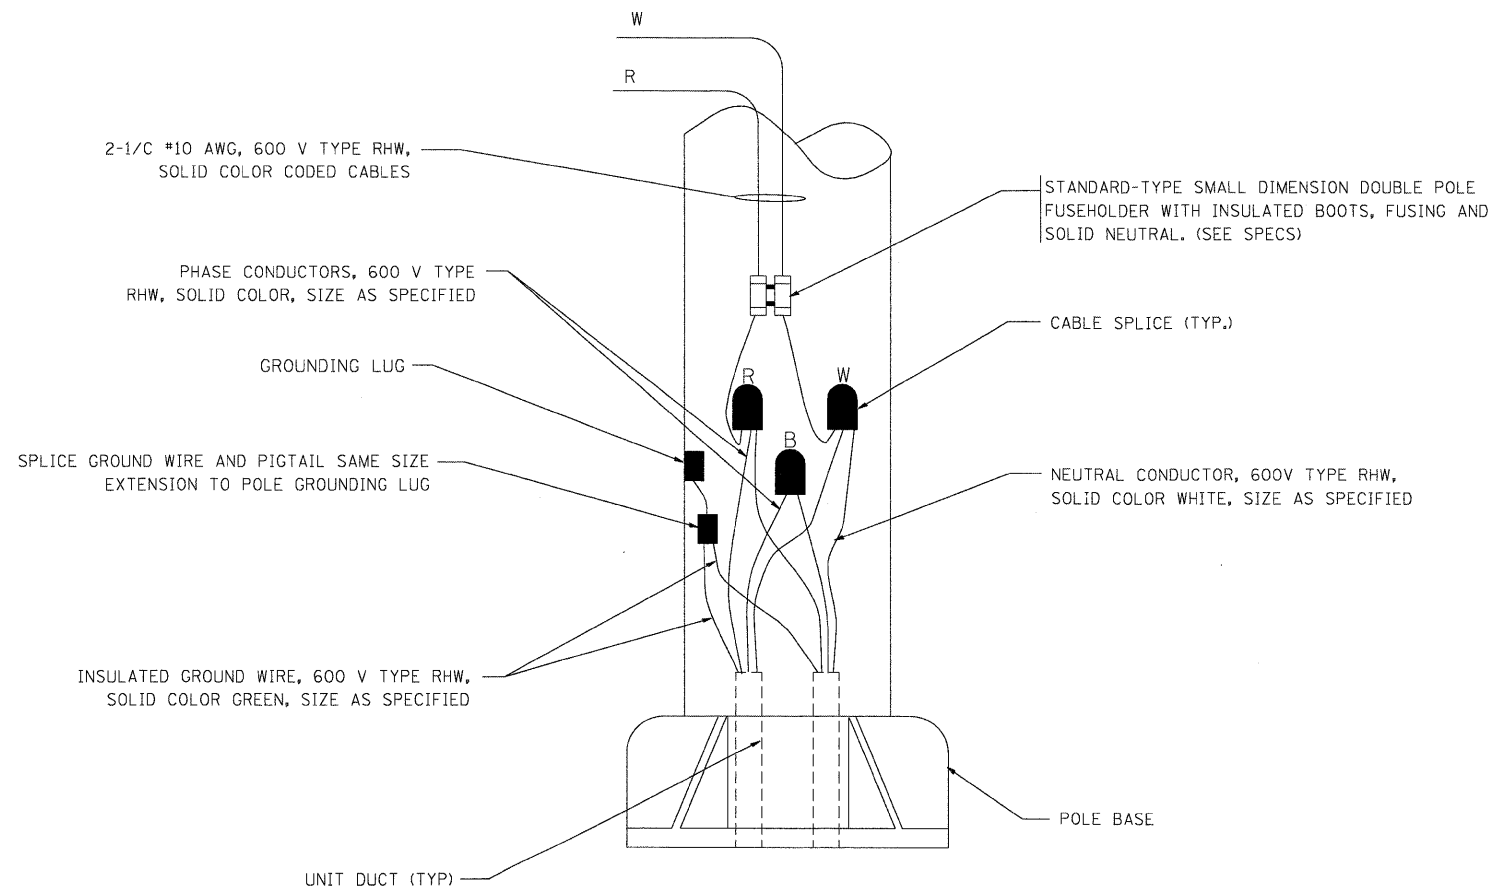

POLE WIRING DETAIL
N.T.S.

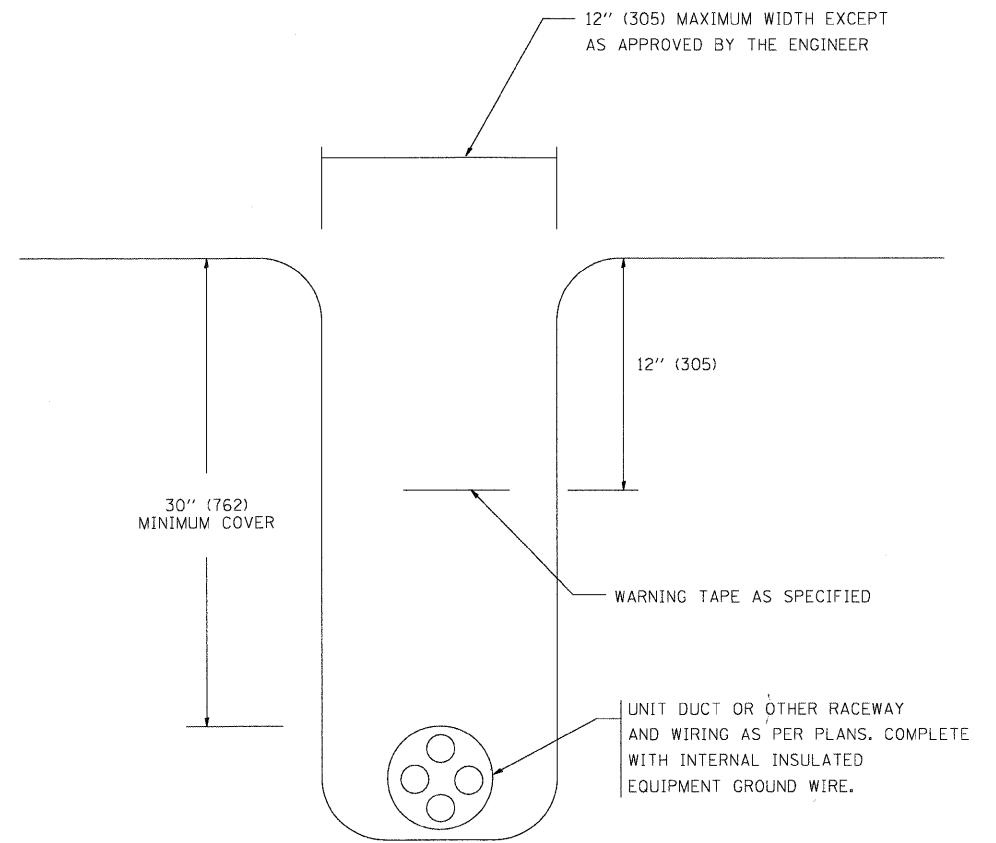

TYPICAL WIRING IN TRENCH DETAIL
N.T.S.

REVISIONS	
NAME	DATE
	08/08/03

ILLINOIS DEPARTMENT OF TRANSPORTATION

MISC. ELECTRICAL DETAILS
SHEET A

SCALE: VERT. NONE
HORIZ.

DRAWN BY
CHECKED BY

FILE NAME = Lighting Plan_35_Detail-8E702.dgn	USER NAME = #USER#	DESIGNED -	REVISED -
	PLDT SCALE = #SCALE#	DRAWN -	REVISED -
	PLDT DATE = 1/27/2009	CHECKED -	REVISED -
		DATE = 1/22/2009	REVISED -

STATE OF ILLINOIS
DEPARTMENT OF TRANSPORTATION

MISC. ELECTRICAL DETAILS
SHEET A
BE-702

SCALE: N.T.S. SHEET NO. OF SHEETS STA. - TO STA. -

F.A.P. RTE.	SECTION	COUNTY	TOTAL SHEETS	SHEET NO.
334	2008-08-31	COOK	80	79
CONTRACT NO. 60F87				
FED. ROAD DIST. NO.	ILLINOIS	FED. AID PROJECT		

1/27/2009

F:\2009\12\13\2009\0000\Sheet\Lighting Plan_35_Detail-8E702.dgn