



F.A. RTE.	SECTION	COUNTY	TOTAL SHEETS	SHEET NO.
337	20R-6	LAKE	149	84
STA.	TO STA.			
FED. ROAD DIST. NO.	ILLINOIS FED. AID PROJECT			

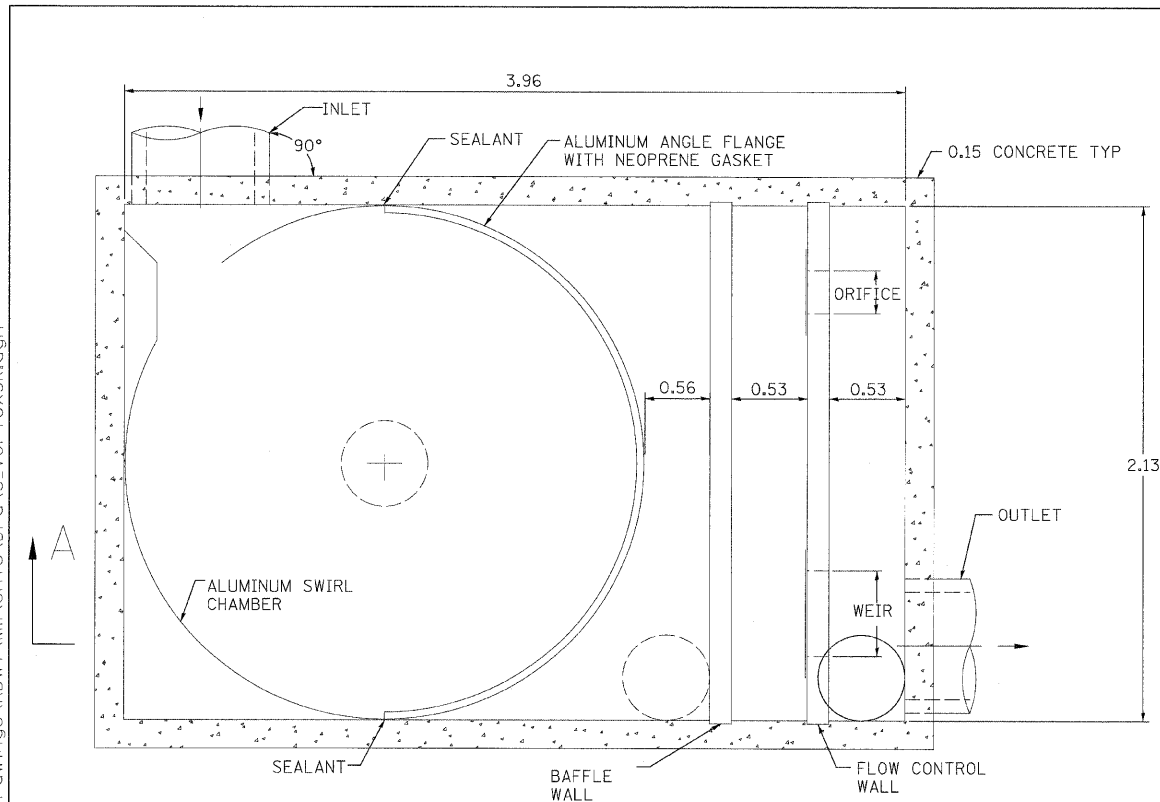

PLAN VIEW B - B

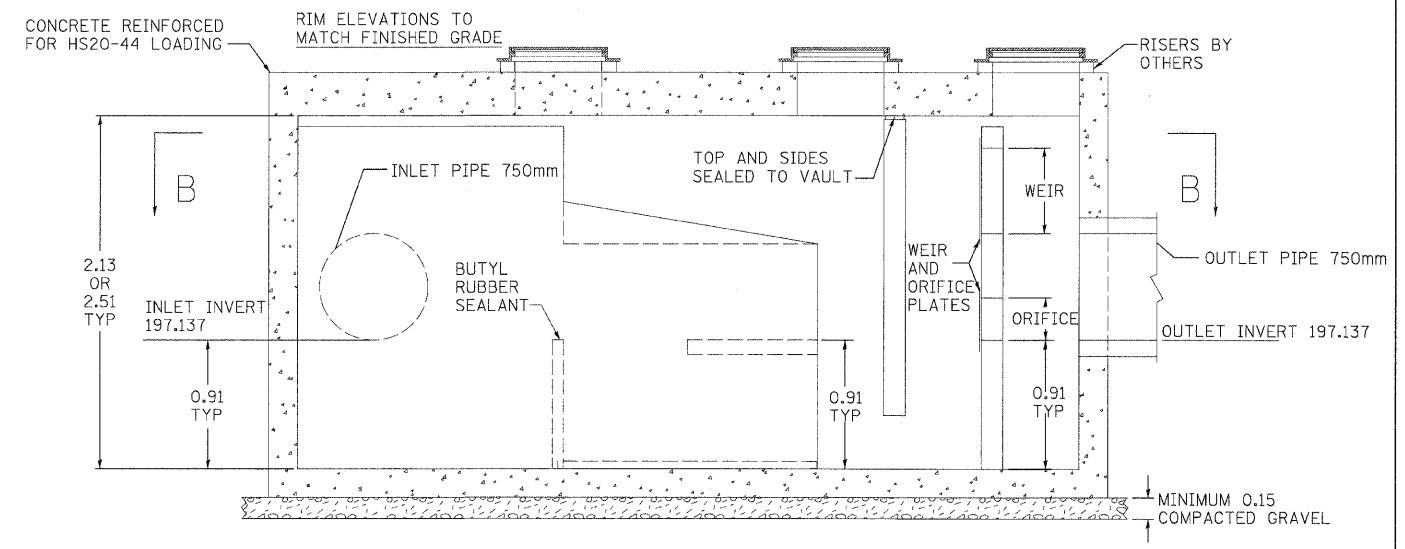

SECTION A - A

NOTES:

1. SWTS INVERTS IN AND OUT SHALL BE AT THE SAME ELEVATION
2. INLET PIPE MUST BE PERPENDICULAR TO THE STRUCTURE
3. PIPE ORIENTATION MAY VARY; SEE SITE PLAN FOR SIZE AND LOCATION
4. DIMENSIONS ARE IN METERS

P:\Lisle\ID0T\9171.A0\Drawings\RDWY\MIN\Shts\Dr.d\S_VortexB.dgn
 PDF(Grey_Large).pht
 5:16:25 PM
 2/5/2009
 tkoeppen(Rdwy_Lisle)



REVISIONS	
NAME	DATE

ILLINOIS DEPARTMENT OF TRANSPORTATION
 FAP ROUTE 337 (IL ROUTE 22)
 VORTEX MANHOLE DETAIL
 STATION 104+956.316

SCALE: NOT TO SCALE
 DATE: 1/28/2009
 DRAWN BY: YM
 CHECKED BY: DTH/AAC