


F.A.I. RTE.	SECTION	COUNTY	TOTAL SHEETS	SHEET NO.
57	2021.1B-R	COOK	101	027
STA.		TO STA.		
FED. ROAD DIST. NO. 1		ILLINOIS FED. AID PROJECT		
CONTRACT NO. 62532				

**REMOVAL NOTES**


- A - REMOVE H.P.S.V. LUMINAIRE AND MAST ARM
- B - REMOVE POLE, CITY STEEL
- C - REMOVE FOUNDATION
- D - EXISTING POLE TO REMAIN
- E - EXISTING CABLE TO BE REMOVED
- F - EXISTING CONDUIT TO BE REMOVED
- G - EXISTING CONTROLLER AND FOUNDATION TO BE REMOVED

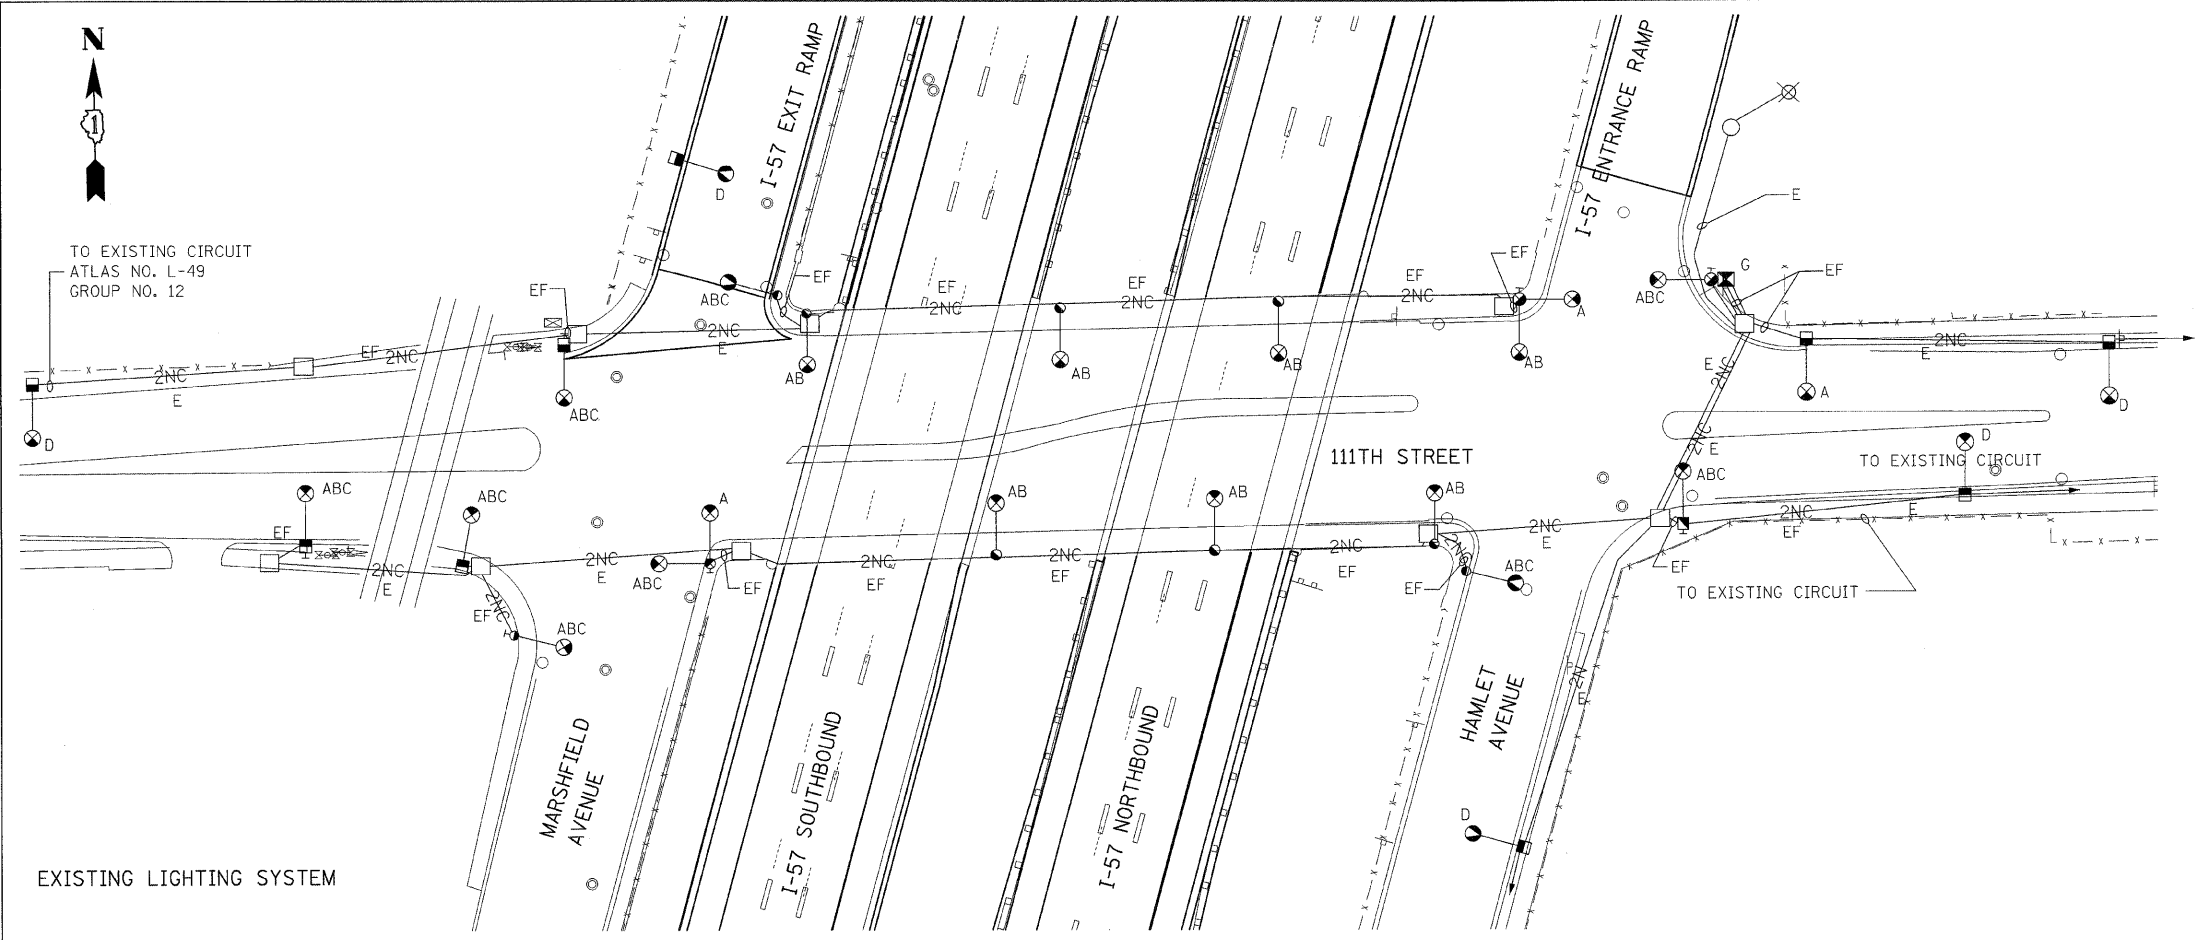

EXISTING LIGHTING SYSTEM

**INSTALLATION NOTES**

- H - INSTALL 400W H.P.S.V. LUMINAIRE AND 12' MAST ARM
- I - INSTALL POLE, CITY STEEL, ANCHOR BASE, SIZE AS INDICATED
- J - INSTALL NEW CONCRETE FOUNDATION
- K - CONDUIT ATTACHED TO STRUCTURE (NOTE 6)
- EM - CONDUIT EMBEDDED IN BARRIER WALL
- T - CONDUIT IN TRENCH
- L - INSTALL POLE CITY ALUMINUM, ANCHOR BASE, SIZE AS INDICATED
- M - INSTALL 400W HPSV LUMINAIRE & DAVIT ARM

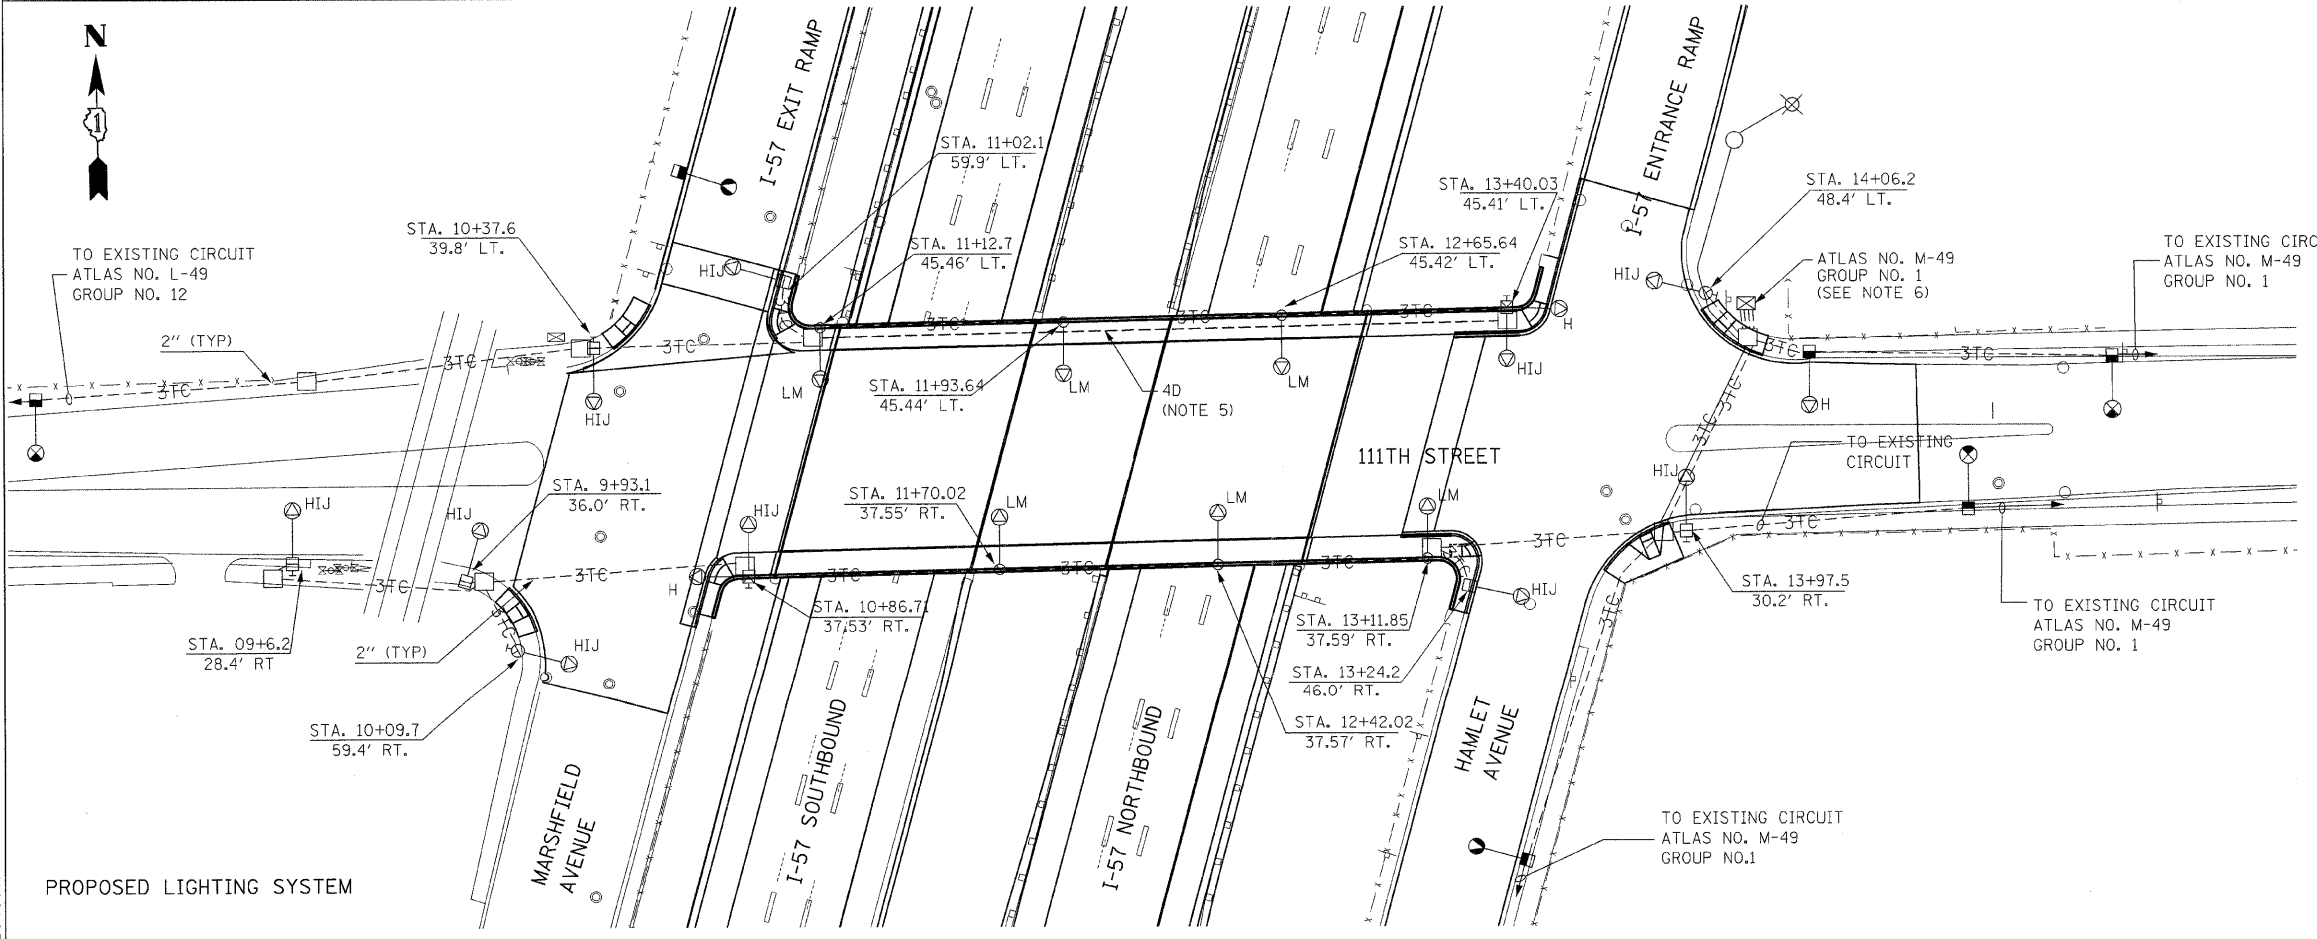

PROPOSED LIGHTING SYSTEM

**NOTE:**  
FOR LEGEND AND NOTES REFER TO DRAWING NO. E-1.

REVISIONS	
NAME	DATE

ILLINOIS DEPARTMENT OF TRANSPORTATION  
111TH STREET OVER  
F.A.I ROUTE 57 (INTERSTATE 57)

CITY OF CHICAGO  
LIGHTING PLAN

SCALE: 1" = 30'  
DATE: 01/16/09

DRAWN BY: ACL  
CHECKED BY: PR

**TENG**  
TENG & ASSOCIATES, INC.  
ENGINEERS/ARCHITECTS/PLANNERS  
205 N. MICHIGAN AVE. CHICAGO, IL 60601  
TELEPHONE: 312/616-0000

\TPO0014E.DGN, \RDWOOD\_6.DGN, \PMD005M.DGN, \SEH000PT.DGN, \111TH ST BORDELDON, \VALTOONR.DGN, \TPO0074E.DGN, \RDWOOD3B.DGN, \RDWOOD3E.DGN, \RDWOOD3L.DGN, \RDWOOD3R.DGN, \RDWOOD3S.DGN, \RDWOOD3T.DGN, \RDWOOD3U.DGN, \RDWOOD3V.DGN, \RDWOOD3W.DGN, \RDWOOD3X.DGN, \RDWOOD3Y.DGN, \RDWOOD3Z.DGN, \RDWOOD4A.DGN, \RDWOOD4B.DGN, \RDWOOD4C.DGN, \RDWOOD4D.DGN, \RDWOOD4E.DGN, \RDWOOD4F.DGN, \RDWOOD4G.DGN, \RDWOOD4H.DGN, \RDWOOD4I.DGN, \RDWOOD4J.DGN, \RDWOOD4K.DGN, \RDWOOD4L.DGN, \RDWOOD4M.DGN, \RDWOOD4N.DGN, \RDWOOD4O.DGN, \RDWOOD4P.DGN, \RDWOOD4Q.DGN, \RDWOOD4R.DGN, \RDWOOD4S.DGN, \RDWOOD4T.DGN, \RDWOOD4U.DGN, \RDWOOD4V.DGN, \RDWOOD4W.DGN, \RDWOOD4X.DGN, \RDWOOD4Y.DGN, \RDWOOD4Z.DGN, \RDWOOD5A.DGN, \RDWOOD5B.DGN, \RDWOOD5C.DGN, \RDWOOD5D.DGN, \RDWOOD5E.DGN, \RDWOOD5F.DGN, \RDWOOD5G.DGN, \RDWOOD5H.DGN, \RDWOOD5I.DGN, \RDWOOD5J.DGN, \RDWOOD5K.DGN, \RDWOOD5L.DGN, \RDWOOD5M.DGN, \RDWOOD5N.DGN, \RDWOOD5O.DGN, \RDWOOD5P.DGN, \RDWOOD5Q.DGN, \RDWOOD5R.DGN, \RDWOOD5S.DGN, \RDWOOD5T.DGN, \RDWOOD5U.DGN, \RDWOOD5V.DGN, \RDWOOD5W.DGN, \RDWOOD5X.DGN, \RDWOOD5Y.DGN, \RDWOOD5Z.DGN, \RDWOOD6A.DGN, \RDWOOD6B.DGN, \RDWOOD6C.DGN, \RDWOOD6D.DGN, \RDWOOD6E.DGN, \RDWOOD6F.DGN, \RDWOOD6G.DGN, \RDWOOD6H.DGN, \RDWOOD6I.DGN, \RDWOOD6J.DGN, \RDWOOD6K.DGN, \RDWOOD6L.DGN, \RDWOOD6M.DGN, \RDWOOD6N.DGN, \RDWOOD6O.DGN, \RDWOOD6P.DGN, \RDWOOD6Q.DGN, \RDWOOD6R.DGN, \RDWOOD6S.DGN, \RDWOOD6T.DGN, \RDWOOD6U.DGN, \RDWOOD6V.DGN, \RDWOOD6W.DGN, \RDWOOD6X.DGN, \RDWOOD6Y.DGN, \RDWOOD6Z.DGN, \RDWOOD7A.DGN, \RDWOOD7B.DGN, \RDWOOD7C.DGN, \RDWOOD7D.DGN, \RDWOOD7E.DGN, \RDWOOD7F.DGN, \RDWOOD7G.DGN, \RDWOOD7H.DGN, \RDWOOD7I.DGN, \RDWOOD7J.DGN, \RDWOOD7K.DGN, \RDWOOD7L.DGN, \RDWOOD7M.DGN, \RDWOOD7N.DGN, \RDWOOD7O.DGN, \RDWOOD7P.DGN, \RDWOOD7Q.DGN, \RDWOOD7R.DGN, \RDWOOD7S.DGN, \RDWOOD7T.DGN, \RDWOOD7U.DGN, \RDWOOD7V.DGN, \RDWOOD7W.DGN, \RDWOOD7X.DGN, \RDWOOD7Y.DGN, \RDWOOD7Z.DGN, \RDWOOD8A.DGN, \RDWOOD8B.DGN, \RDWOOD8C.DGN, \RDWOOD8D.DGN, \RDWOOD8E.DGN, \RDWOOD8F.DGN, \RDWOOD8G.DGN, \RDWOOD8H.DGN, \RDWOOD8I.DGN, \RDWOOD8J.DGN, \RDWOOD8K.DGN, \RDWOOD8L.DGN, \RDWOOD8M.DGN, \RDWOOD8N.DGN, \RDWOOD8O.DGN, \RDWOOD8P.DGN, \RDWOOD8Q.DGN, \RDWOOD8R.DGN, \RDWOOD8S.DGN, \RDWOOD8T.DGN, \RDWOOD8U.DGN, \RDWOOD8V.DGN, \RDWOOD8W.DGN, \RDWOOD8X.DGN, \RDWOOD8Y.DGN, \RDWOOD8Z.DGN, \RDWOOD9A.DGN, \RDWOOD9B.DGN, \RDWOOD9C.DGN, \RDWOOD9D.DGN, \RDWOOD9E.DGN, \RDWOOD9F.DGN, \RDWOOD9G.DGN, \RDWOOD9H.DGN, \RDWOOD9I.DGN, \RDWOOD9J.DGN, \RDWOOD9K.DGN, \RDWOOD9L.DGN, \RDWOOD9M.DGN, \RDWOOD9N.DGN, \RDWOOD9O.DGN, \RDWOOD9P.DGN, \RDWOOD9Q.DGN, \RDWOOD9R.DGN, \RDWOOD9S.DGN, \RDWOOD9T.DGN, \RDWOOD9U.DGN, \RDWOOD9V.DGN, \RDWOOD9W.DGN, \RDWOOD9X.DGN, \RDWOOD9Y.DGN, \RDWOOD9Z.DGN, \RDWOOD0A.DGN, \RDWOOD0B.DGN, \RDWOOD0C.DGN, \RDWOOD0D.DGN, \RDWOOD0E.DGN, \RDWOOD0F.DGN, \RDWOOD0G.DGN, \RDWOOD0H.DGN, \RDWOOD0I.DGN, \RDWOOD0J.DGN, \RDWOOD0K.DGN, \RDWOOD0L.DGN, \RDWOOD0M.DGN, \RDWOOD0N.DGN, \RDWOOD0O.DGN, \RDWOOD0P.DGN, \RDWOOD0Q.DGN, \RDWOOD0R.DGN, \RDWOOD0S.DGN, \RDWOOD0T.DGN, \RDWOOD0U.DGN, \RDWOOD0V.DGN, \RDWOOD0W.DGN, \RDWOOD0X.DGN, \RDWOOD0Y.DGN, \RDWOOD0Z.DGN