



PLAN	DATE
BY	
REVISIONS	
NO.	
DATE	
BY	
REVISIONS	
NO.	
DATE	
BY	
REVISIONS	
NO.	
DATE	

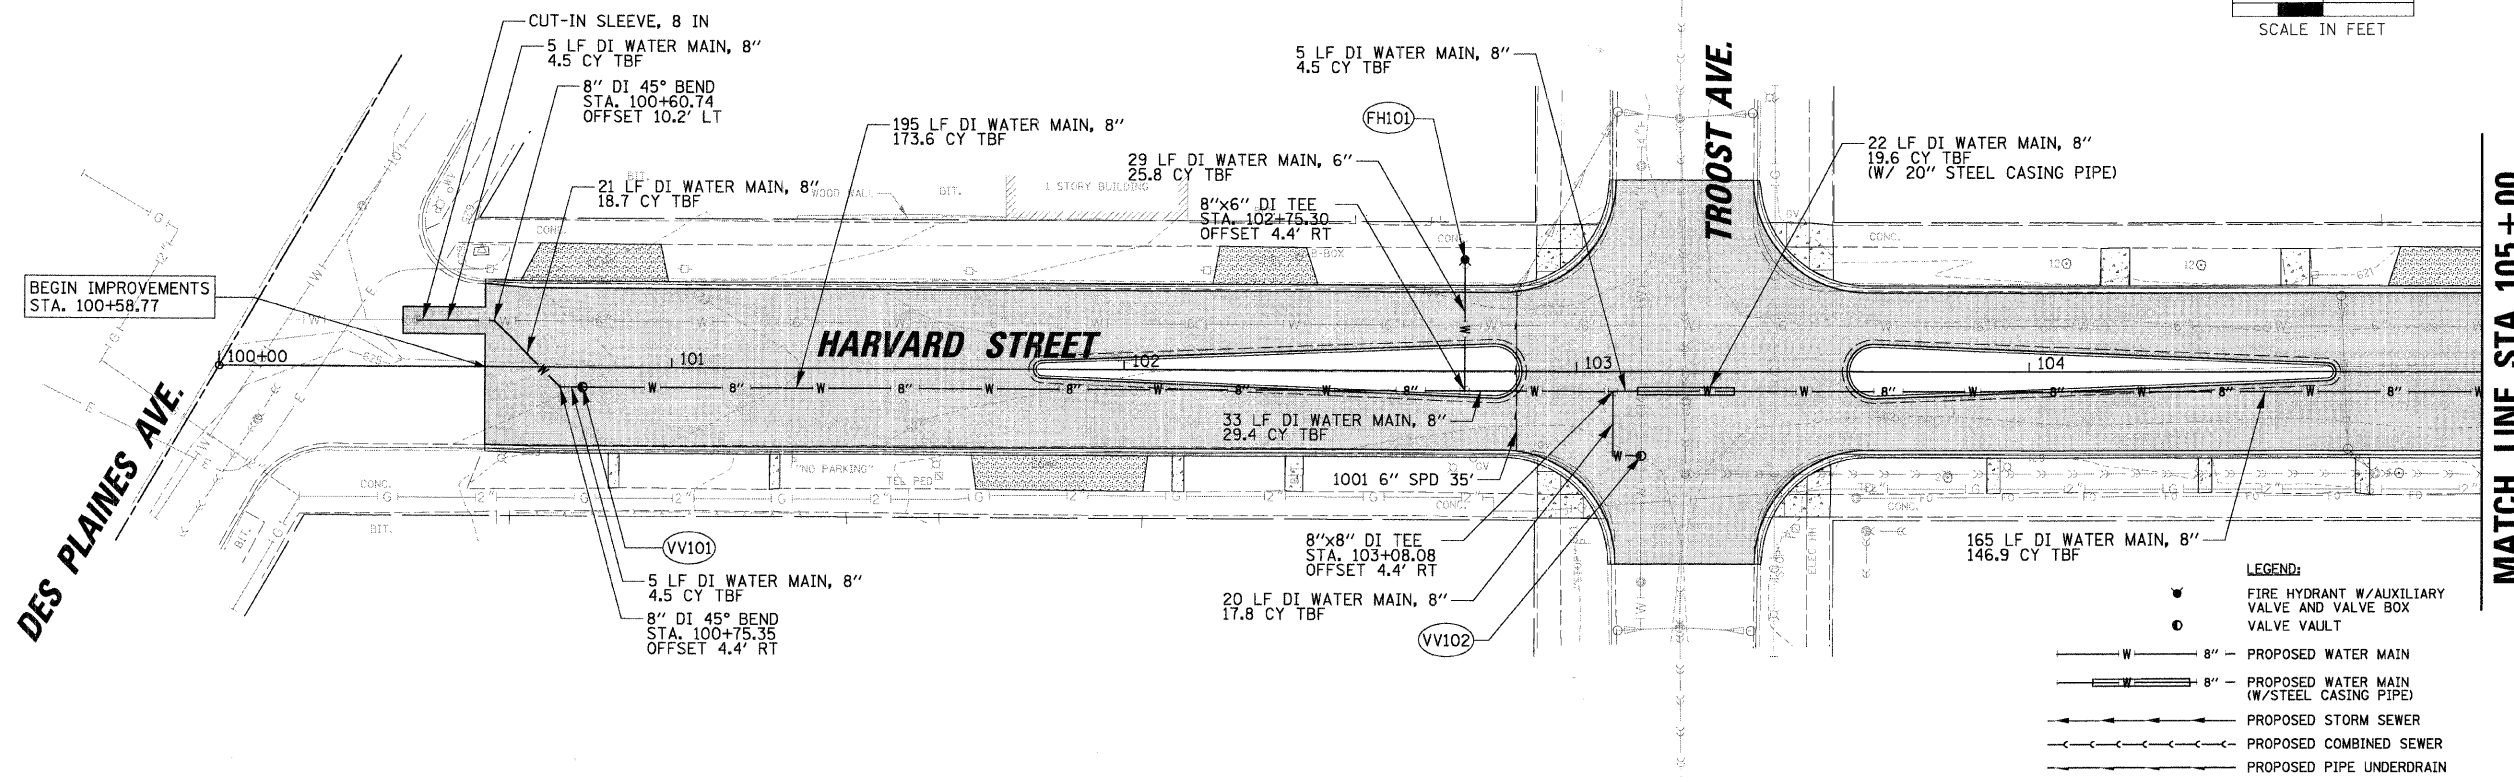

- LEGEND:**
- FIRE HYDRANT W/AUXILIARY VALVE AND VALVE BOX
 - VALVE VAULT
 - W — 8" — PROPOSED WATER MAIN
 - W — 8" — PROPOSED WATER MAIN (W/STEEL CASING PIPE)
 - S — PROPOSED STORM SEWER
 - C — PROPOSED COMBINED SEWER
 - U — PROPOSED PIPE UNDERDRAIN

PROFILE	DATE
BY	
REVISIONS	
NO.	
DATE	
BY	
REVISIONS	
NO.	
DATE	
BY	
REVISIONS	
NO.	
DATE	

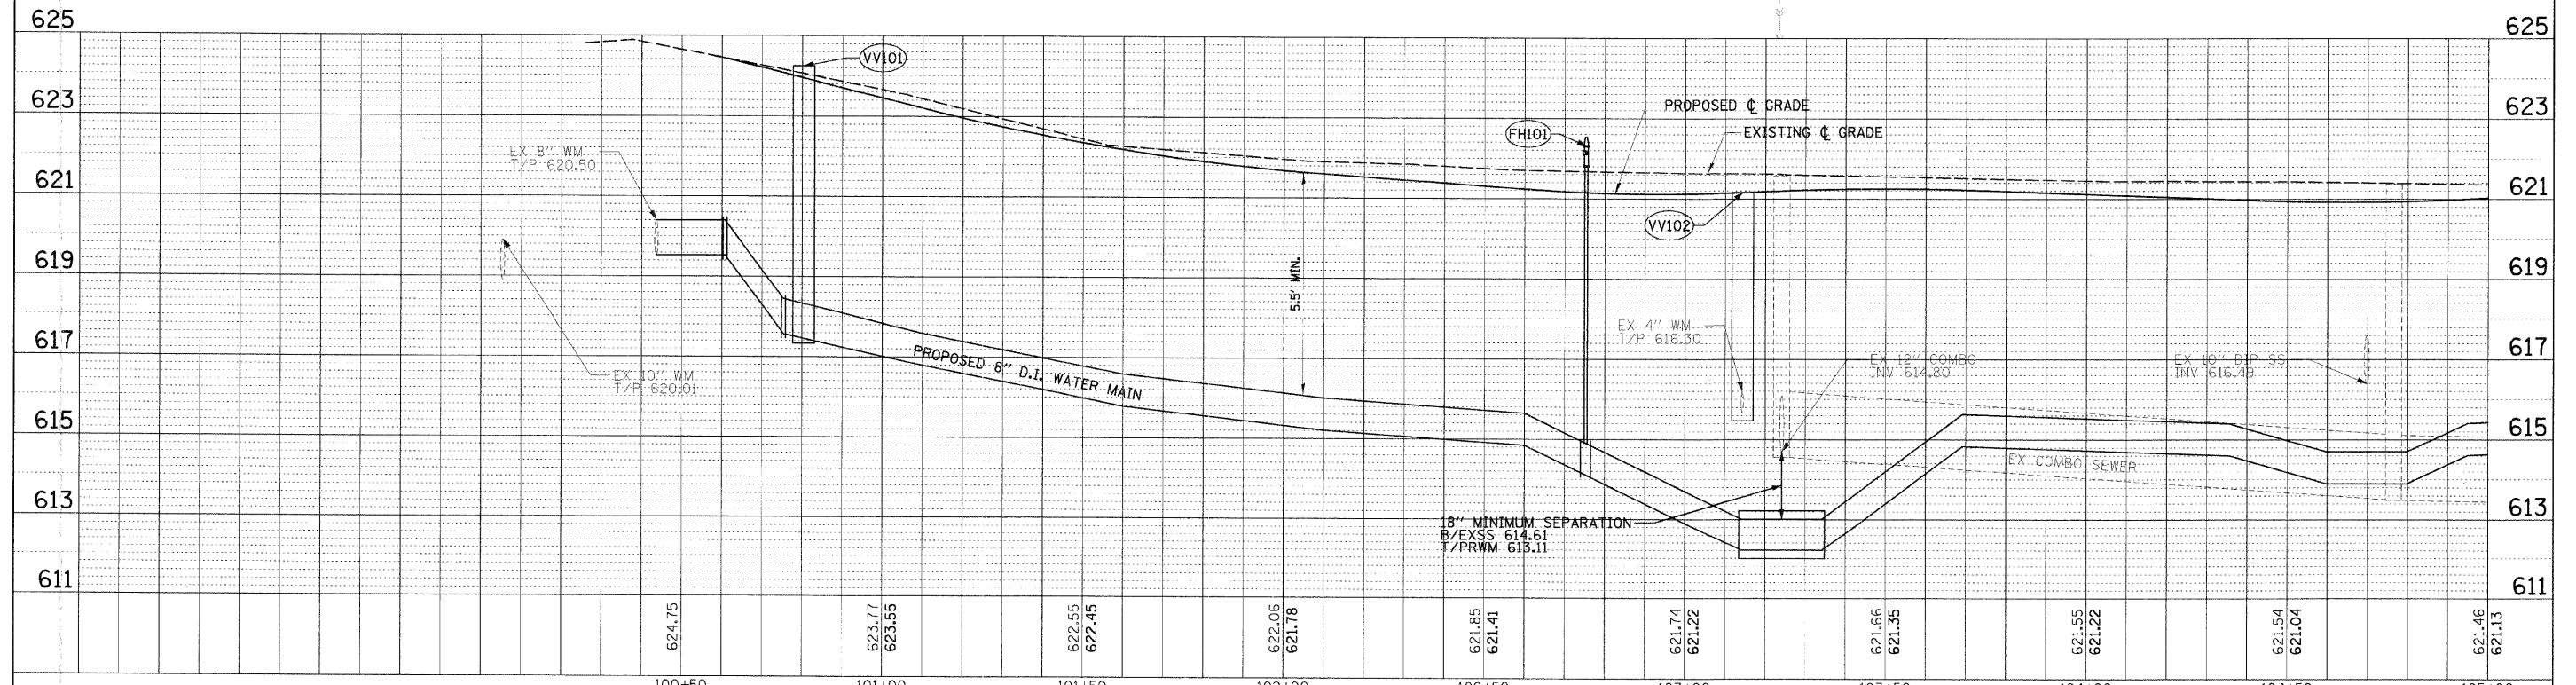

FILE NAME =	USER NAME = JBARNETT	DESIGNED -	REVISED -	STATE OF ILLINOIS DEPARTMENT OF TRANSPORTATION	DRAINAGE AND UTILITIES PLAN AND PROFILE - HARVARD STREET STA. 100+00.00 TO STA. 105+00.00	F.A.U. RTE.	SECTION	COUNTY	TOTAL SHEETS	SHEET NO.	
N:\FORESTPARK\070002\Civil\1\DP-070002-01.DWG	PLLOT SCALE = 20'	DRAWN -	REVISED -			1702	07-00106-00-PV	COOK	75	22	
	PLLOT DATE = 2/18/2009	CHECKED -	REVISED -			CONTRACT NO. 63148					
		DATE -	REVISED -			SCALE:	SHEET NO.	OF	SHEETS	STA.	TO STA.