
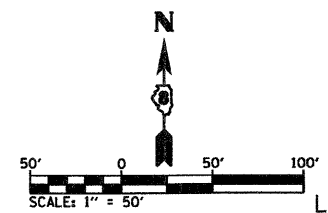
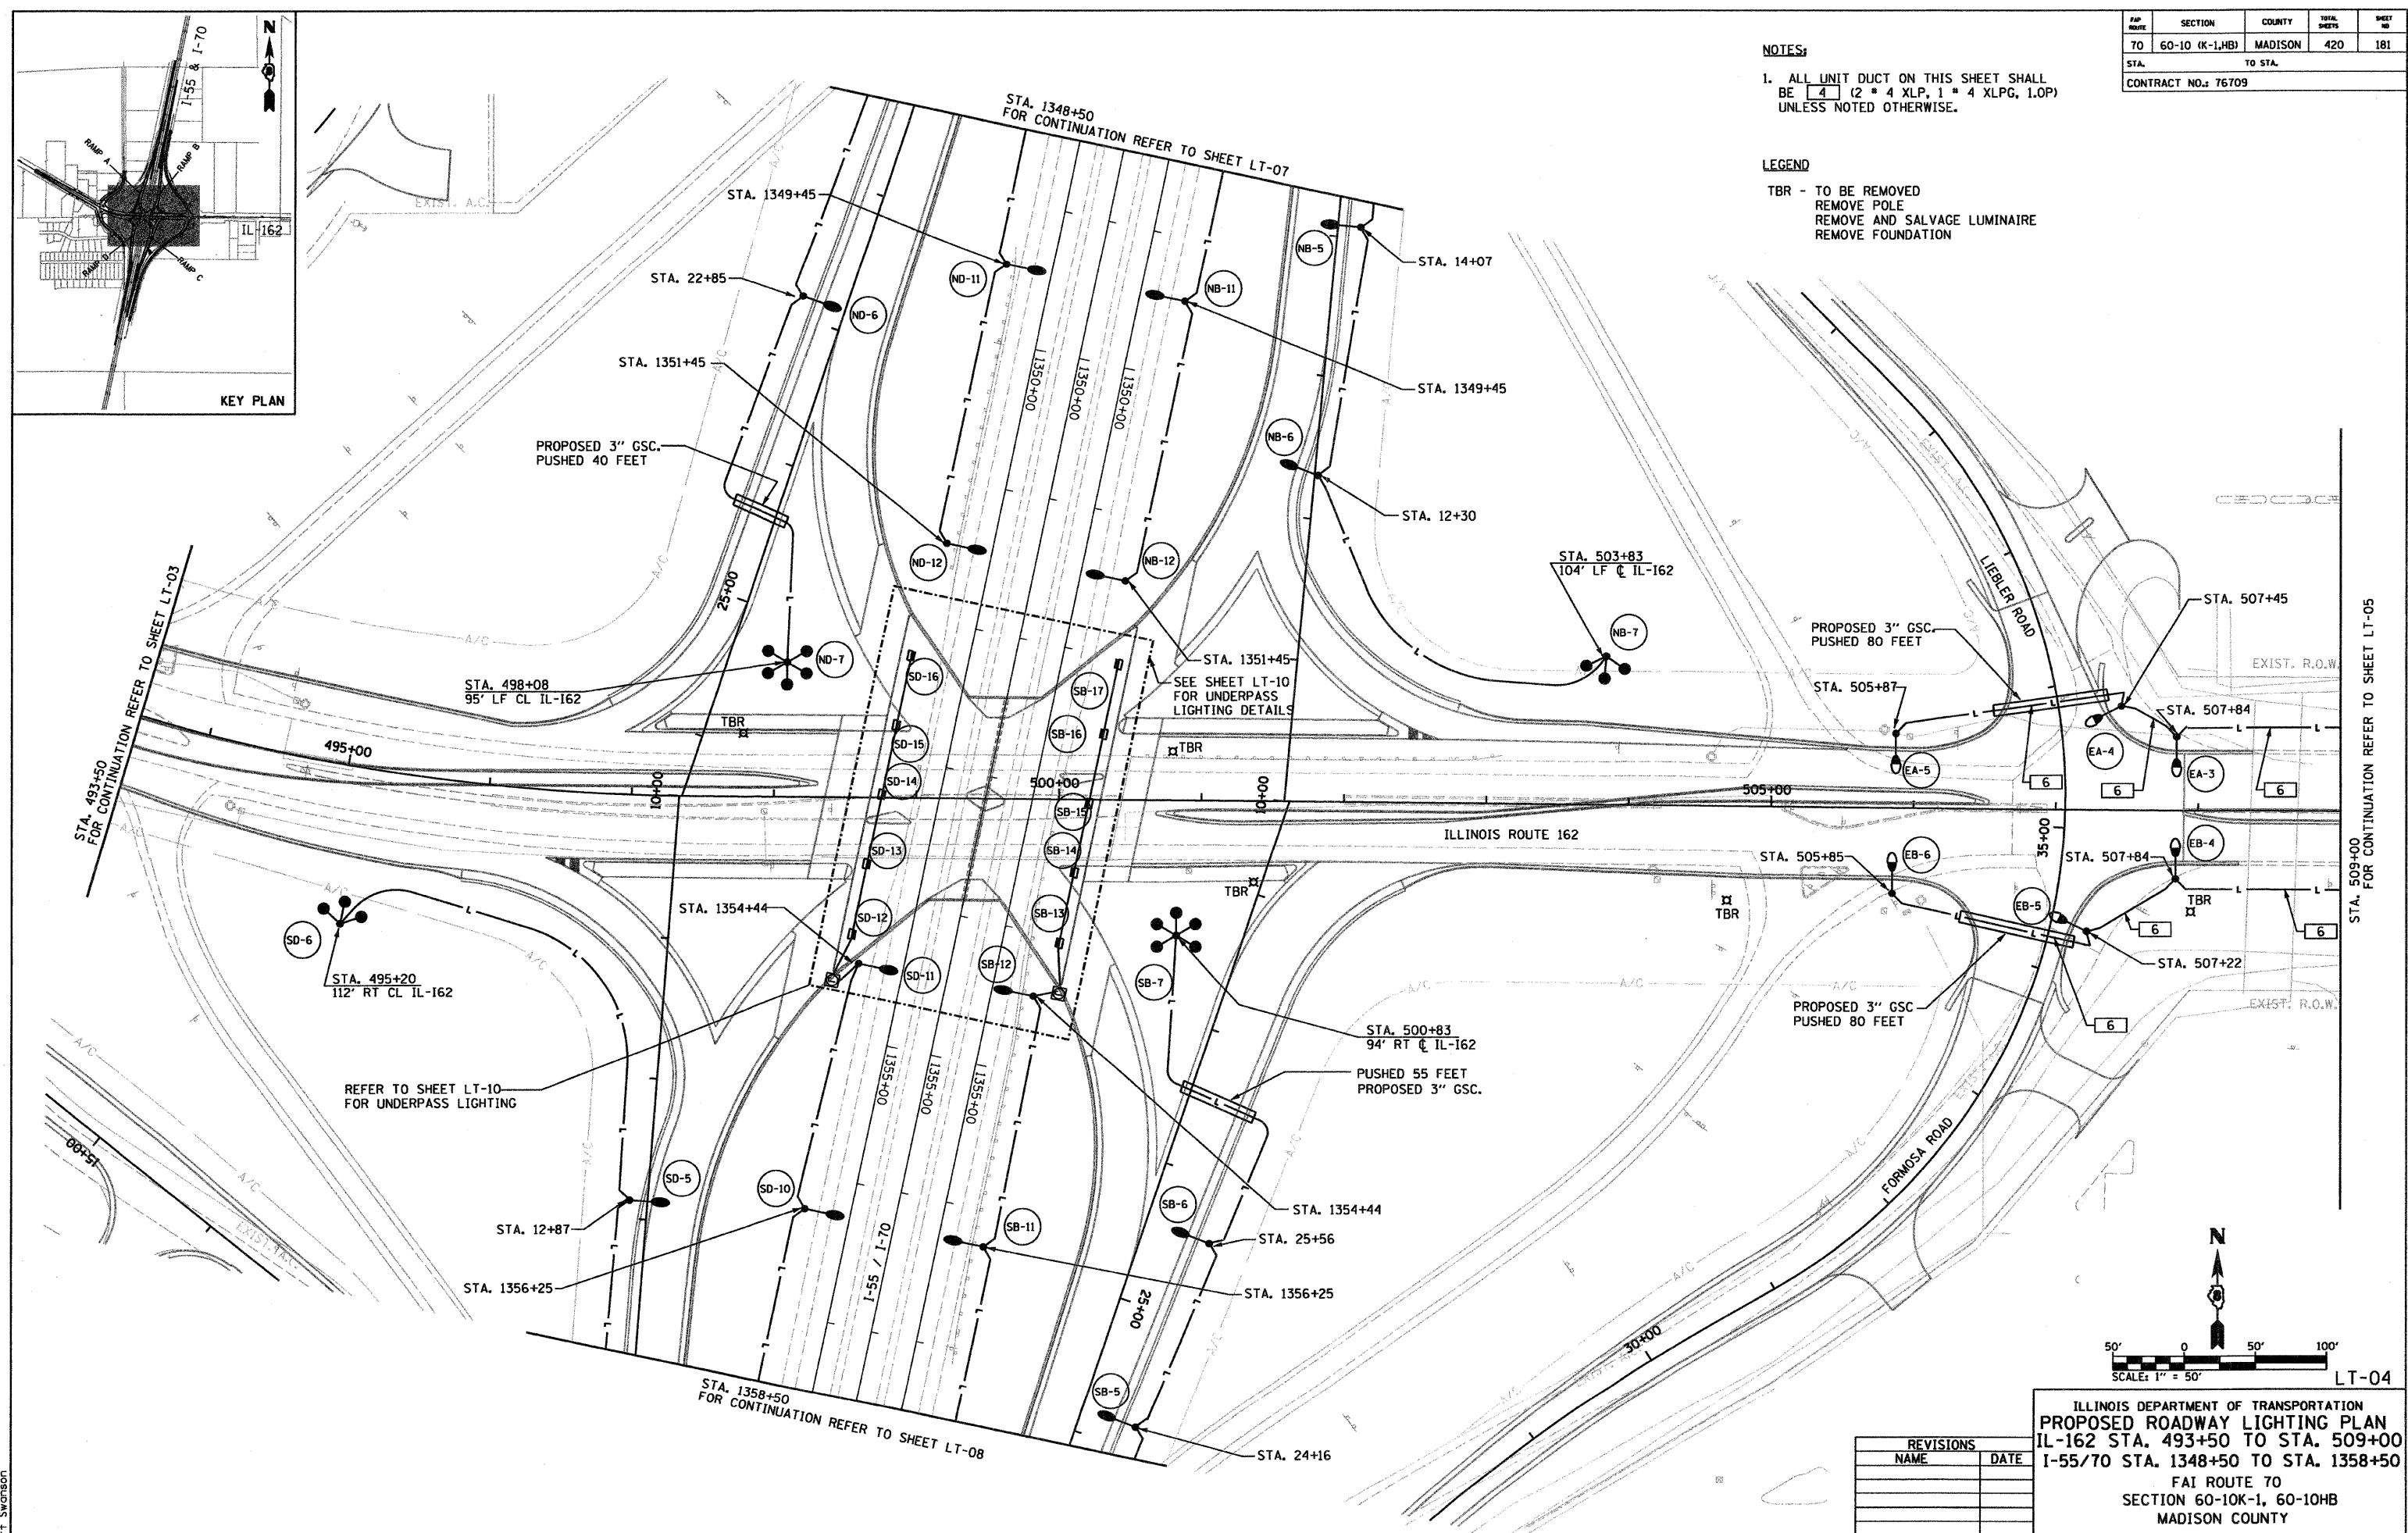


FAP ROUTE	SECTION	COUNTY	TOTAL SHEETS	SHEET NO.
TO 60-10 (K-1,HB)	MADISON	420	181	
STA.	TO STA.			
CONTRACT NO.: 76709				

NOTES:
 1. ALL UNIT DUCT ON THIS SHEET SHALL BE 4 (2 * 4 XLP, 1 * 4 XLPG, 1.0P) UNLESS NOTED OTHERWISE.

LEGEND
 TBR - TO BE REMOVED
 REMOVE POLE
 REMOVE AND SALVAGE LUMINAIRE
 REMOVE FOUNDATION

DATE	BY	REVISION

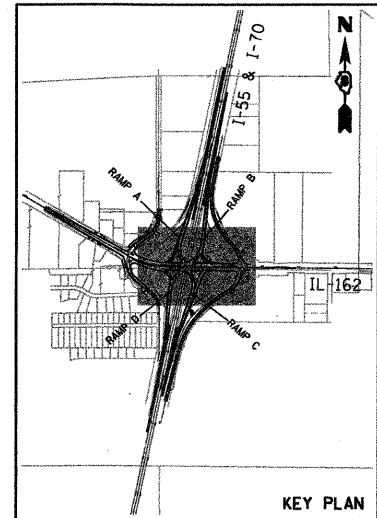

REVISIONS	
NAME	DATE

ILLINOIS DEPARTMENT OF TRANSPORTATION
PROPOSED ROADWAY LIGHTING PLAN
 IL-162 STA. 493+50 TO STA. 509+00
 I-55/70 STA. 1348+50 TO STA. 1358+50
 FAI ROUTE 70
 SECTION 60-10K-1, 60-10HB
 MADISON COUNTY

DRAWN BY: RPJ CHECKED BY: A. OSHANA, P.E.

XXXXXXX - IDOT IL 162 over I-55,70 revisions
 236-LT-04.dgn
 1/28/2009
 10:23:37 PM
 Robert T. Swanson