




F.A. RTE.	SECTION	COUNTY	TOTAL SHEETS	SHEET NO.
374	3268F-R-1	COOK	279	213
STA.		TO STA.		
FED. ROAD DIST. NO.		ILLINOIS FED. AID PROJECT		

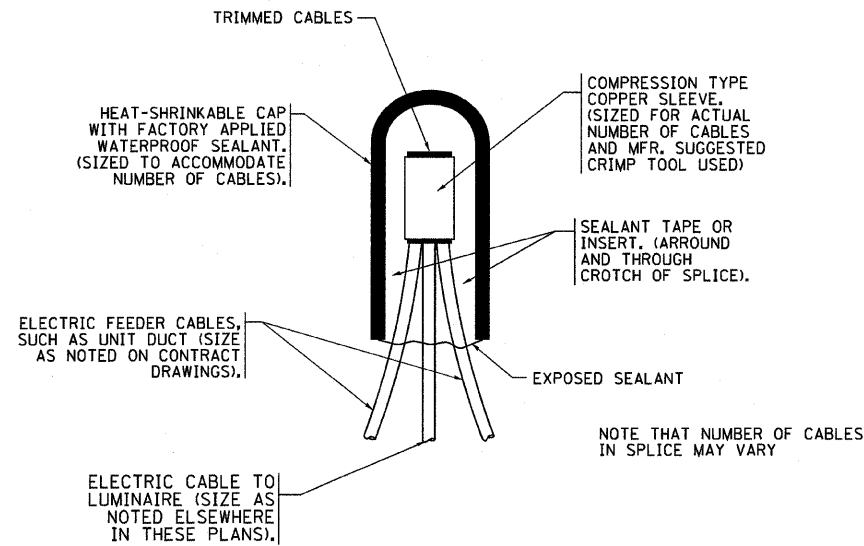

TYPICAL SPLICE DETAIL
N.T.S.

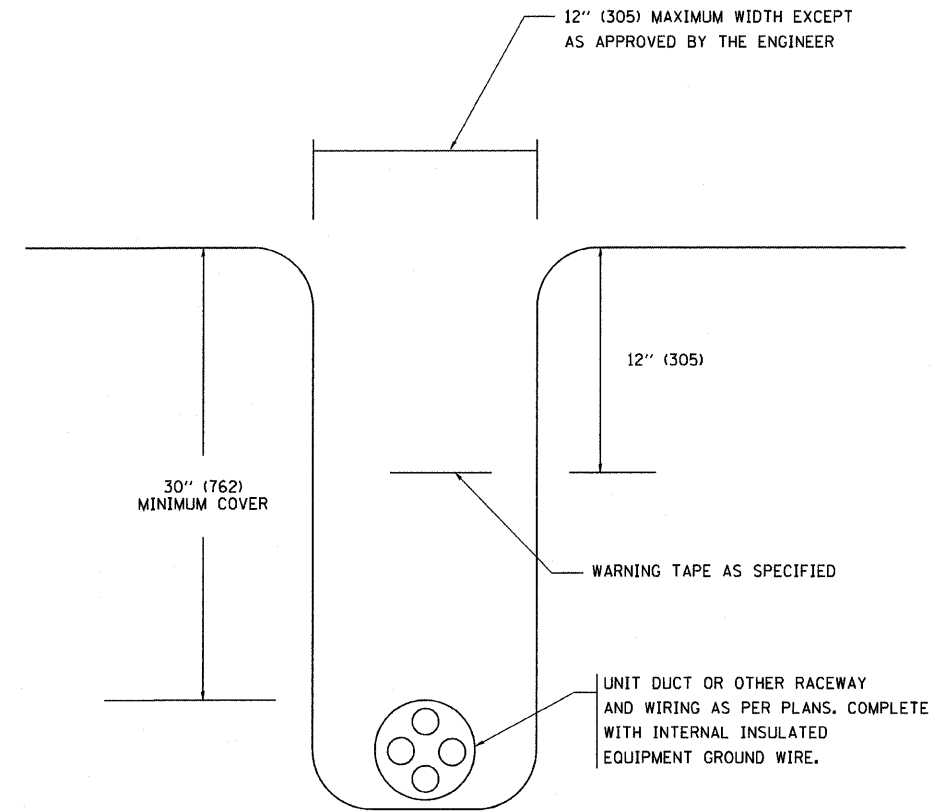

TYPICAL WIRING IN TRENCH DETAIL
N.T.S.

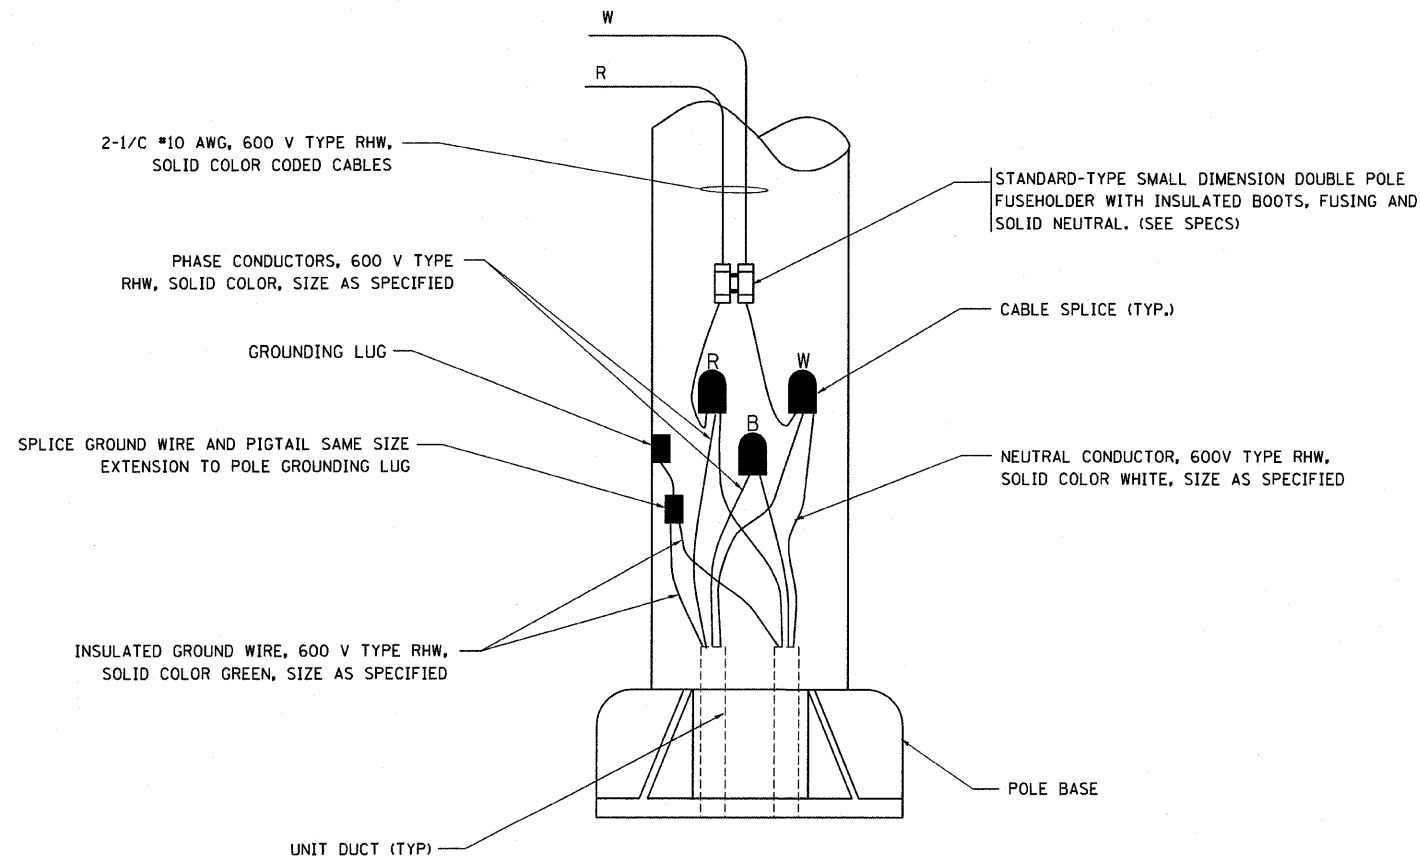

POLE WIRING DETAIL
N.T.S.

PLOT DATE = 1/18/2007
 FILE NAME = c:\projects\stas\stas\lt14.dgn
 PLOT SCALE = 58.800 / IN.
 USER NAME = geglennob

REVISIONS	
NAME	DATE

ILLINOIS DEPARTMENT OF TRANSPORTATION

MISC. ELECTRICAL DETAILS
SHEET A

SCALE: VERT. / HORIZ.
DATE: 1/18/2007

DRAWN BY

CHECKED BY

BE-702

REVISION DATE: 01/01/07