
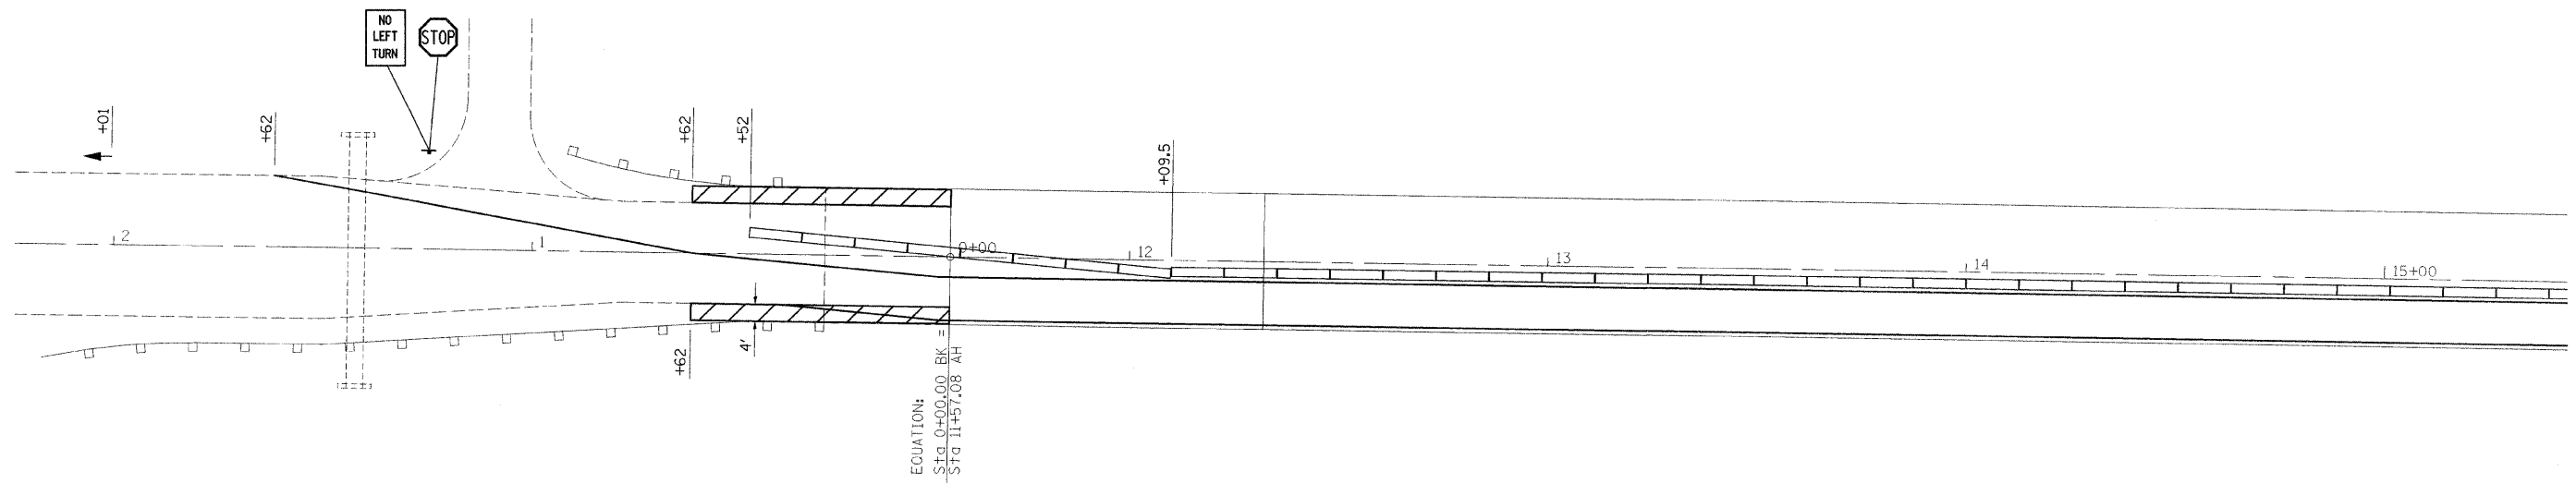


SUGGESTED SEQUENCE OF OPERATION

1. CONSTRUCT BASE COURSE WIDENING USING TRAFFIC CONTROL STANDARD 701326.
2. ERECT SIGNS, TRAFFIC SIGNALS, TEMPORARY BARRIERS, ECT. ACCORDING TO TRAFFIC CONTROL STANDARD 701321.
3. PLACE TEMPORARY PAVEMENT MARKING ACCORDING TO TRAFFIC CONTROL STANDARD 701321.
4. REMOVE THE EXISTING DECK BEAMS FOR STAGE I CONSTRUCTION.
5. PLACE NEW DECK BEAMS FOR STAGE I.

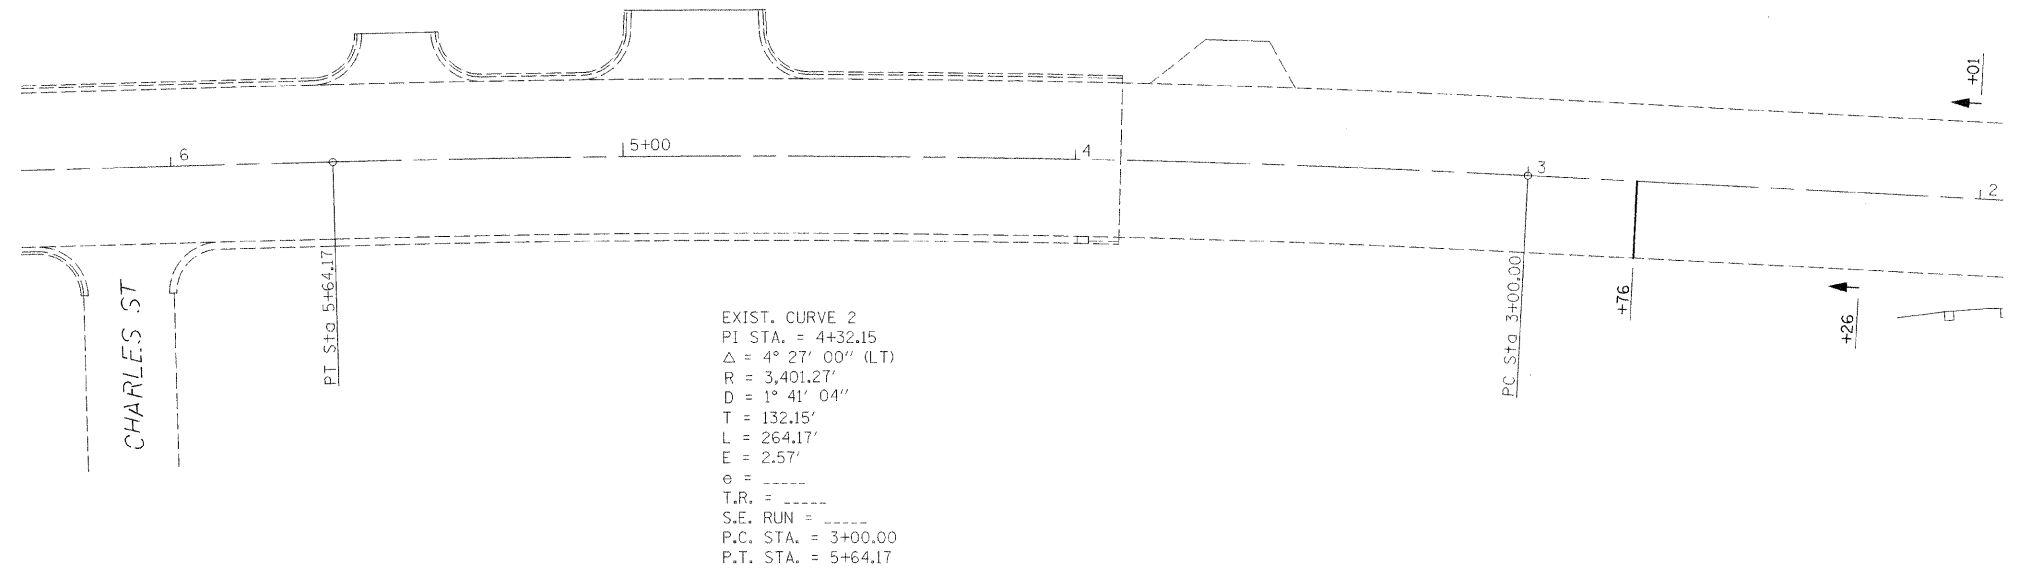

BASE COURSE WIDENING

FILE NAME = c:\projects\74290d\shp1en_74290.dgn	USER NAME = swartzw	DESIGNED - JDW	REVISED -	STATE OF ILLINOIS DEPARTMENT OF TRANSPORTATION	STAGE I CONSTRUCTION			F.A.P. RTE. 332	SECTION D7 BEAM REPAIR 2008-2	COUNTY LAWRENCE	TOTAL SHEETS 11	SHEET NO. 5
					SCALE: 20			SHEET NO. OF SHEETS STA. 8+00 TO STA. 15+00			CONTRACT NO. 74290	
					FED. ROAD DIST. NO.			ILLINOIS FED. AID PROJECT				
					PLOT SCALE = 20.0000' / IN.							
				PLOT DATE = 2/5/2008								